



Nama/NIM

Gabrielle Phoebe
0206031910014


Judul Gambar

Layout

Skala

1:1000

Keterangan

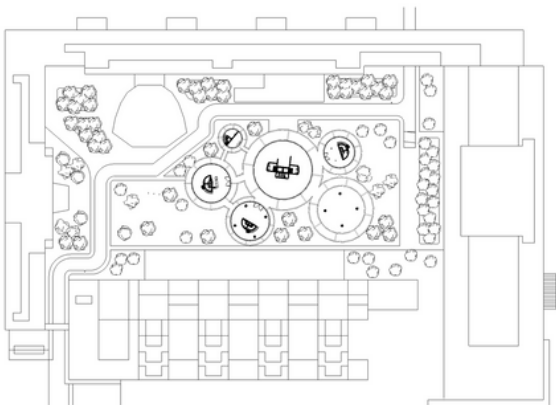

Layout
02/02/2024



Nama/NIM

Gabrielle Phoebe
0206031910014


Judul Gambar

Layout

Skala

1:1000

Keterangan

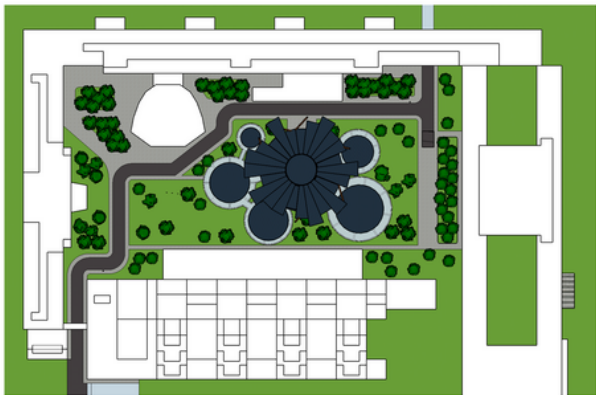

Site Plan
2022



Nama/NIM

Gabrielle Phoebe
0206031910014


Judul Gambar

DENAH PARKIRAN

Skala

1:500

Keterangan

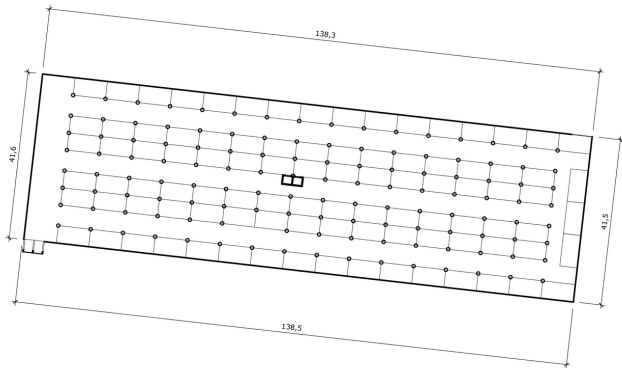

Nama/NIM

Gabrielle Phoebe
0206031910014


Judul Gambar

DENAH LANTAI 1

Skala

1:500

Keterangan

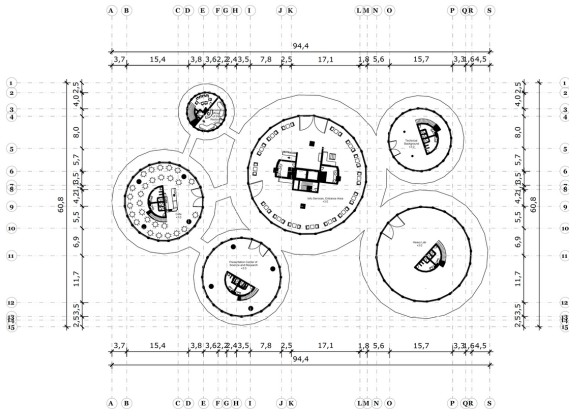

Nama/NIM

Gabrielle Phoebe
0206031910014


Judul Gambar

DENAH LANTAI 2

Skala

1:500

Keterangan

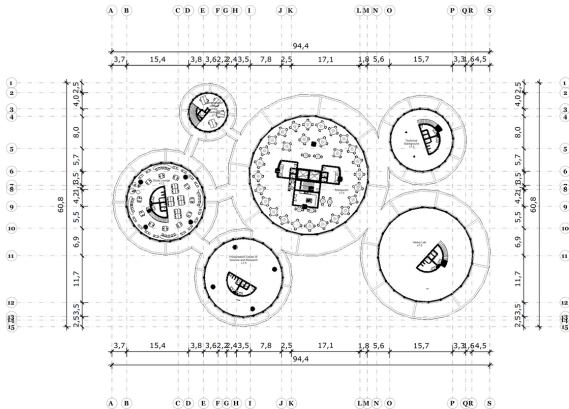

Nama/NIM

Gabrielle Phoebe
0206031910014


Judul Gambar

DENAH LANTAI 3

Skala

1:500

Keterangan

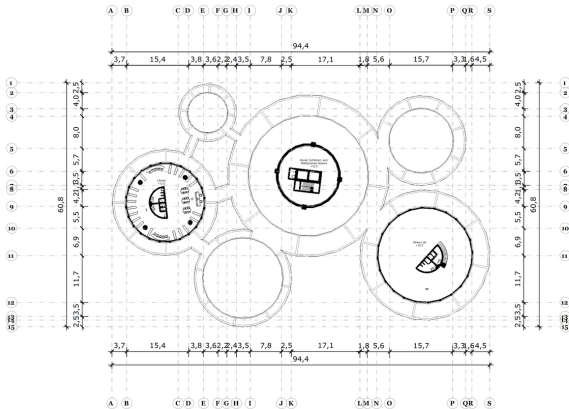

Nama/NIM

Gabrielle Phoebe
0206031910014


Judul Gambar


DENAH LANTAI 4

Skala

1:500

Keterangan

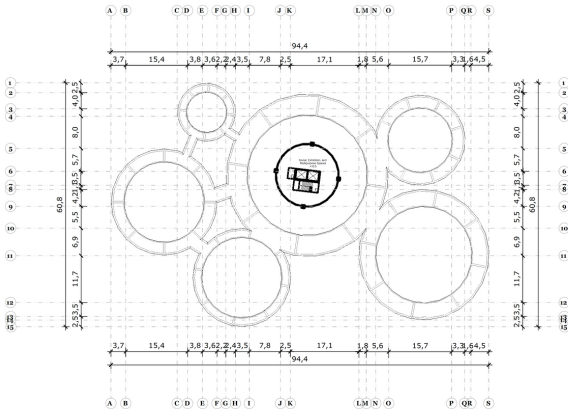

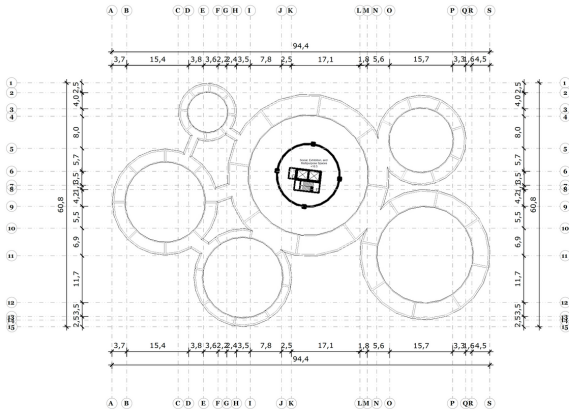

Nama/NIM

Gabrielle Phoebe
0206031910014


Judul Gambar

DENAH LANTAI 6

Skala

1:500

Keterangan

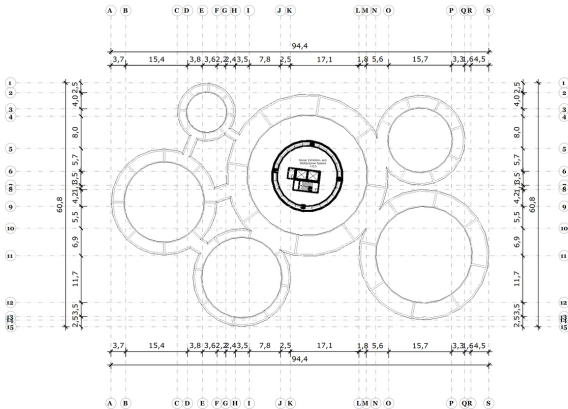

Nama/NIM

Gabrielle Phoebe
0206031910014


Judul Gambar

DENAH LANTAI 7

Skala

1:500

Keterangan

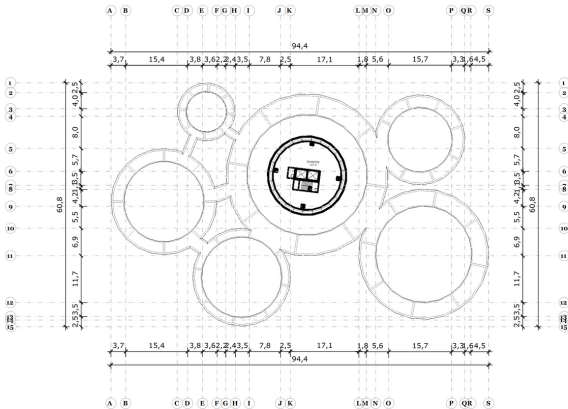

Nama/NIM

Gabrielle Phoebe
0206031910014


Judul Gambar

DENAH LANTAI 8

Skala

1:500

Keterangan

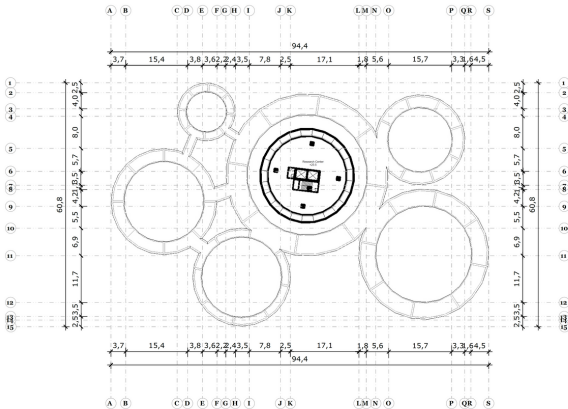

Nama/NIM

Gabrielle Phoebe
0206031910014


Judul Gambar

DENAH LANTAI 9

Skala

1:500

Keterangan

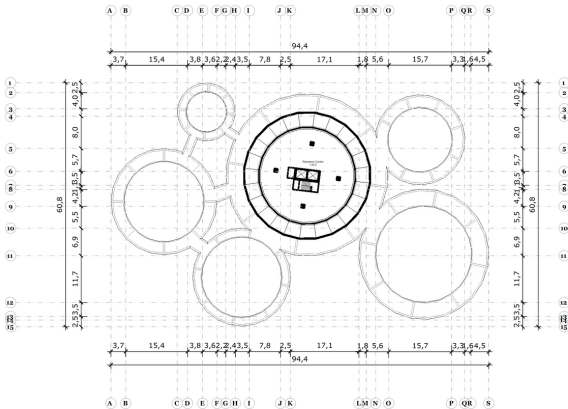

Nama/NIM

Gabrielle Phoebe
0206031910014


Judul Gambar

DENAH LANTAI 10

Skala

1:500

Keterangan

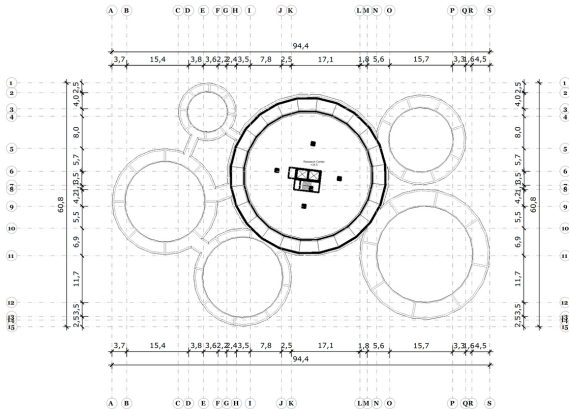

Nama/NIM

Gabrielle Phoebe
0206031910014


Judul Gambar

DENAH LANTAI 11

Skala

1:500

Keterangan

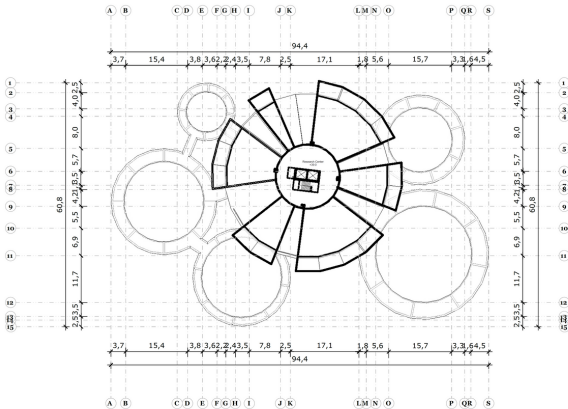

Nama/NIM

Gabrielle Phoebe
0206031910014


Judul Gambar

DENAH LANTAI 12

Skala

1:500

Keterangan

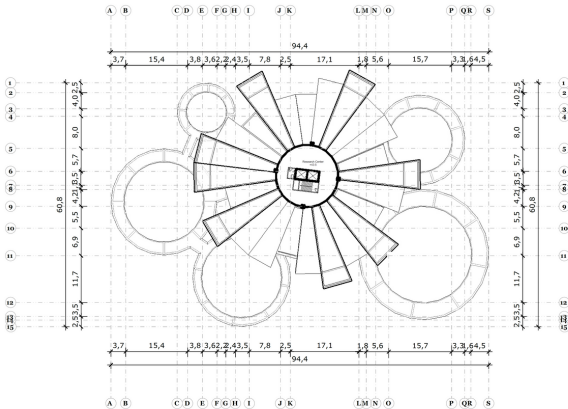



Nama/NIM

Gabrielle Phoebe
0206031910014


Judul Gambar

POTONGAN

Skala

1:500

Keterangan

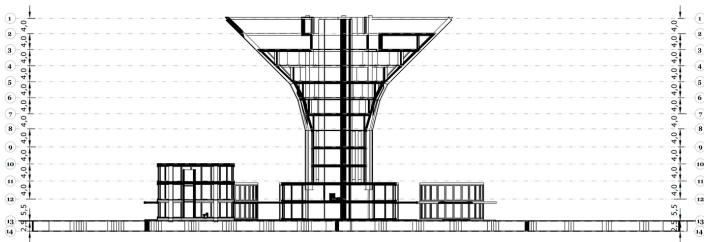

POTONGAN A-A
SKALA 1:500



Nama/NIM

Gabrielle Phoebe
0206031910014


Judul Gambar

POTONGAN

Skala

1:500

Keterangan

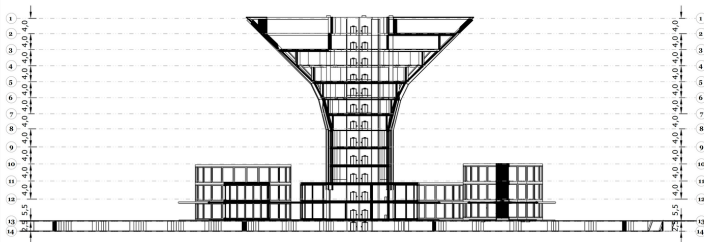

POTONGAN B-B
SKALA 1:500



Nama/NIM

Gabrielle Phoebe
0206031910014


Judul Gambar

POTONGAN

Skala

1:500

Keterangan

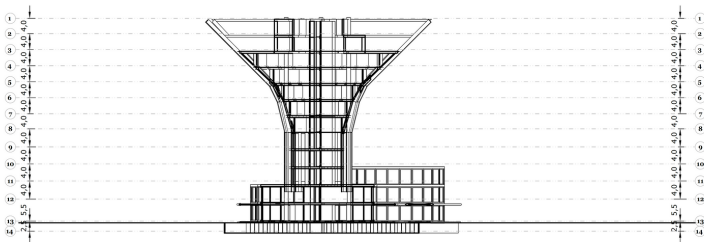

POTONGAN C-C
SKALA 1:500



Nama/NIM

Gabrielle Phoebe
0206031910014


Judul Gambar

POTONGAN

Skala

1:500

Keterangan

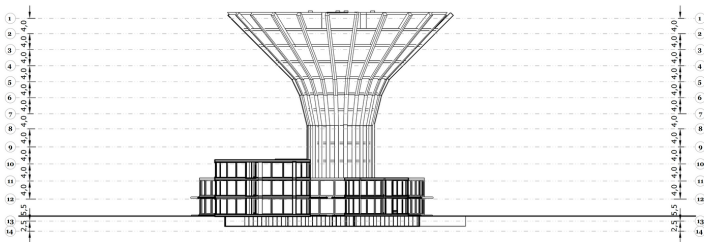

POTONGAN D-D
SKALA 1:500



Nama/NIM

Gabrielle Phoebe
0206031910014



Judul Gambar

Elevation 1 & 2

Skala

1:500

Keterangan

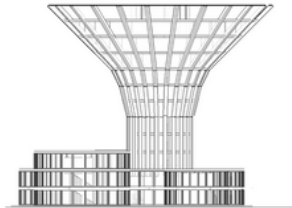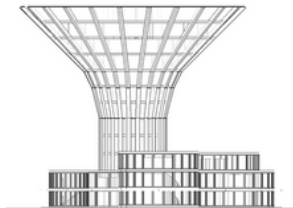

View From Jember Street
20/01/2020

View From Idrisda Karaha Street
20/01/2020



Nama/NIM

Gabrielle Phoebe
0206031910014


Judul Gambar

Elevation 3 & 4


Skala

1:500

Keterangan

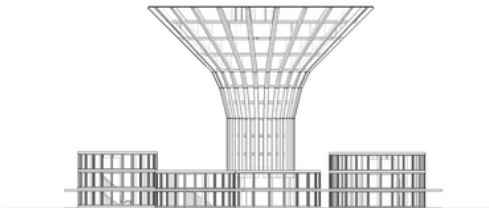

View From Radzabika Street
26/04/2020

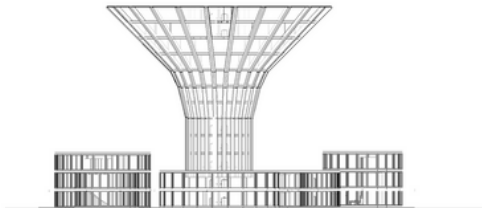

View From Hiasate Gabydy Street
26/04/2020



Nama/NIM

Gabrielle Phoebe
0206031910014


Judul Gambar

DETAIL
ARSITEKTURAL

Skala

1:300

Keterangan

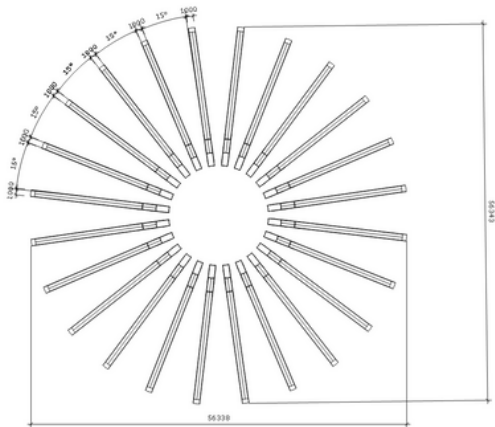



Nama/NIM


Gabrielle Phoebe
0206031910014

Judul Gambar

DETAIL
ARSITEKTURAL

Skala

Keterangan

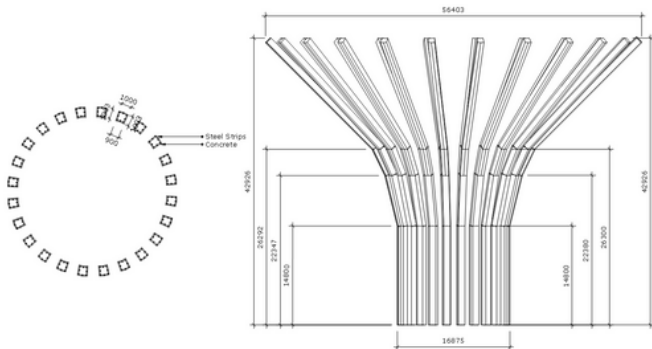

POTONGAN EKOSKELETON
2500 x 1000

TAMPAK SAMPING EKOSKELETON
2500 x 1000



Nama/NIM

Gabrielle Phoebe
0206031910014


Judul Gambar

DETAIL
ARSITEKTURAL

Skala

1:300

Keterangan

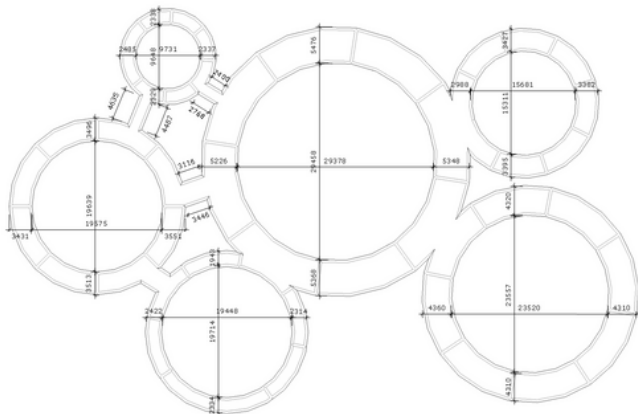



Nama/NDM

 
Gabrielle Phoebe
0206031910014


Judul Gambar

DETAIL
ARSITEKTURAL

Skala

Keterangan



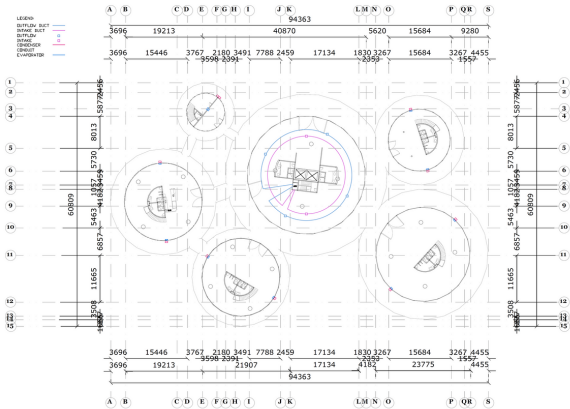

Nama/NIM

Gabrielle Phoebe
0206031910014

Judul Gambar


HVAC LANTAI 1

Skala

1:500

Keterangan

LEGEND:
 OUTFLOW DUCT
 INFAME DUCT
 OUTFLOW
 INFAME
 CONDENSER
 FRESHET
 EVAPORATOR

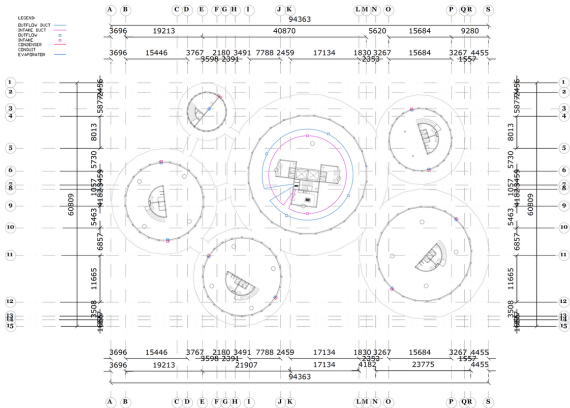

Nama/NIM

Gabrielle Phoebe
 0206031910014


Judul Gambar

HVAC LANTAI 2

Skala

1:500

Keterangan

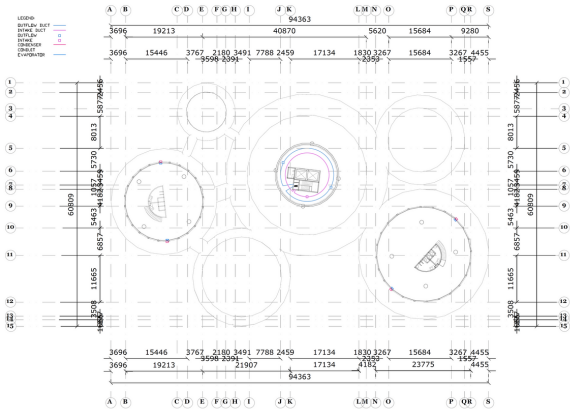

Nama/NIM

Gabrielle Phoebe
0206031910014


Judul Gambar

HVAC LANTAI 3

Skala

1:500

Keterangan

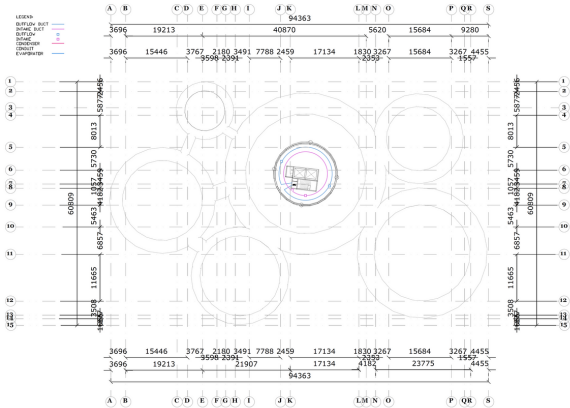

Nama/NIM

Gabrielle Phoebe
0206031910014


Judul Gambar

HVAC LANTAI 4

Skala

1:500

Keterangan

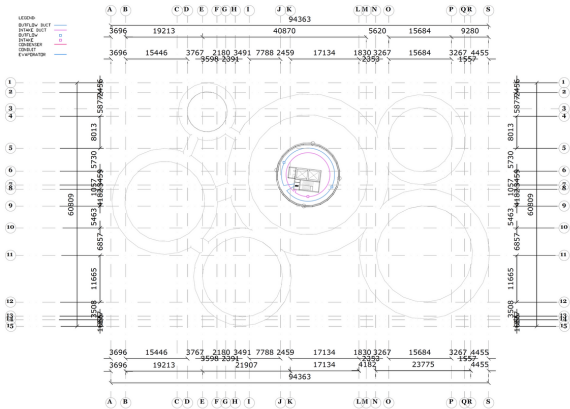

Nama/NIM

Gabrielle Phoebe
0206031910014


Judul Gambar

HVAC LANTAI 5

Skala

1:500

Keterangan

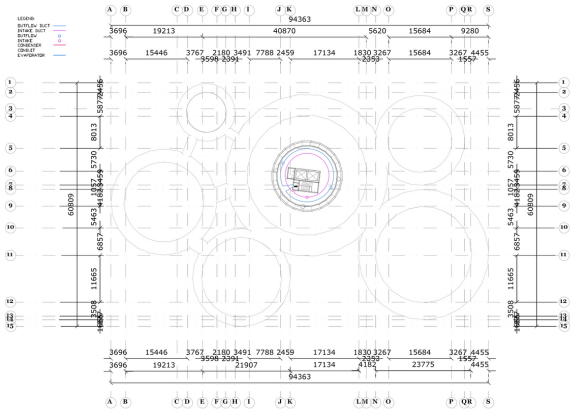

Nama/NIM

Gabrielle Phoebe
0206031910014

Judul Gambar

HVAC LANTAI 6

Skala

1:500

Keterangan

Nama/NIM

Gabrielle Phoebe
0206031910014


Judul Gambar


HVAC LANTAI 7

Skala

1:500

Keterangan

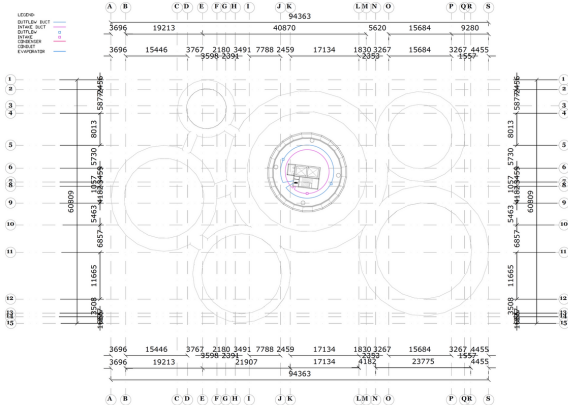

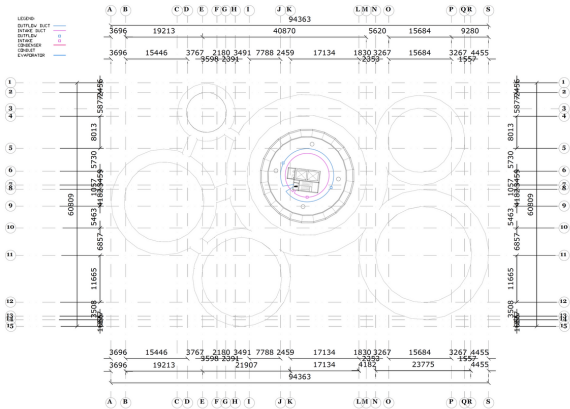

Nama/NIM

Gabrielle Phoebe
0206031910014


Judul Gambar

HVAC LANTAI 8

Skala

1:500

Keterangan

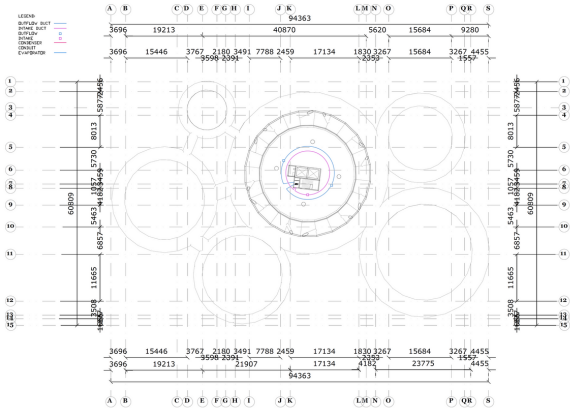

Nama/NIM

Gabrielle Phoebe
0206031910014

Judul Gambar

HVAC LANTAI 9

Skala

1:500

Keterangan

Nama/NIM

Gabrielle Phoebe
0206031910014


Judul Gambar


HVAC LANTAI 10

Skala

1:500

Keterangan

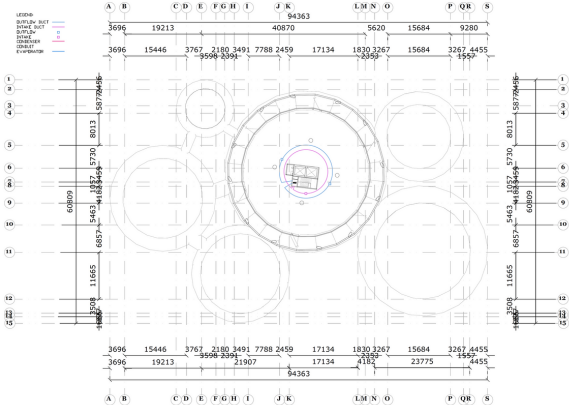

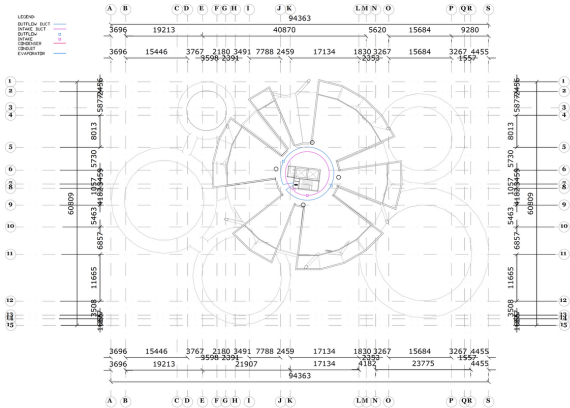

Nama/NIM

Gabrielle Phoebe
0206031910014


Judul Gambar

HVAC LANTAI 11


Skala

1:500

Keterangan

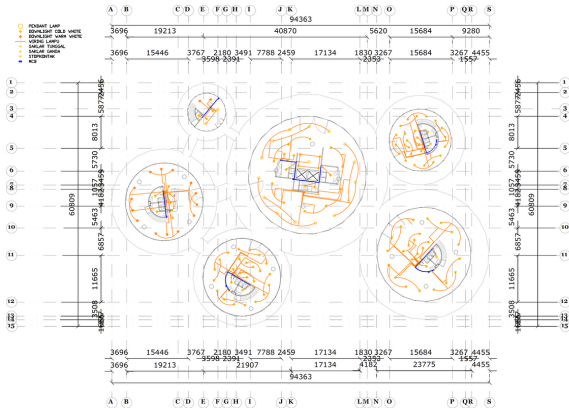


Nama/NIM
Gabrielle Phoebe 0206031910014
Judul Gambar
LIGHTING DAN ELEKTRIKAL LANTAI 1
Skala
1:500
Keterangan

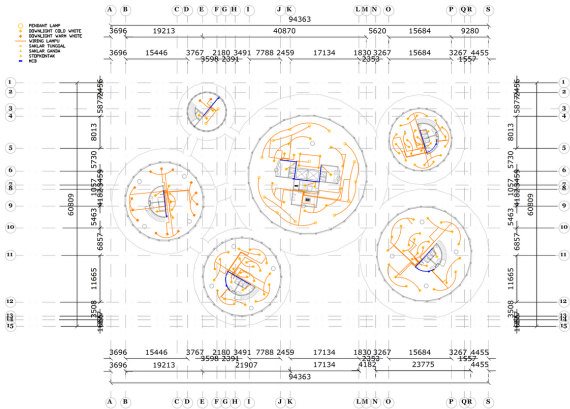

Lantai 2
SKALA 1:500

Nama/NIM
Gabrielle Phoebe 0206031910014
Judul Gambar
LIGHTING DAN ELEKTRIKAL LANTAI 2
Skala
1:500
Keterangan

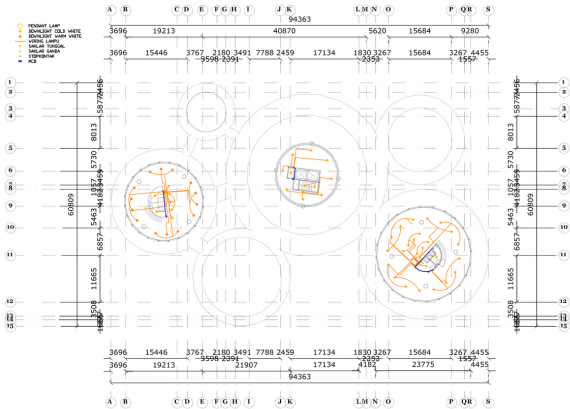

Nama/NIM

Gabrielle Phoebe
0206031910014


Judul Gambar

LIGHTING DAN
ELEKTRIKAL
LANTAI 3

Skala


1:500

Keterangan

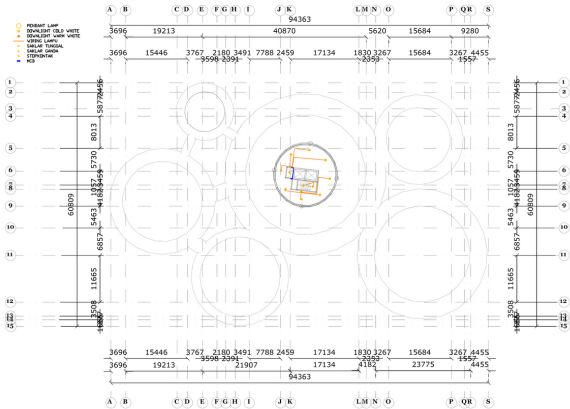


Lantai 4
SKALA 1:500

Nama/NIM
Gabrielle Phoebe 0206031910014
Judul Gambar
LIGHTING DAN ELEKTRIKAL LANTAI 4
Skala
1:500
Keterangan

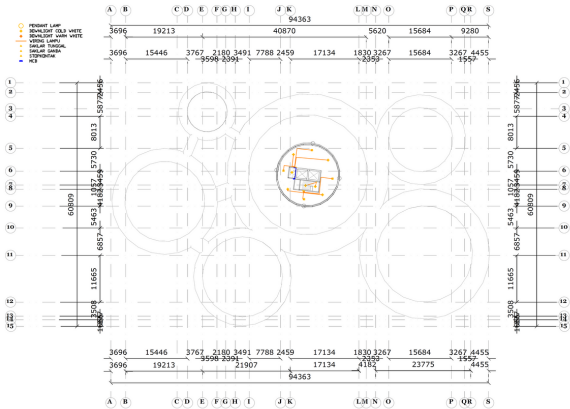


Lantai 5
SKALA 1:500

Nama/NIM
Gabrielle Phoebe 0206031910014
Judul Gambar
LIGHTING DAN ELEKTRIKAL LANTAI 5
Skala
1:500
Keterangan

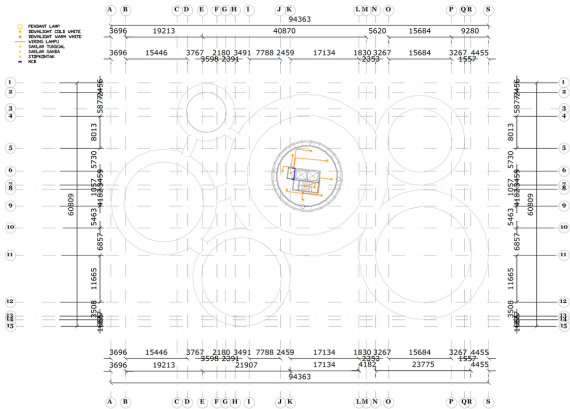

Lantai 6
 SKALA 1:500

Nama/NIM
Gabrielle Phoebe 0206031910014
Judul Gambar
LIGHTING DAN ELEKTRIKAL LANTAI 6
Skala
1:500
Keterangan

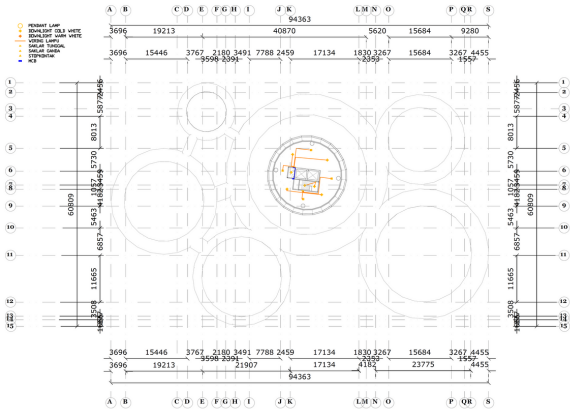

Nama/NIM

Gabrielle Phoebe
0206031910014


Judul Gambar

LIGHTING DAN
ELEKTRIKAL
LANTAI 7

Skala

1:500

Keterangan

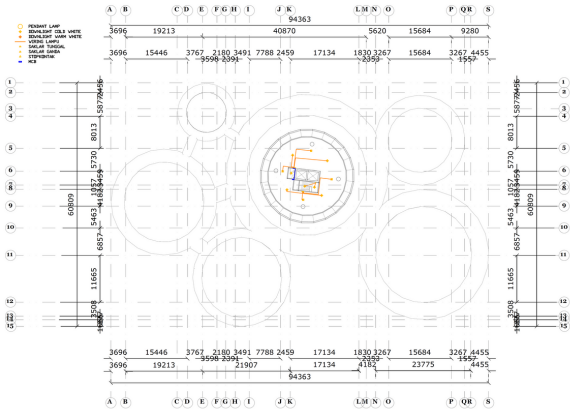

Nama/NIM

Gabrielle Phoebe
0206031910014


Judul Gambar

LIGHTING DAN
ELEKTRIKAL
LANTAI 8

Skala

1:500

Keterangan

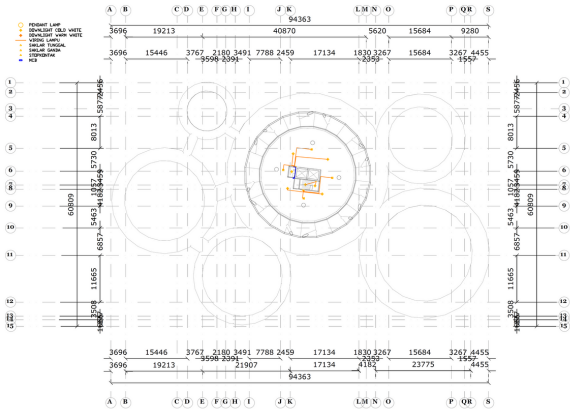

Nama/NIM

Gabrielle Phoebé
0206031910014


Judul Gambar

LIGHTING DAN
ELEKTRIKAL
LANTAI 9

Skala


1:500

Keterangan

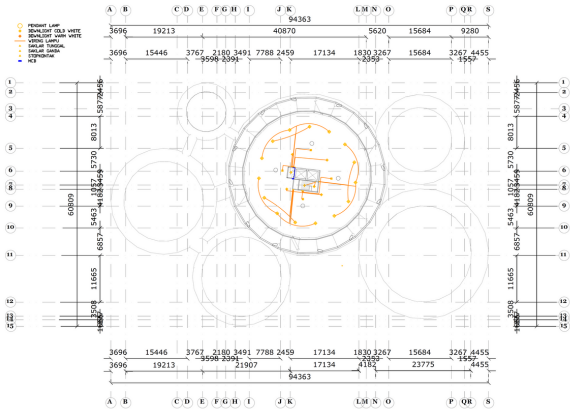


Lantai 10
SKALA 1:500

Nama/NIM
Gabrielle Phoebe 0206031910014
Judul Gambar
LIGHTING DAN ELEKTRIKAL LANTAI 10
Skala
1:500
Keterangan

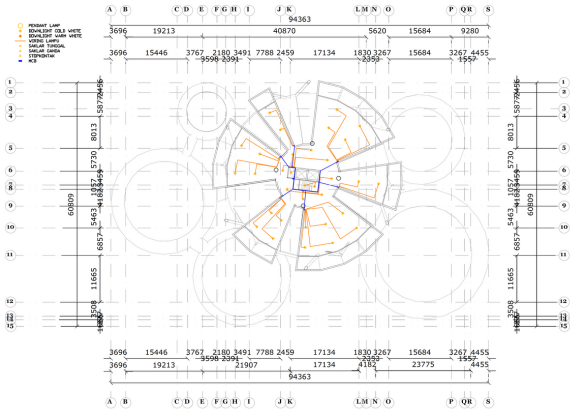

Nama/NIM
Gabrielle Phoebe 0206031910014
Judul Gambar
LIGHTING DAN ELEKTRIKAL LANTAI 11
Skala
1:500
Keterangan

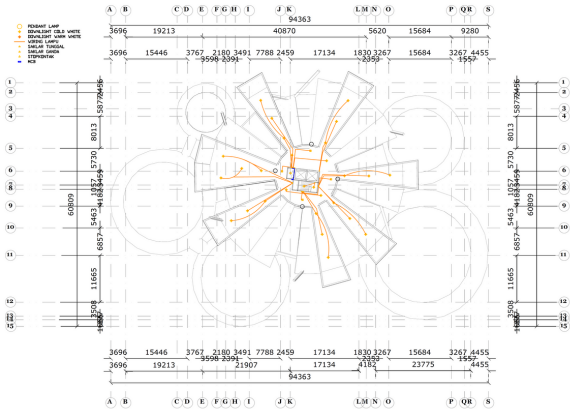

Nama/NIM

Gabrielle Phoebe
0206031910014


Judul Gambar

LIGHTING DAN
ELEKTRIKAL
LANTAI 12

Skala


1:500

Keterangan

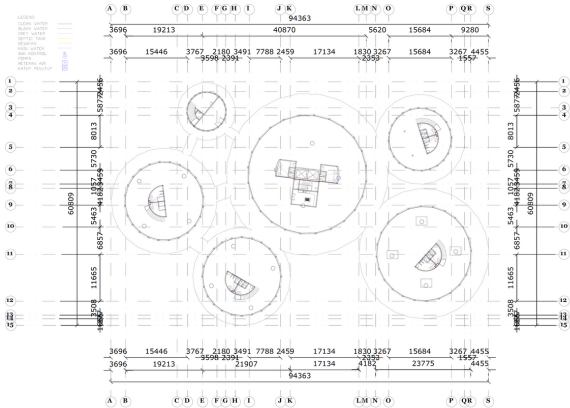


 Lantai 2
 SKALA 1:500

Nama/NIM
Gabrielle Phoebe 0206031910014
Judul Gambar
PLUMBING LANTAI 2
Skala
1:500
Keterangan

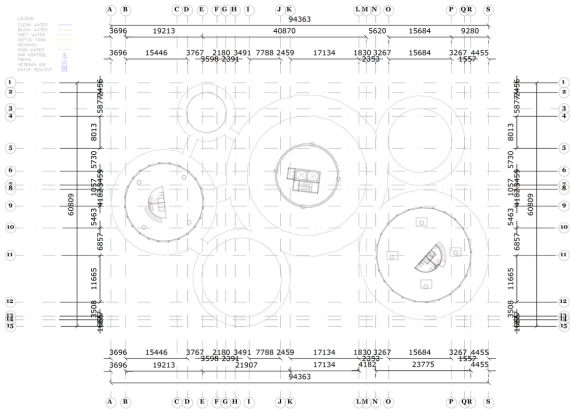

Nama/NIM

Gabrielle Phoebe
0206031910014

Judul Gambar


PLUMBING LANTAI 3

Skala

1:500

Keterangan

LEGENDA
 CLEAR WATER
 BLACK WATER
 GREY WATER
 SEPTIC TANK
 RESERWA
 RAIN WATER
 BAK KONTROL
 POMPA
 NETERMINASI
 KATUP PENCUP

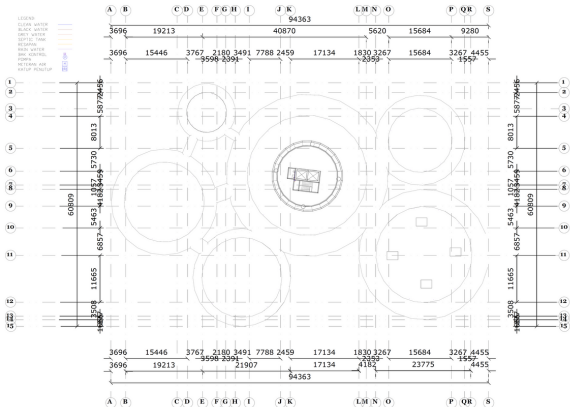

Nama/NIM

Gabrielle Phoebe
 0206031910014


Judul Gambar

PLUMBING LANTAI 6

Skala

1:500

Keterangan

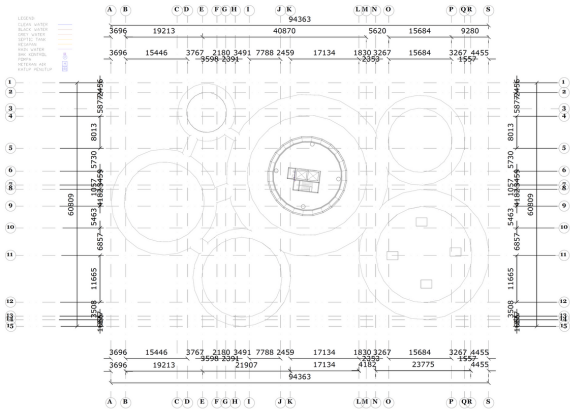

Nama/NIM

Gabrielle Phoebe
0206031910014


Judul Gambar

PLUMBING LANTAI 7

Skala

1:500

Keterangan

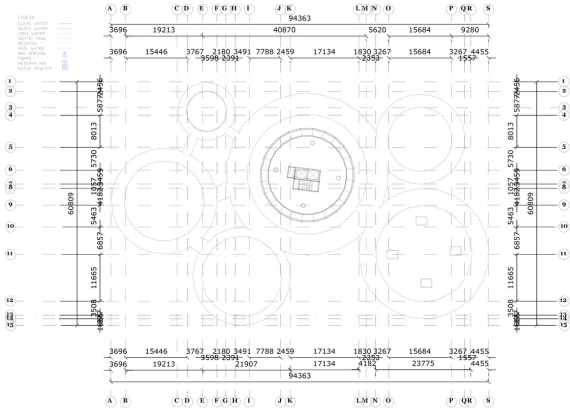

Nama/NIM

Gabrielle Phoebe
0206031910014

Judul Gambar


PLUMBING LANTAI 8

Skala

1:500

Keterangan

LEGENDA:
 CUCI MATA
 BAKUL MATA
 DUKI MATA
 SEPTIC TANK
 HESALAM
 PASI MATA
 DUKI KEMBAL
 POMPA
 NETERMINAL AIR
 KATUP HENTAI

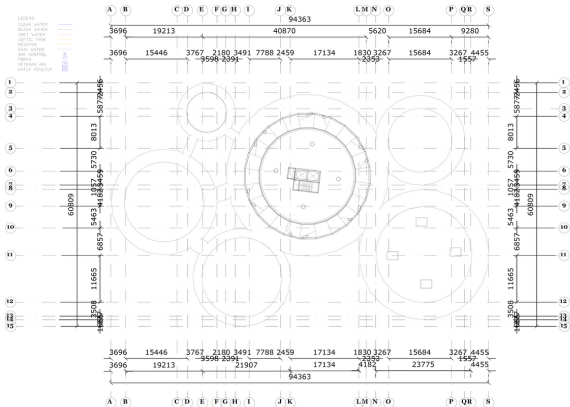

Nama/NIM

Gabrielle Phoebe
 0206031910014


Judul Gambar

PLUMBING LANTAI 9


Skala

1:500

Keterangan

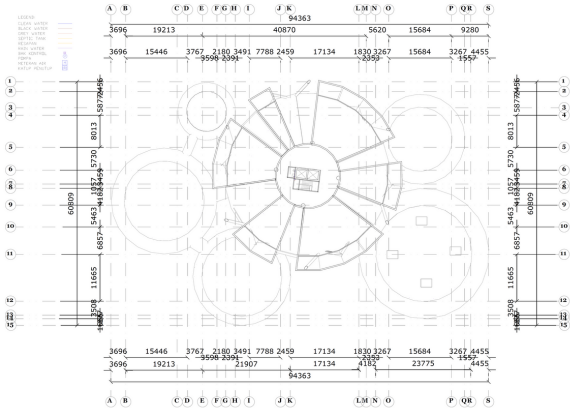


Nama/NIM
Gabrielle Phoebe 0206031910014
Judul Gambar
PLUMBING LANTAI 11
Skala
1:500
Keterangan

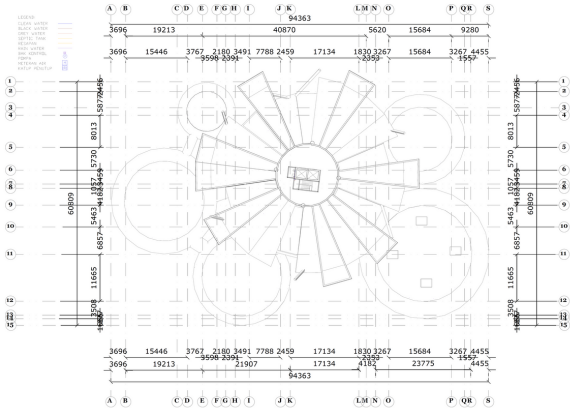

Nama/NIM
Gabrielle Phoebe 0206031910014
Judul Gambar
PLUMBING LANTAI 12
Skala
1:500
Keterangan

Lantai 12
SKALA 1:500

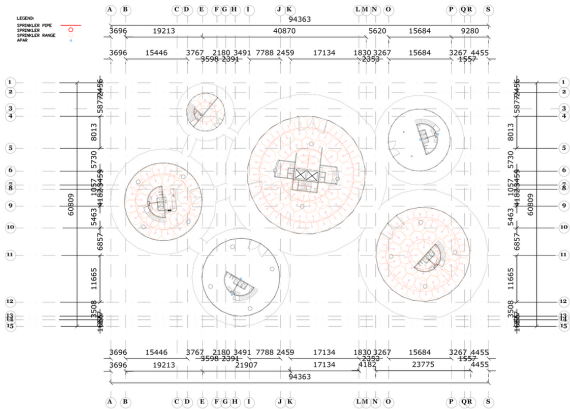

Nama/NIM

Gabrielle Phoebe
0206031910014


Judul Gambar

PROTEKSI
KEBAKARAN
LANTAI 1

Skala

1:500

Keterangan

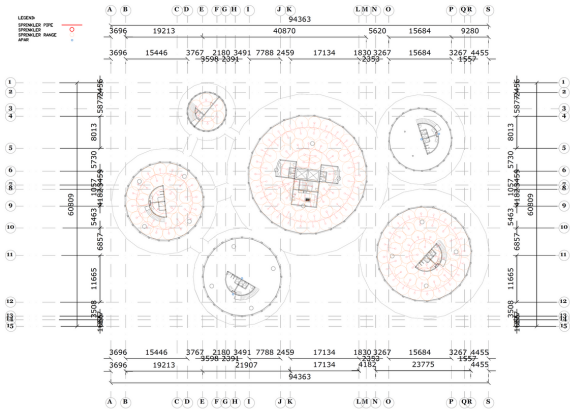

Nama/NIM

Gabrielle Phoebe
0206031910014


Judul Gambar

PROTEKSI
KEBAKARAN
LANTAI 2

Skala

1:500

Keterangan

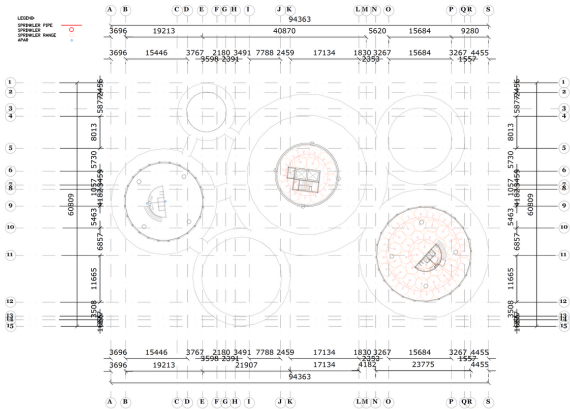

Nama/NIM

Gabrielle Phoebe
0206031910014


Judul Gambar

PROTEKSI
KEBAKARAN
LANTAI 3


Skala

1:500

Keterangan

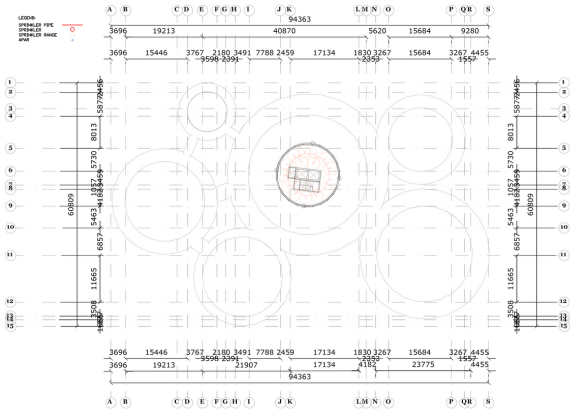

Nama/NIM
Gabrielle Phoebe 0206031910014
Judul Gambar
PROTEKSI KEBAKARAN LANTAI 5
Skala
1:500
Keterangan

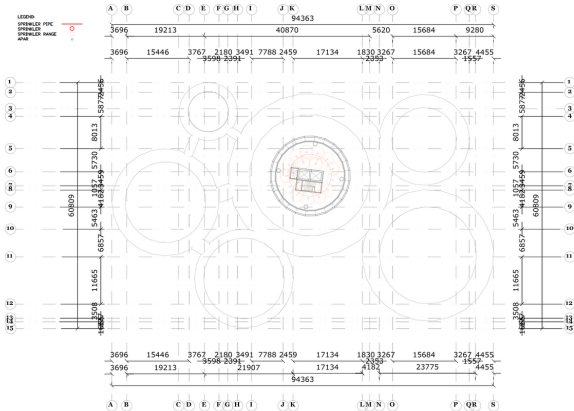

Nama/NIM

Gabrielle Phoebe
0206031910014

Judul Gambar


PROTEKSI
KEBAKARAN
LANTAI 7

Skala

1:500


Keterangan

LEGGER
 SPRINKLER PIPE
 SPRINKLER
 SPRINKLER RISER
 VALVE

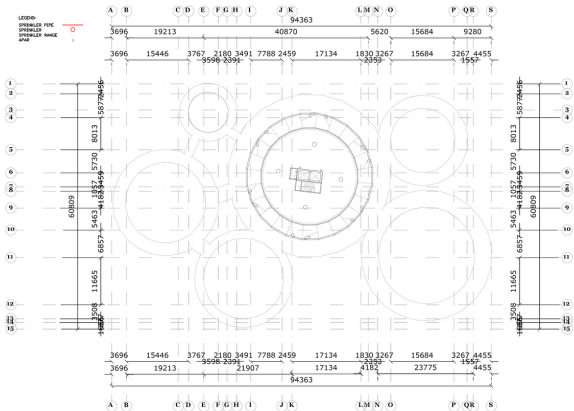

Lantai 9
 SKALA 1:500

Nama/NIM
Gabrielle Phoebe 0206031910014
Judul Gambar
PROTEKSI KEBAKARAN LANTAI 9
Skala
1:500
Keterangan

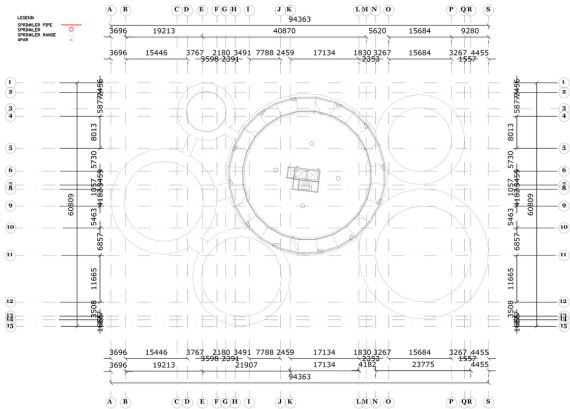

Nama/NIM

Gabrielle Phoebé
0206031910014


Judul Gambar

PROTEKSI
KEBAKARAN
LANTAI 10

Skala

1:500

Keterangan

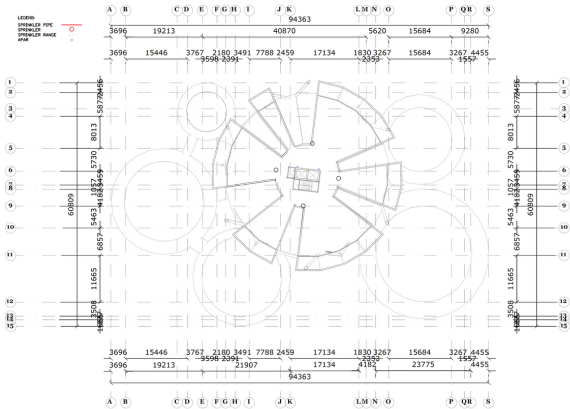

Nama/NIM

Gabrielle Phoebe
0206031910014


Judul Gambar

PROTEKSI
KEBAKARAN
LANTAI 11

Skala

1:500

Keterangan

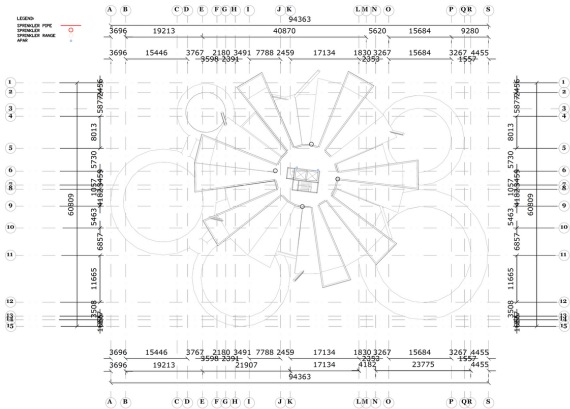

Nama/NIM

Gabrielle Phoebe
0206031910014

Judul Gambar

PROTEKSI
KEBAKARAN
LANTAI 12

Skala

1:500

Keterangan