 



 


SITE PLAN




SITE PLAN
skala 1:1500

	NAMA - NIM	MATA KULIAH	TUTOR	DOSEN
	JESSICA NATALIA 0206031910017	COMMERCIAL SPACE DESIGN	PAK FREDDY	PAK YUSUF





LAYOUT
skala 1:400


	NAMA - NIM	MATA KULIAH	TUTOR	DOSEN
	JESSICA NATALIA 0206031910017	COMMERCIAL SPACE DESIGN	PAK FREDDY	PAK YUSUF




 LAYOUTS

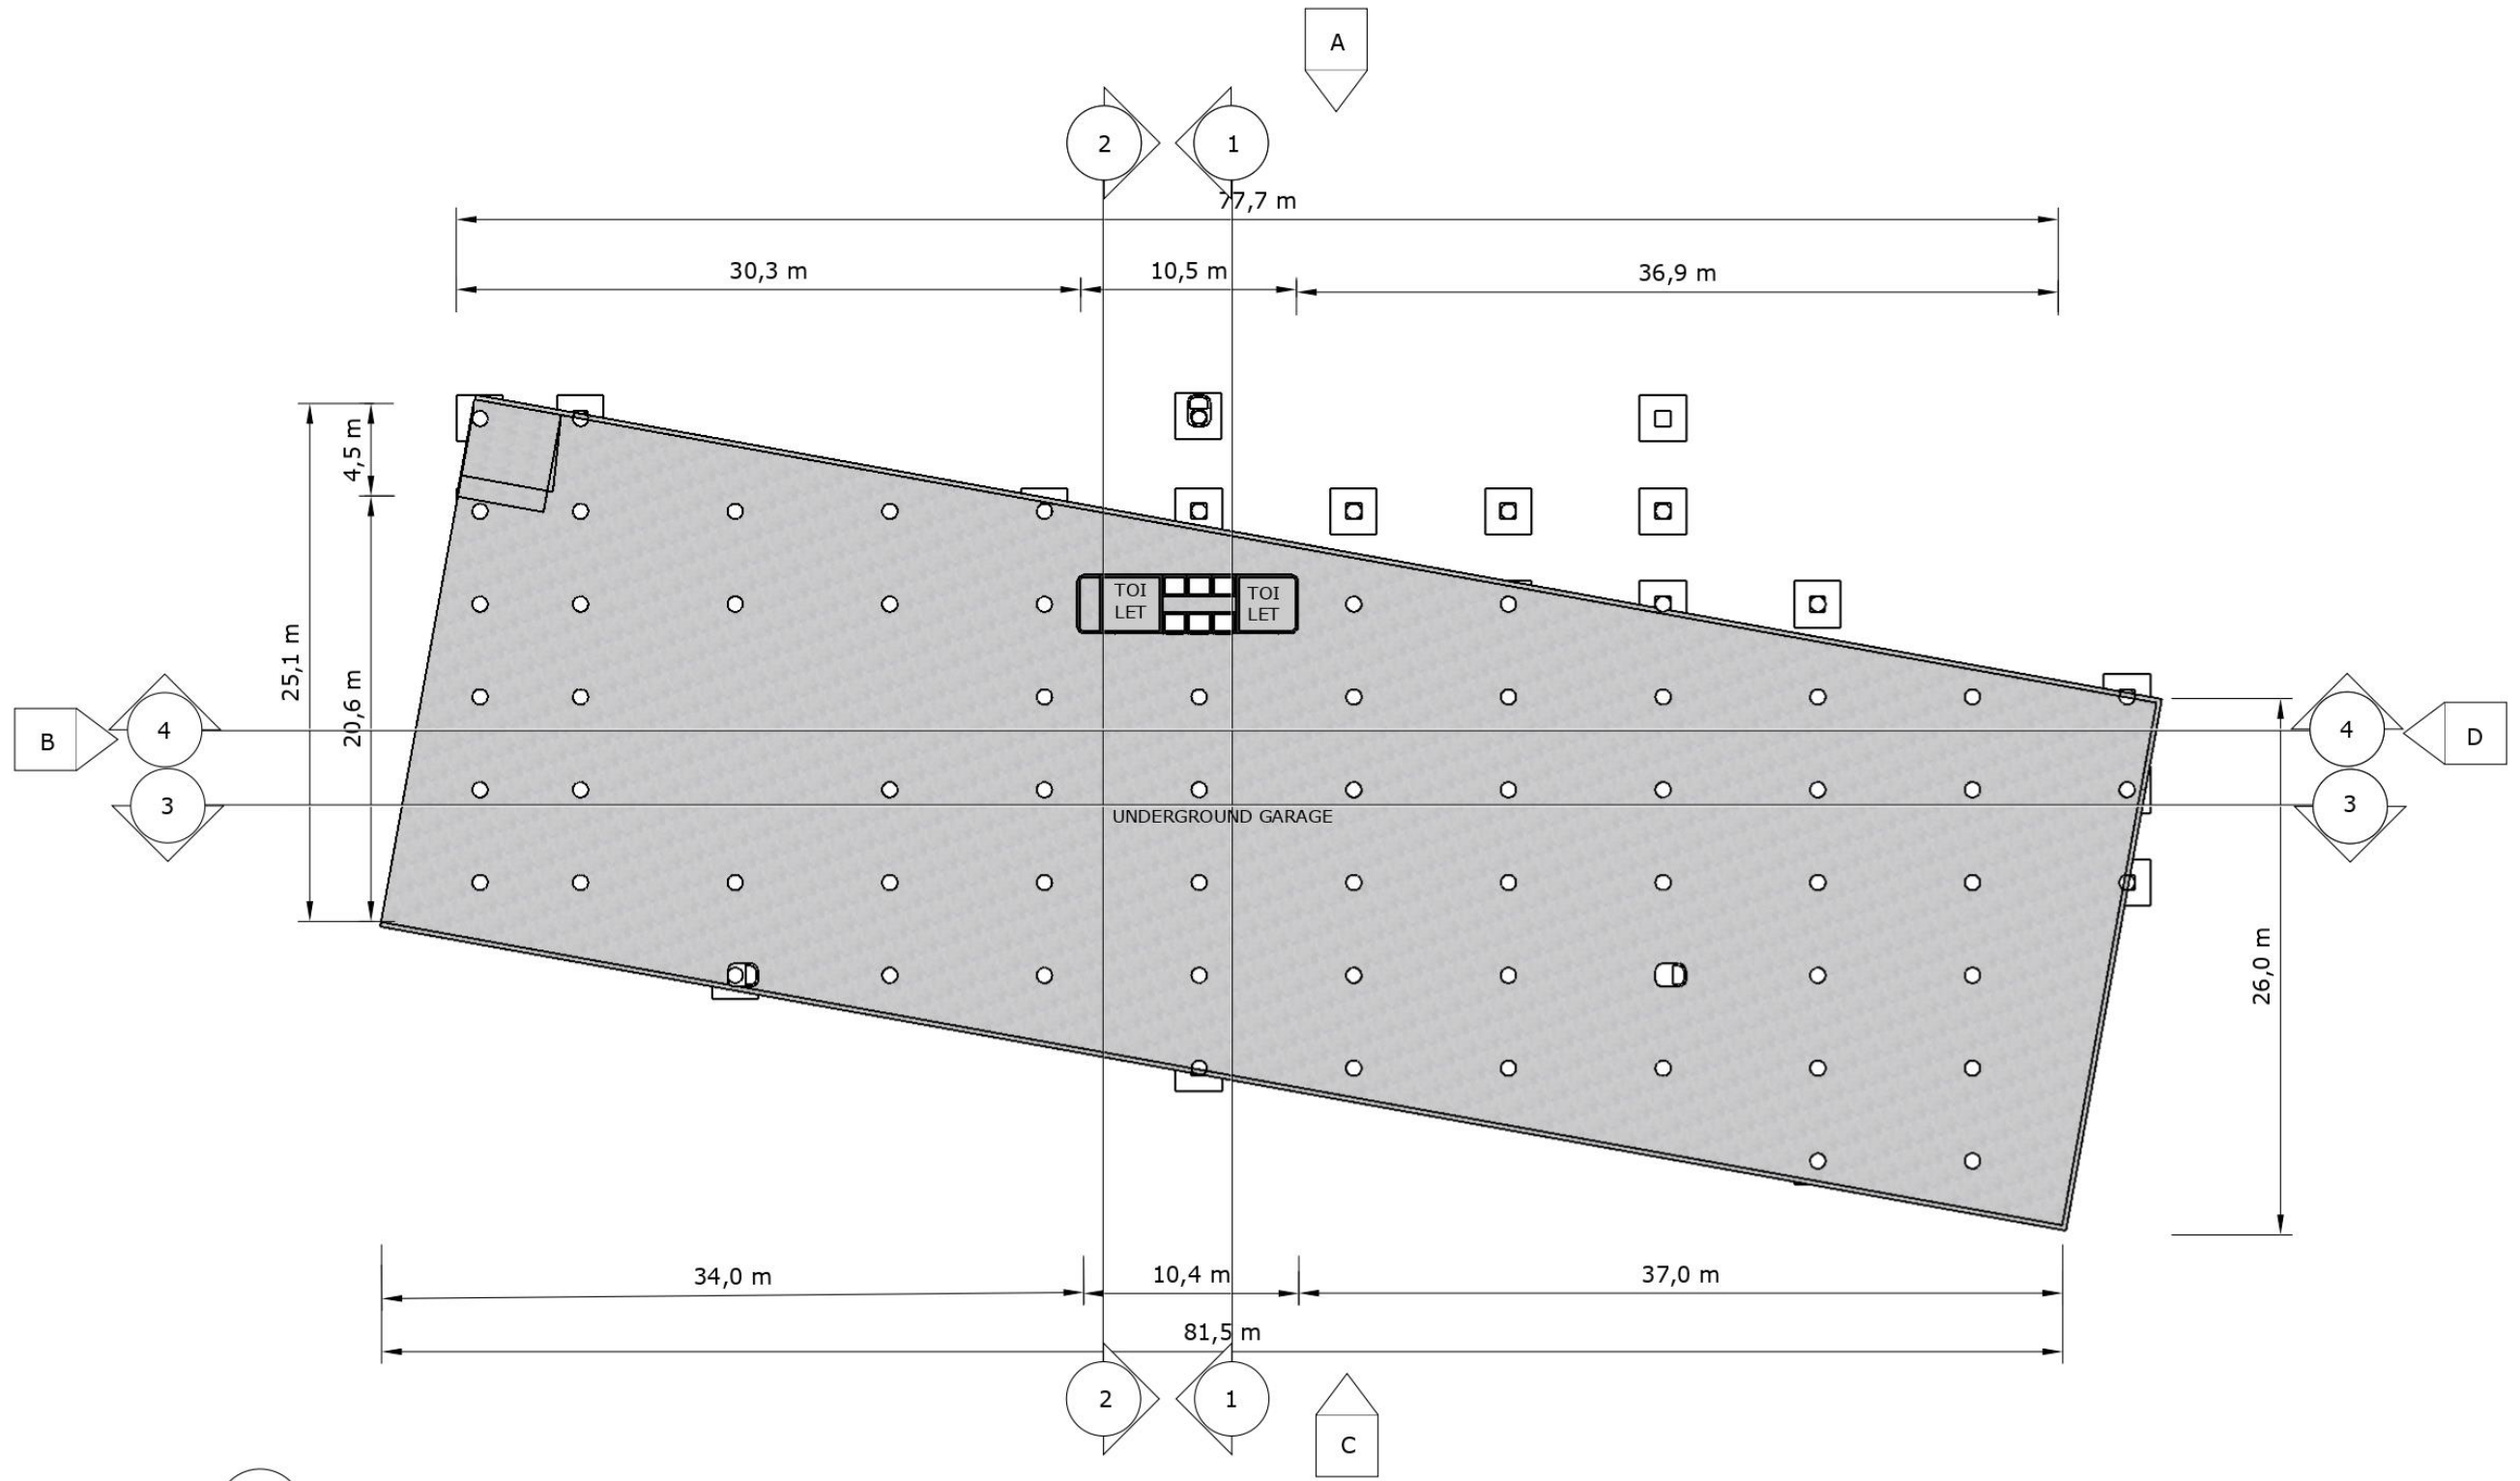


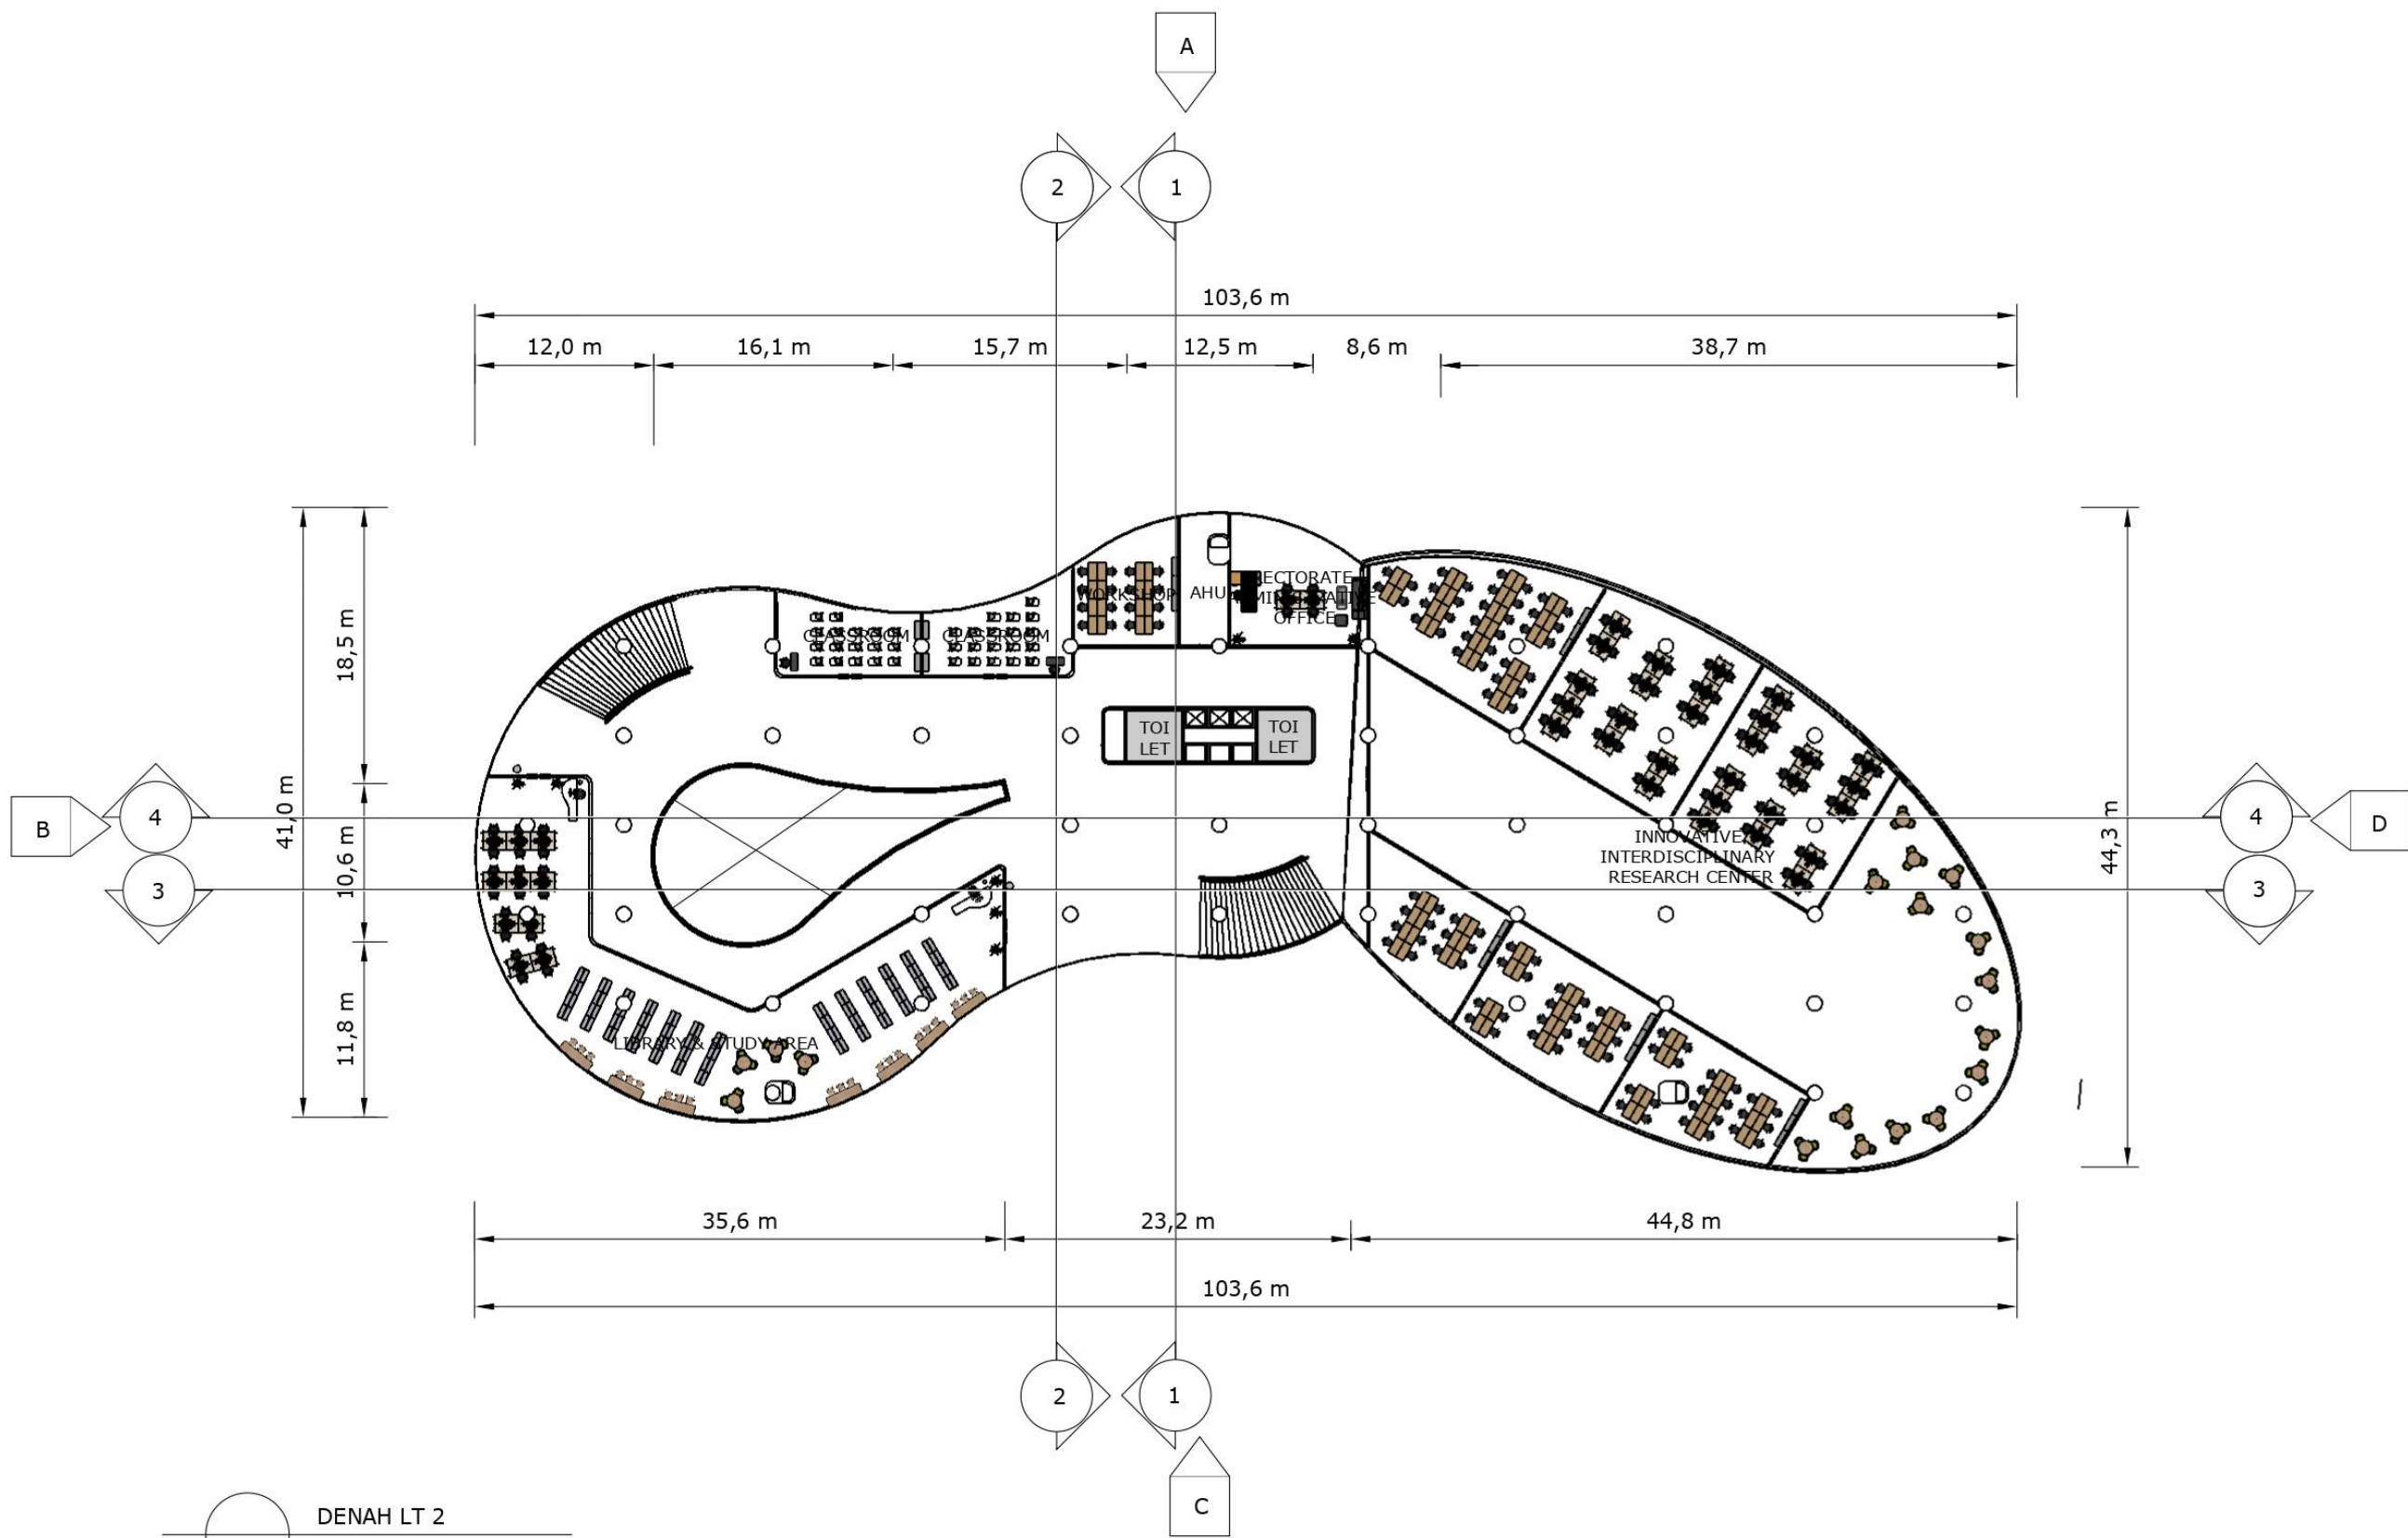

 DENAH BASEMENT
 skala 1:400


	NAMA - NIM	MATA KULIAH	TUTOR	DOSEN
	JESSICA NATALIA 0206031910017	COMMERCIAL SPACE DESIGN	PAK FREDDY	PAK YUSUF

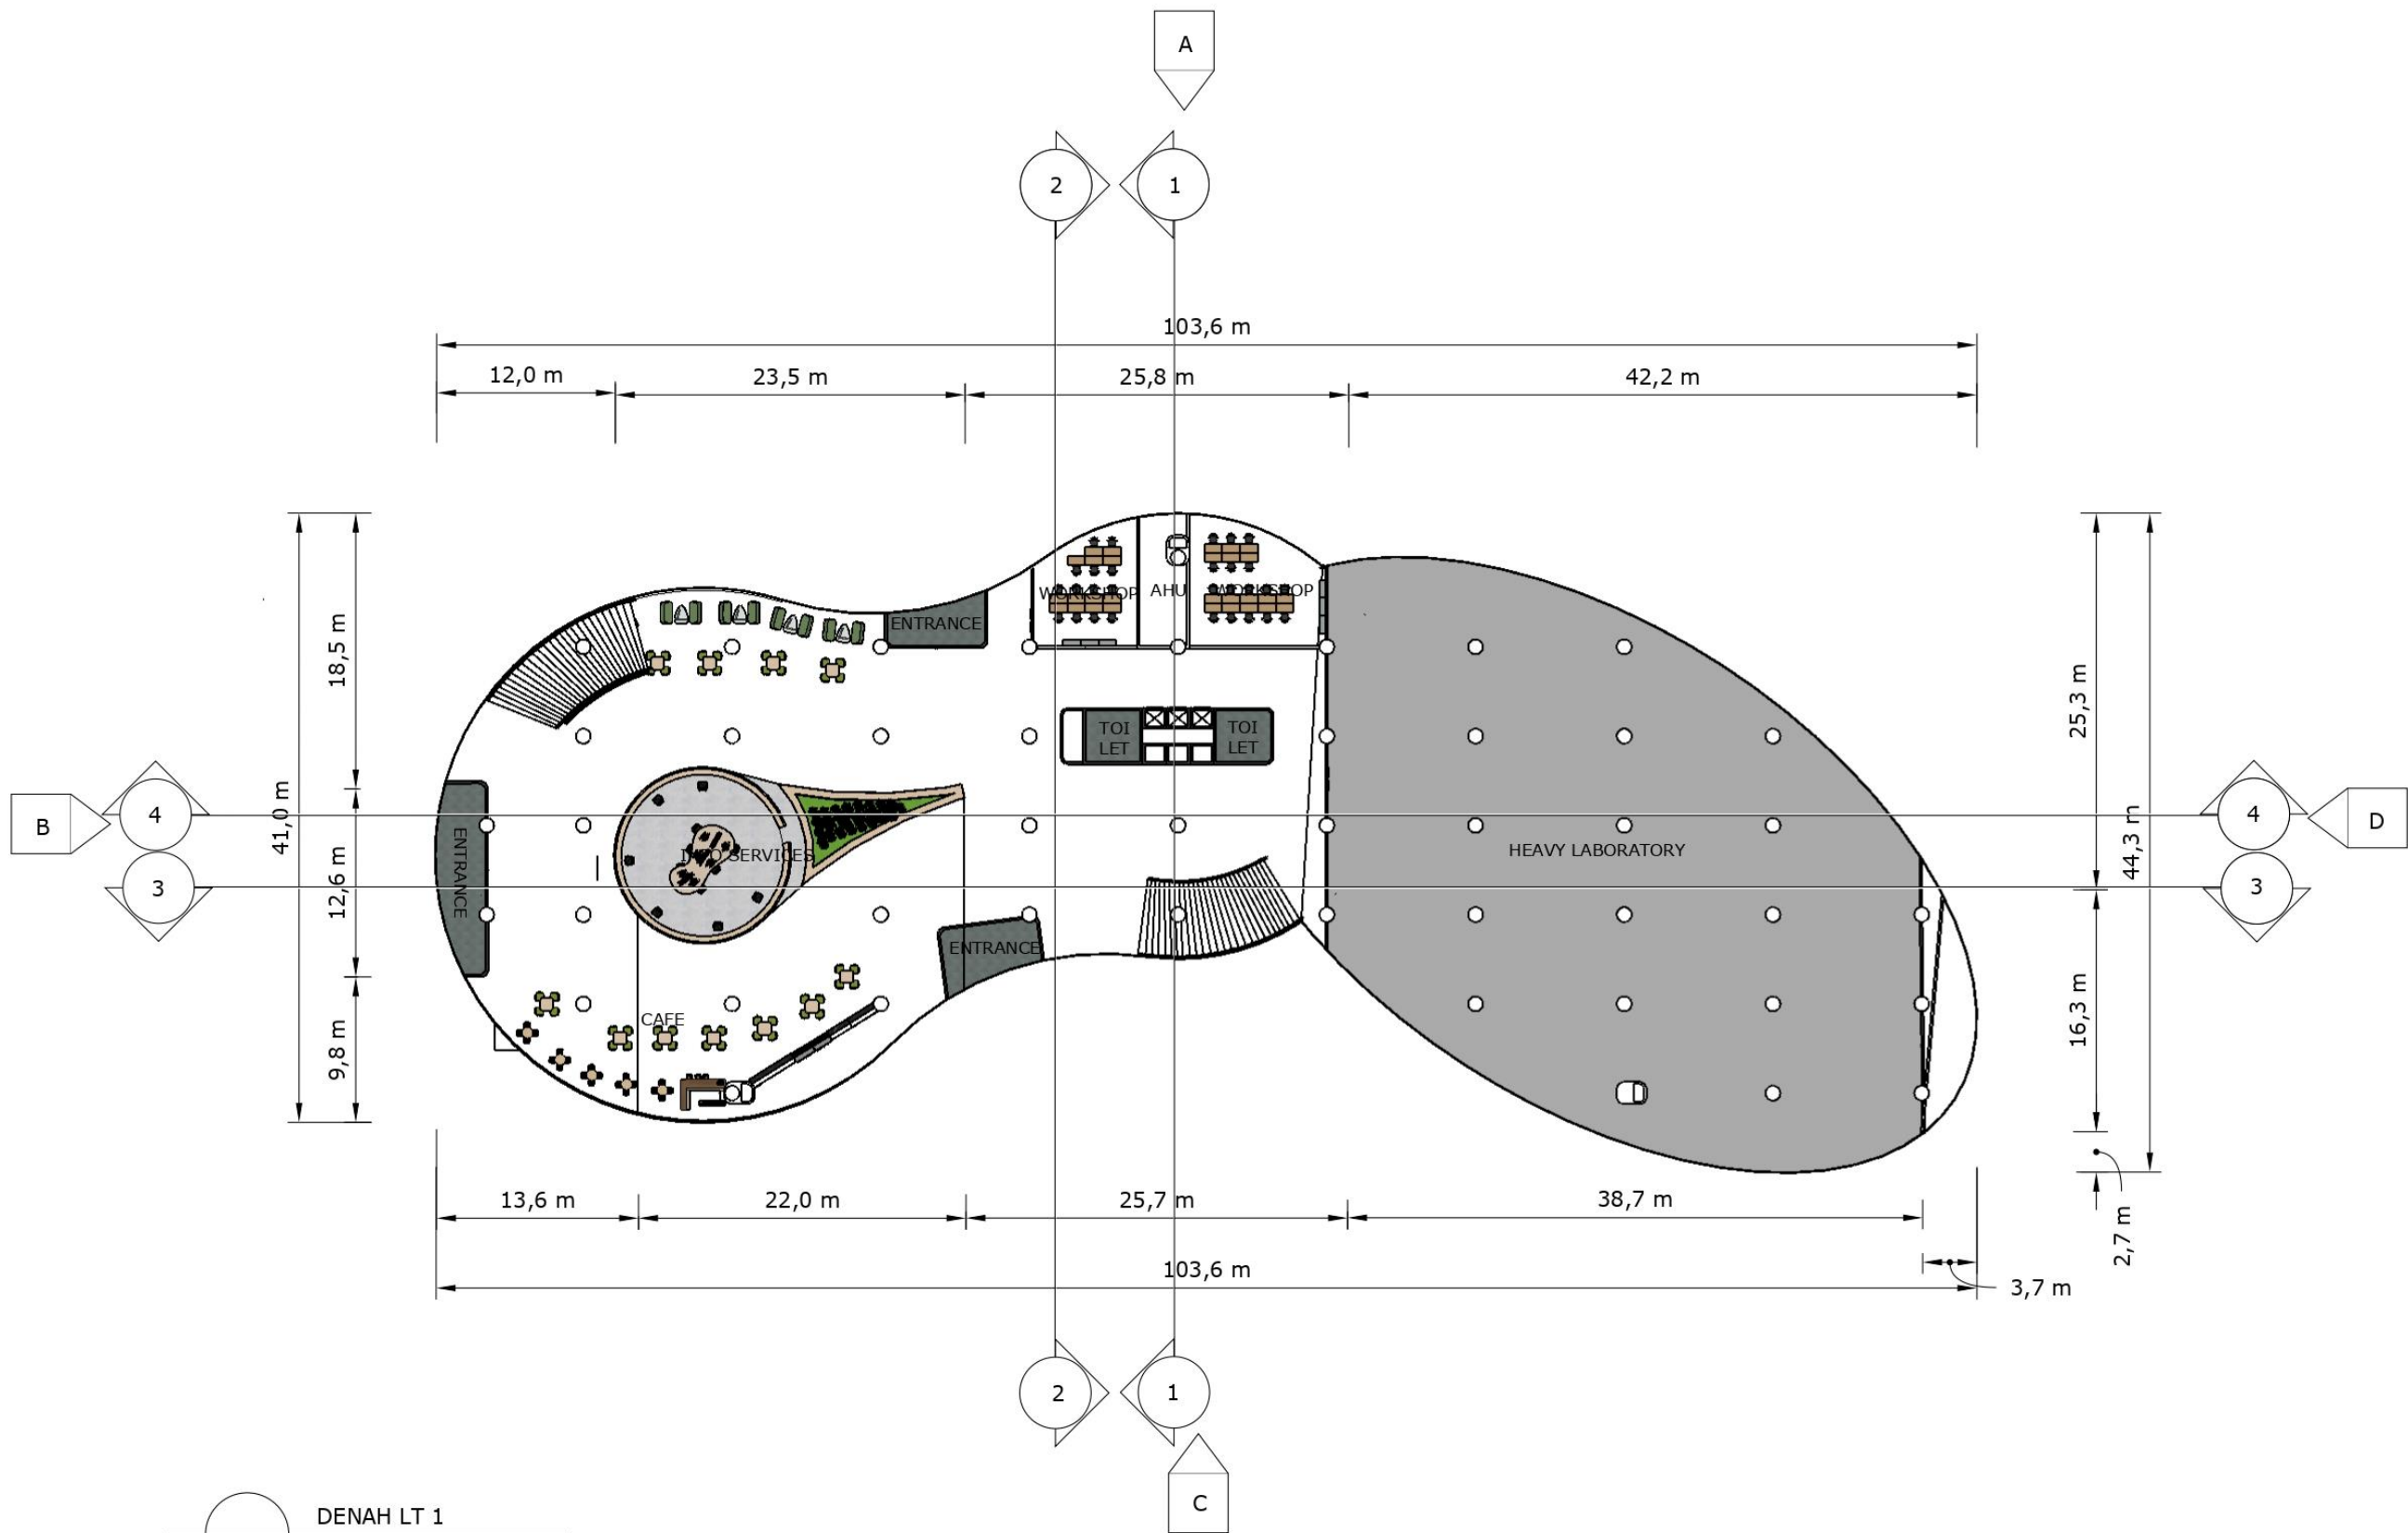

 
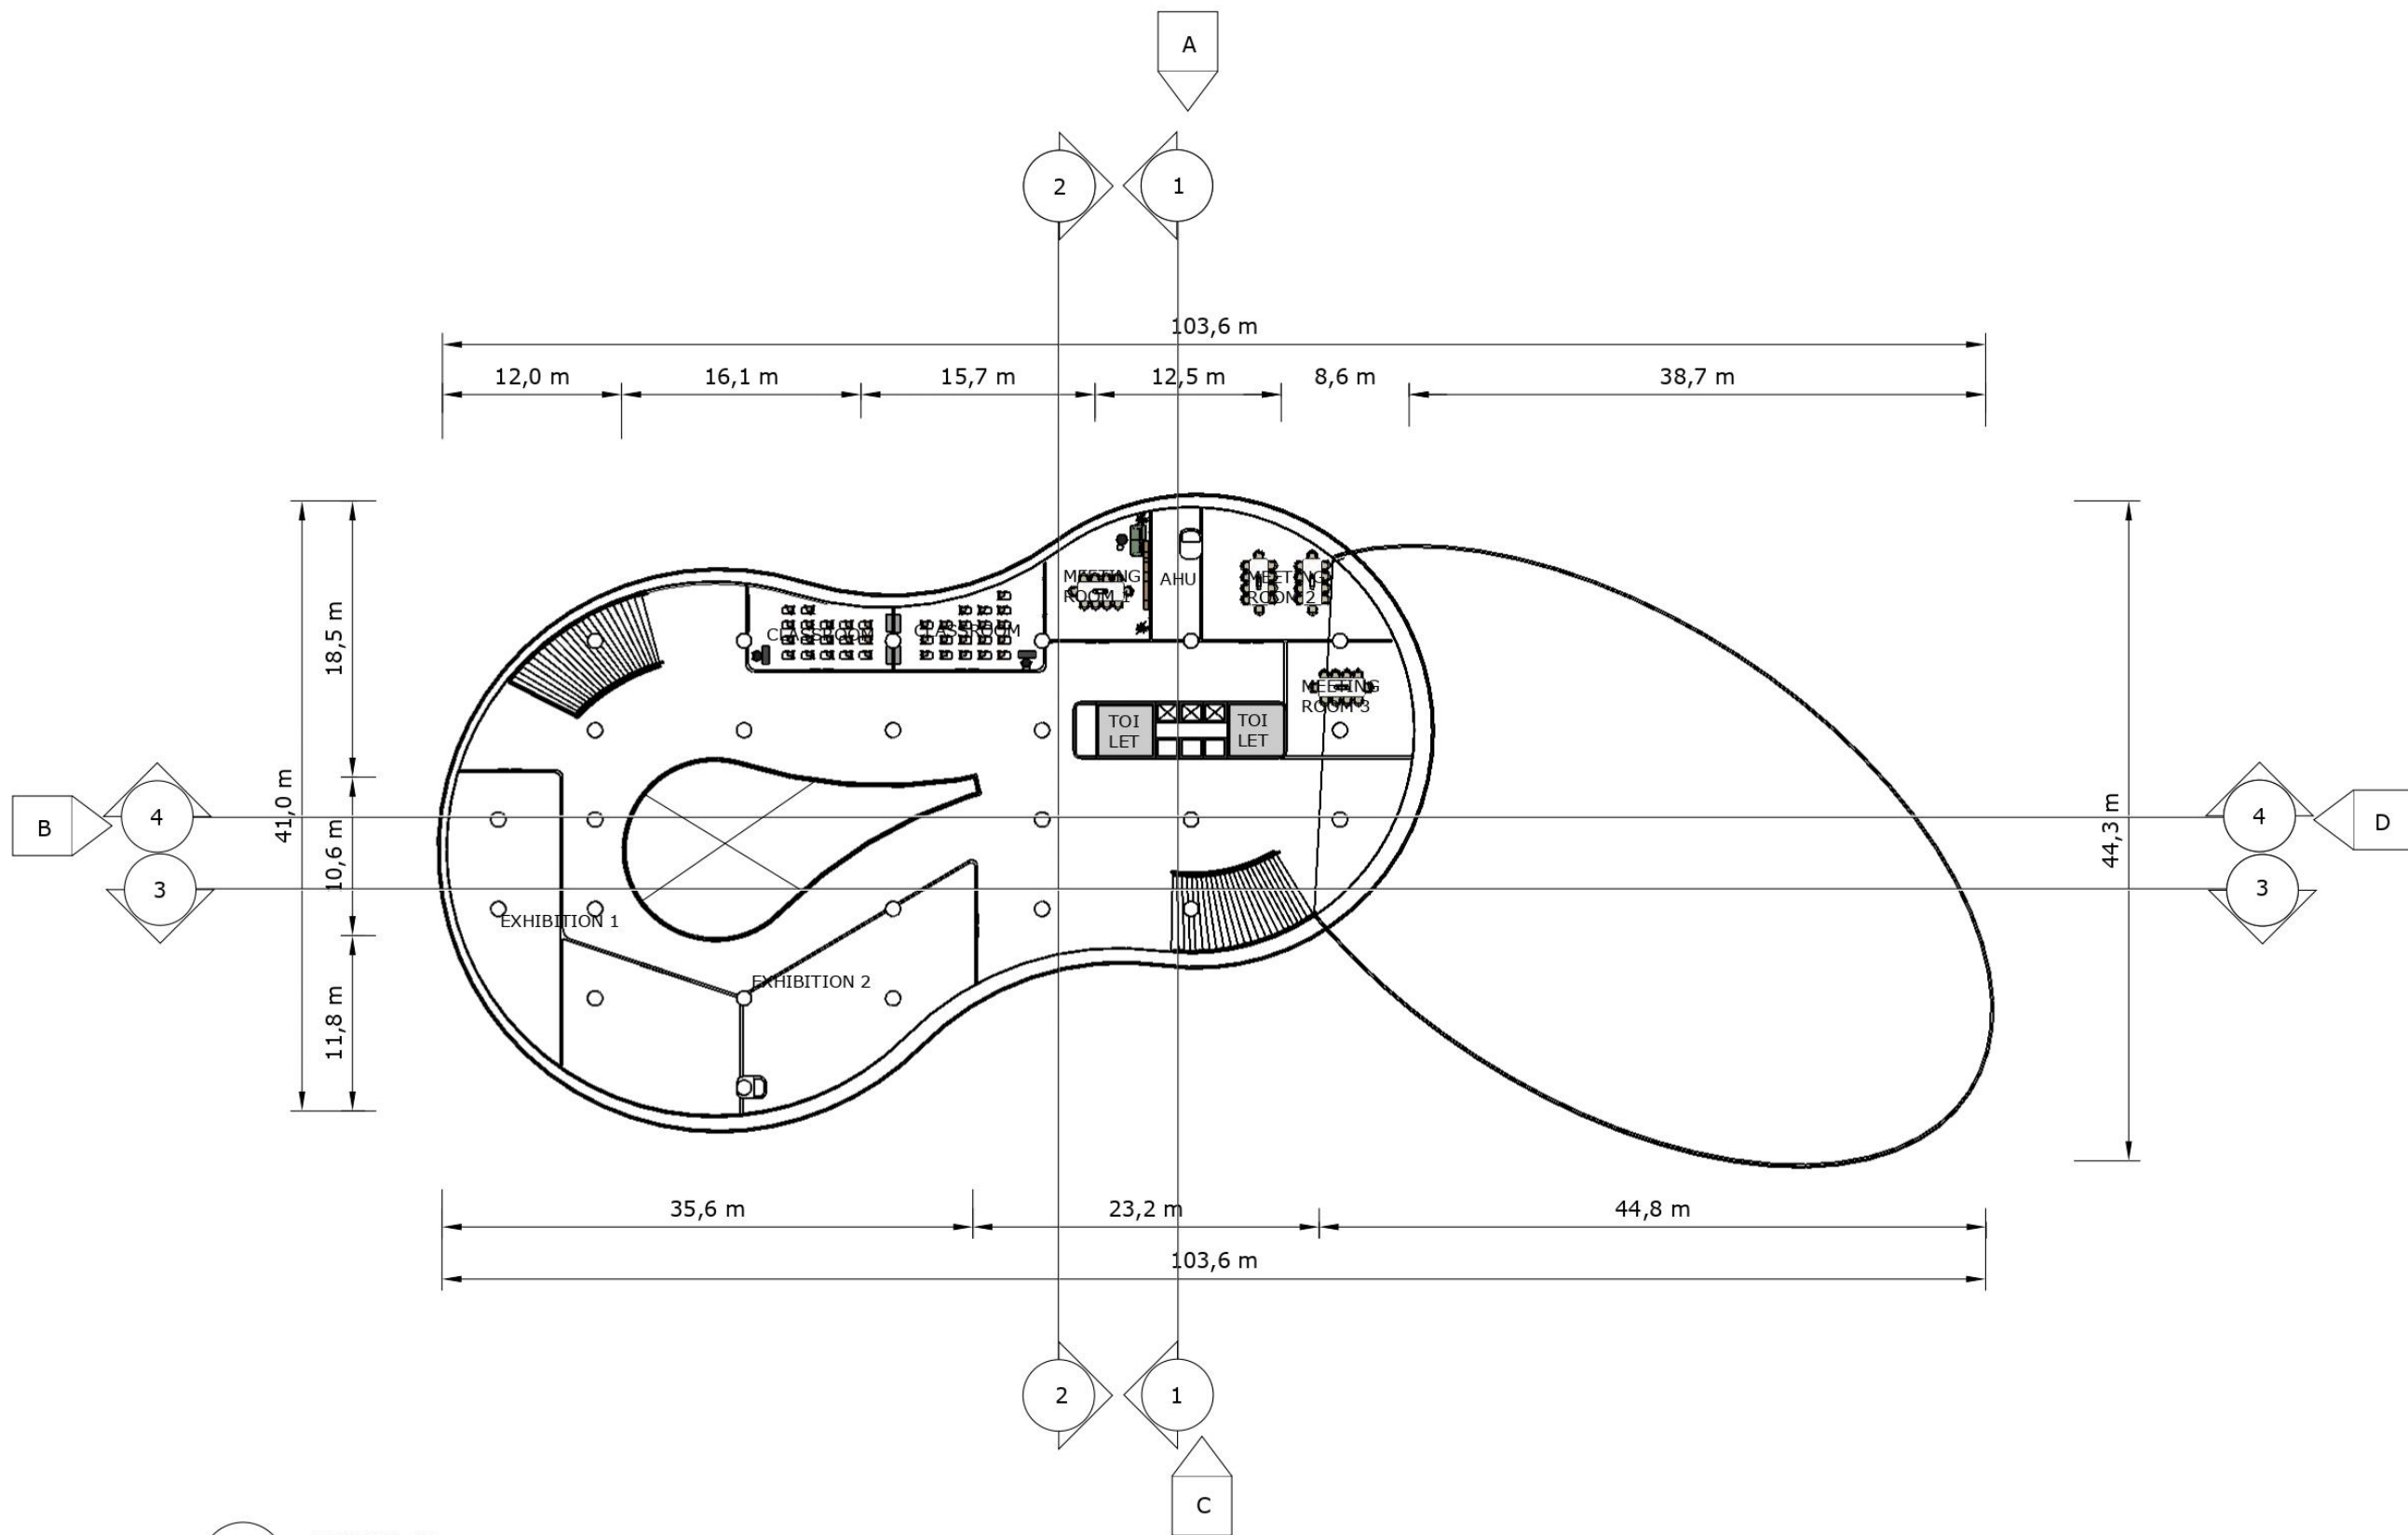
DENAH LT 1
skala 1:400


	NAMA - NIM	MATA KULIAH	TUTOR	DOSEN
	JESSICA NATALIA 0206031910017	COMMERCIAL SPACE DESIGN	PAK FREDDY	PAK YUSUF



 
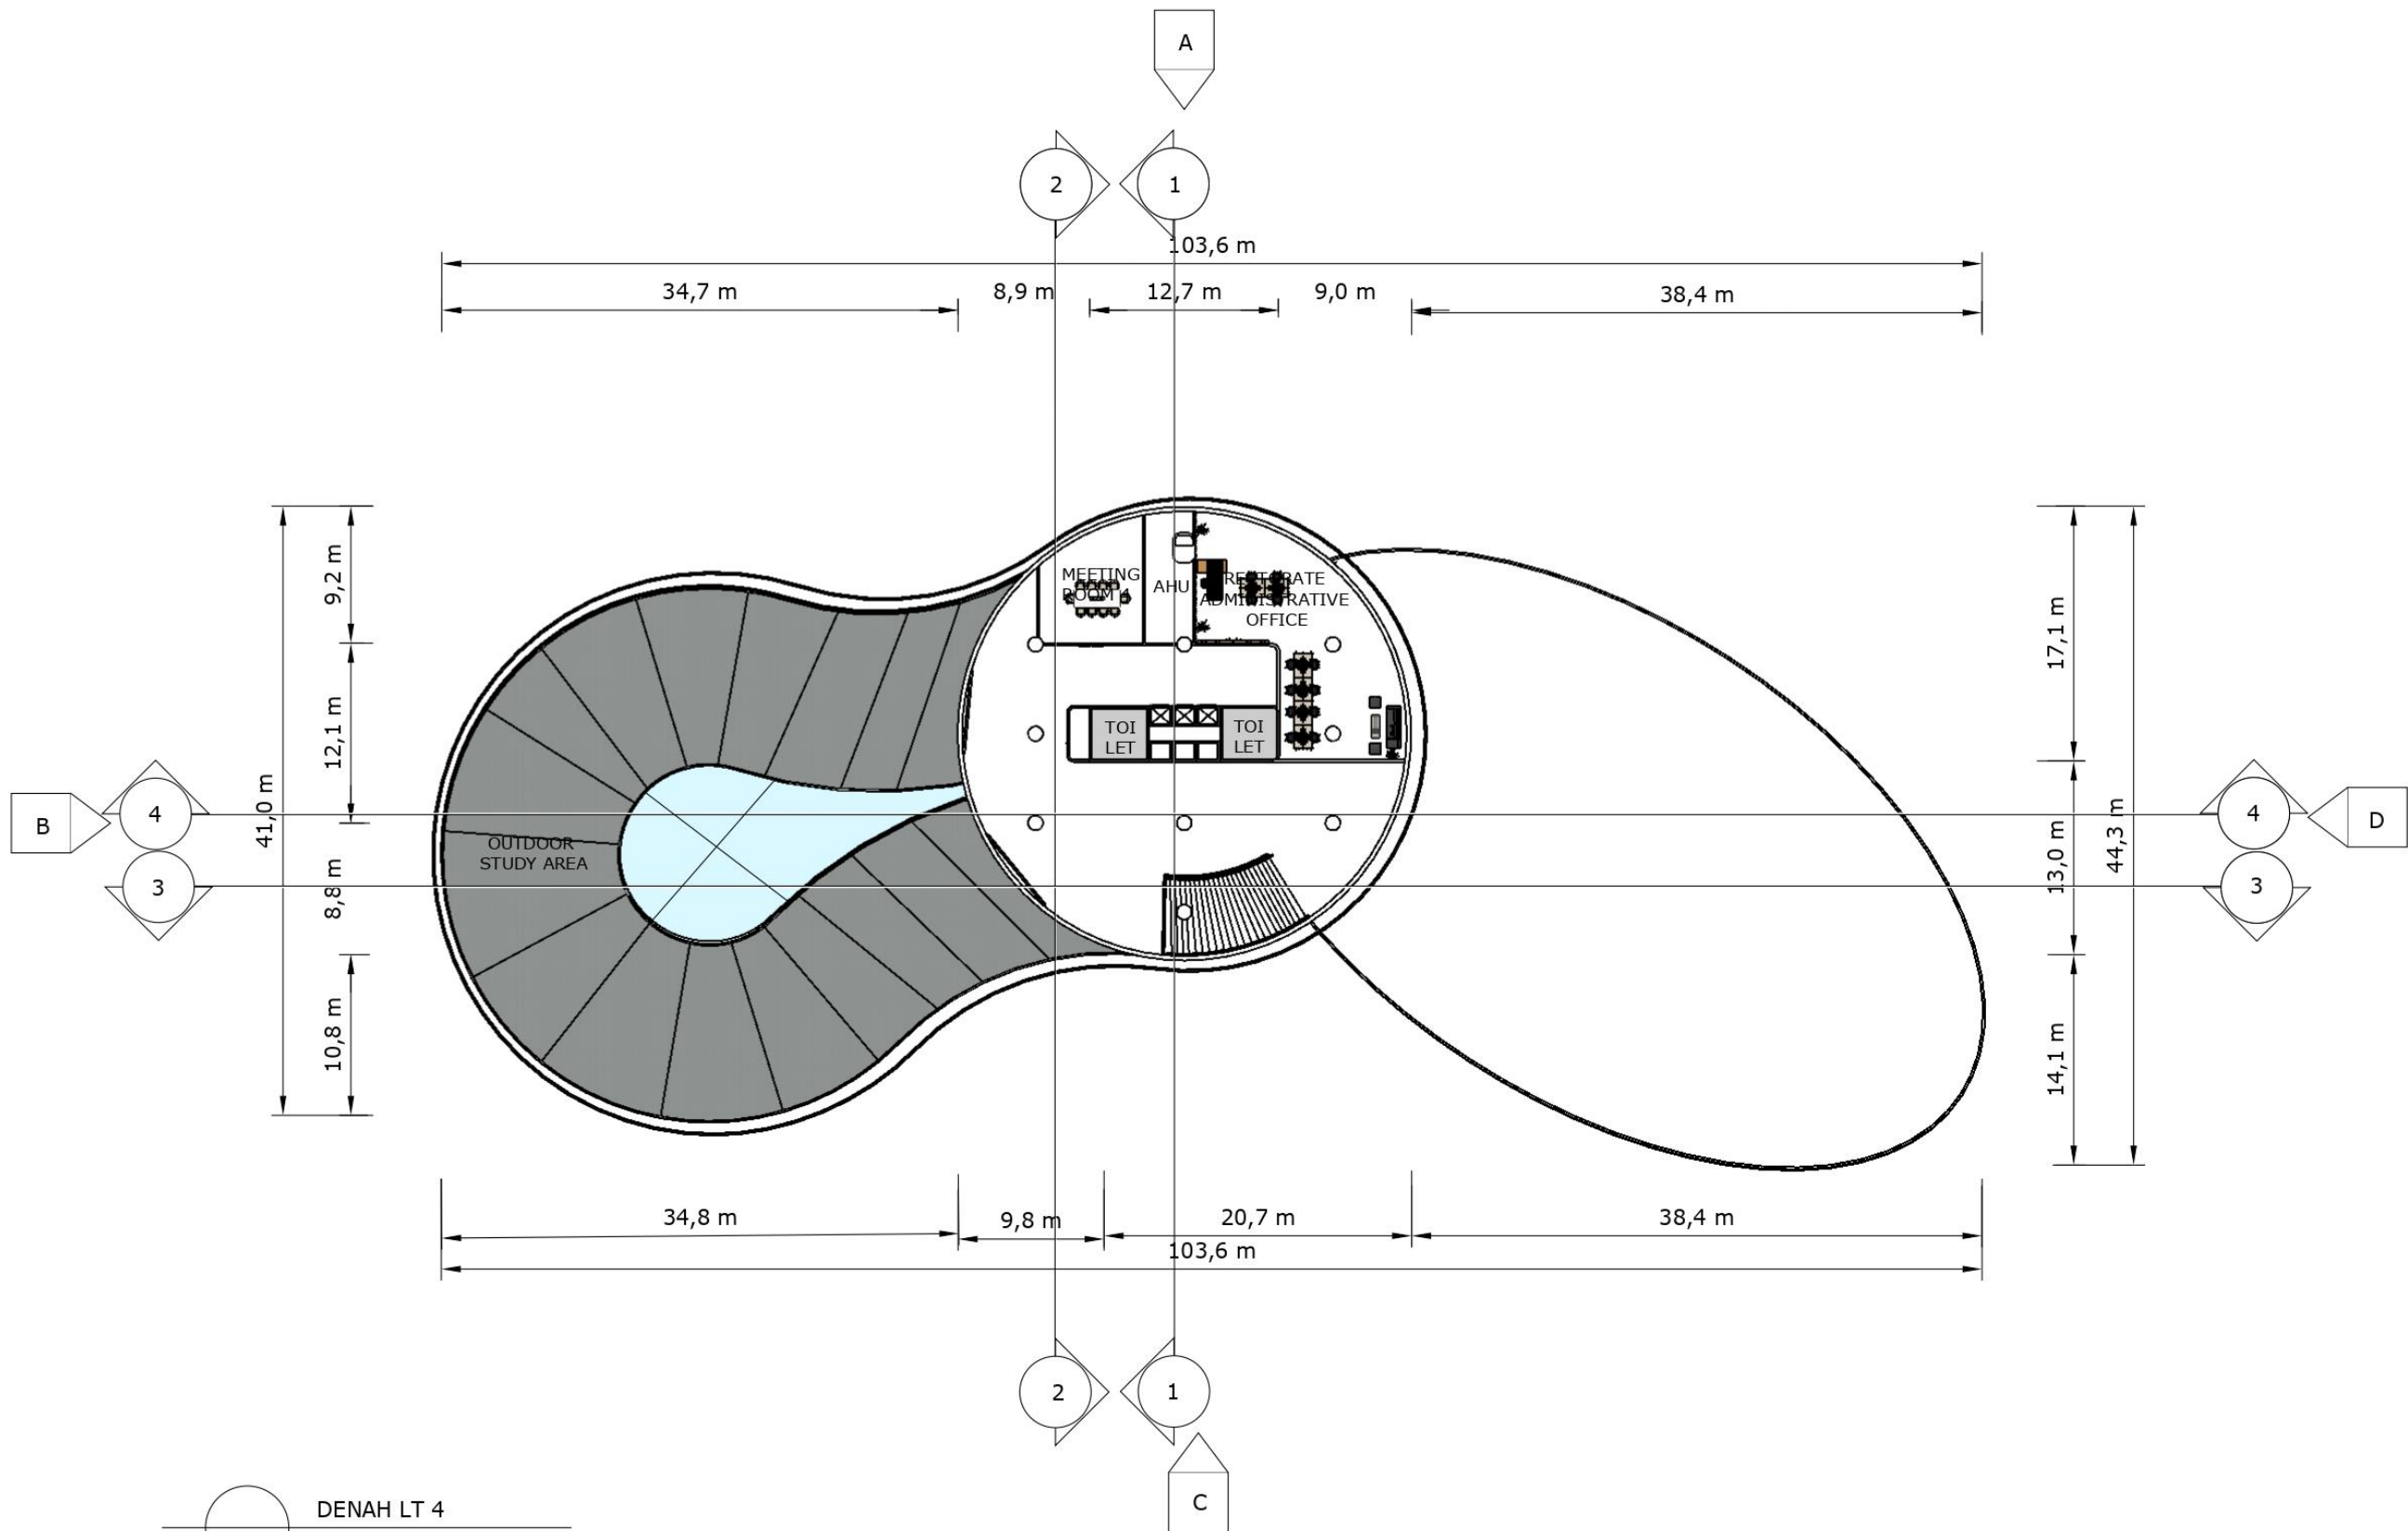

 DENAH LT 2
 skala 1:400


	NAMA - NIM	MATA KULIAH	TUTOR	DOSEN
	JESSICA NATALIA 0206031910017	COMMERCIAL SPACE DESIGN	PAK FREDDY	PAK YUSUF



 
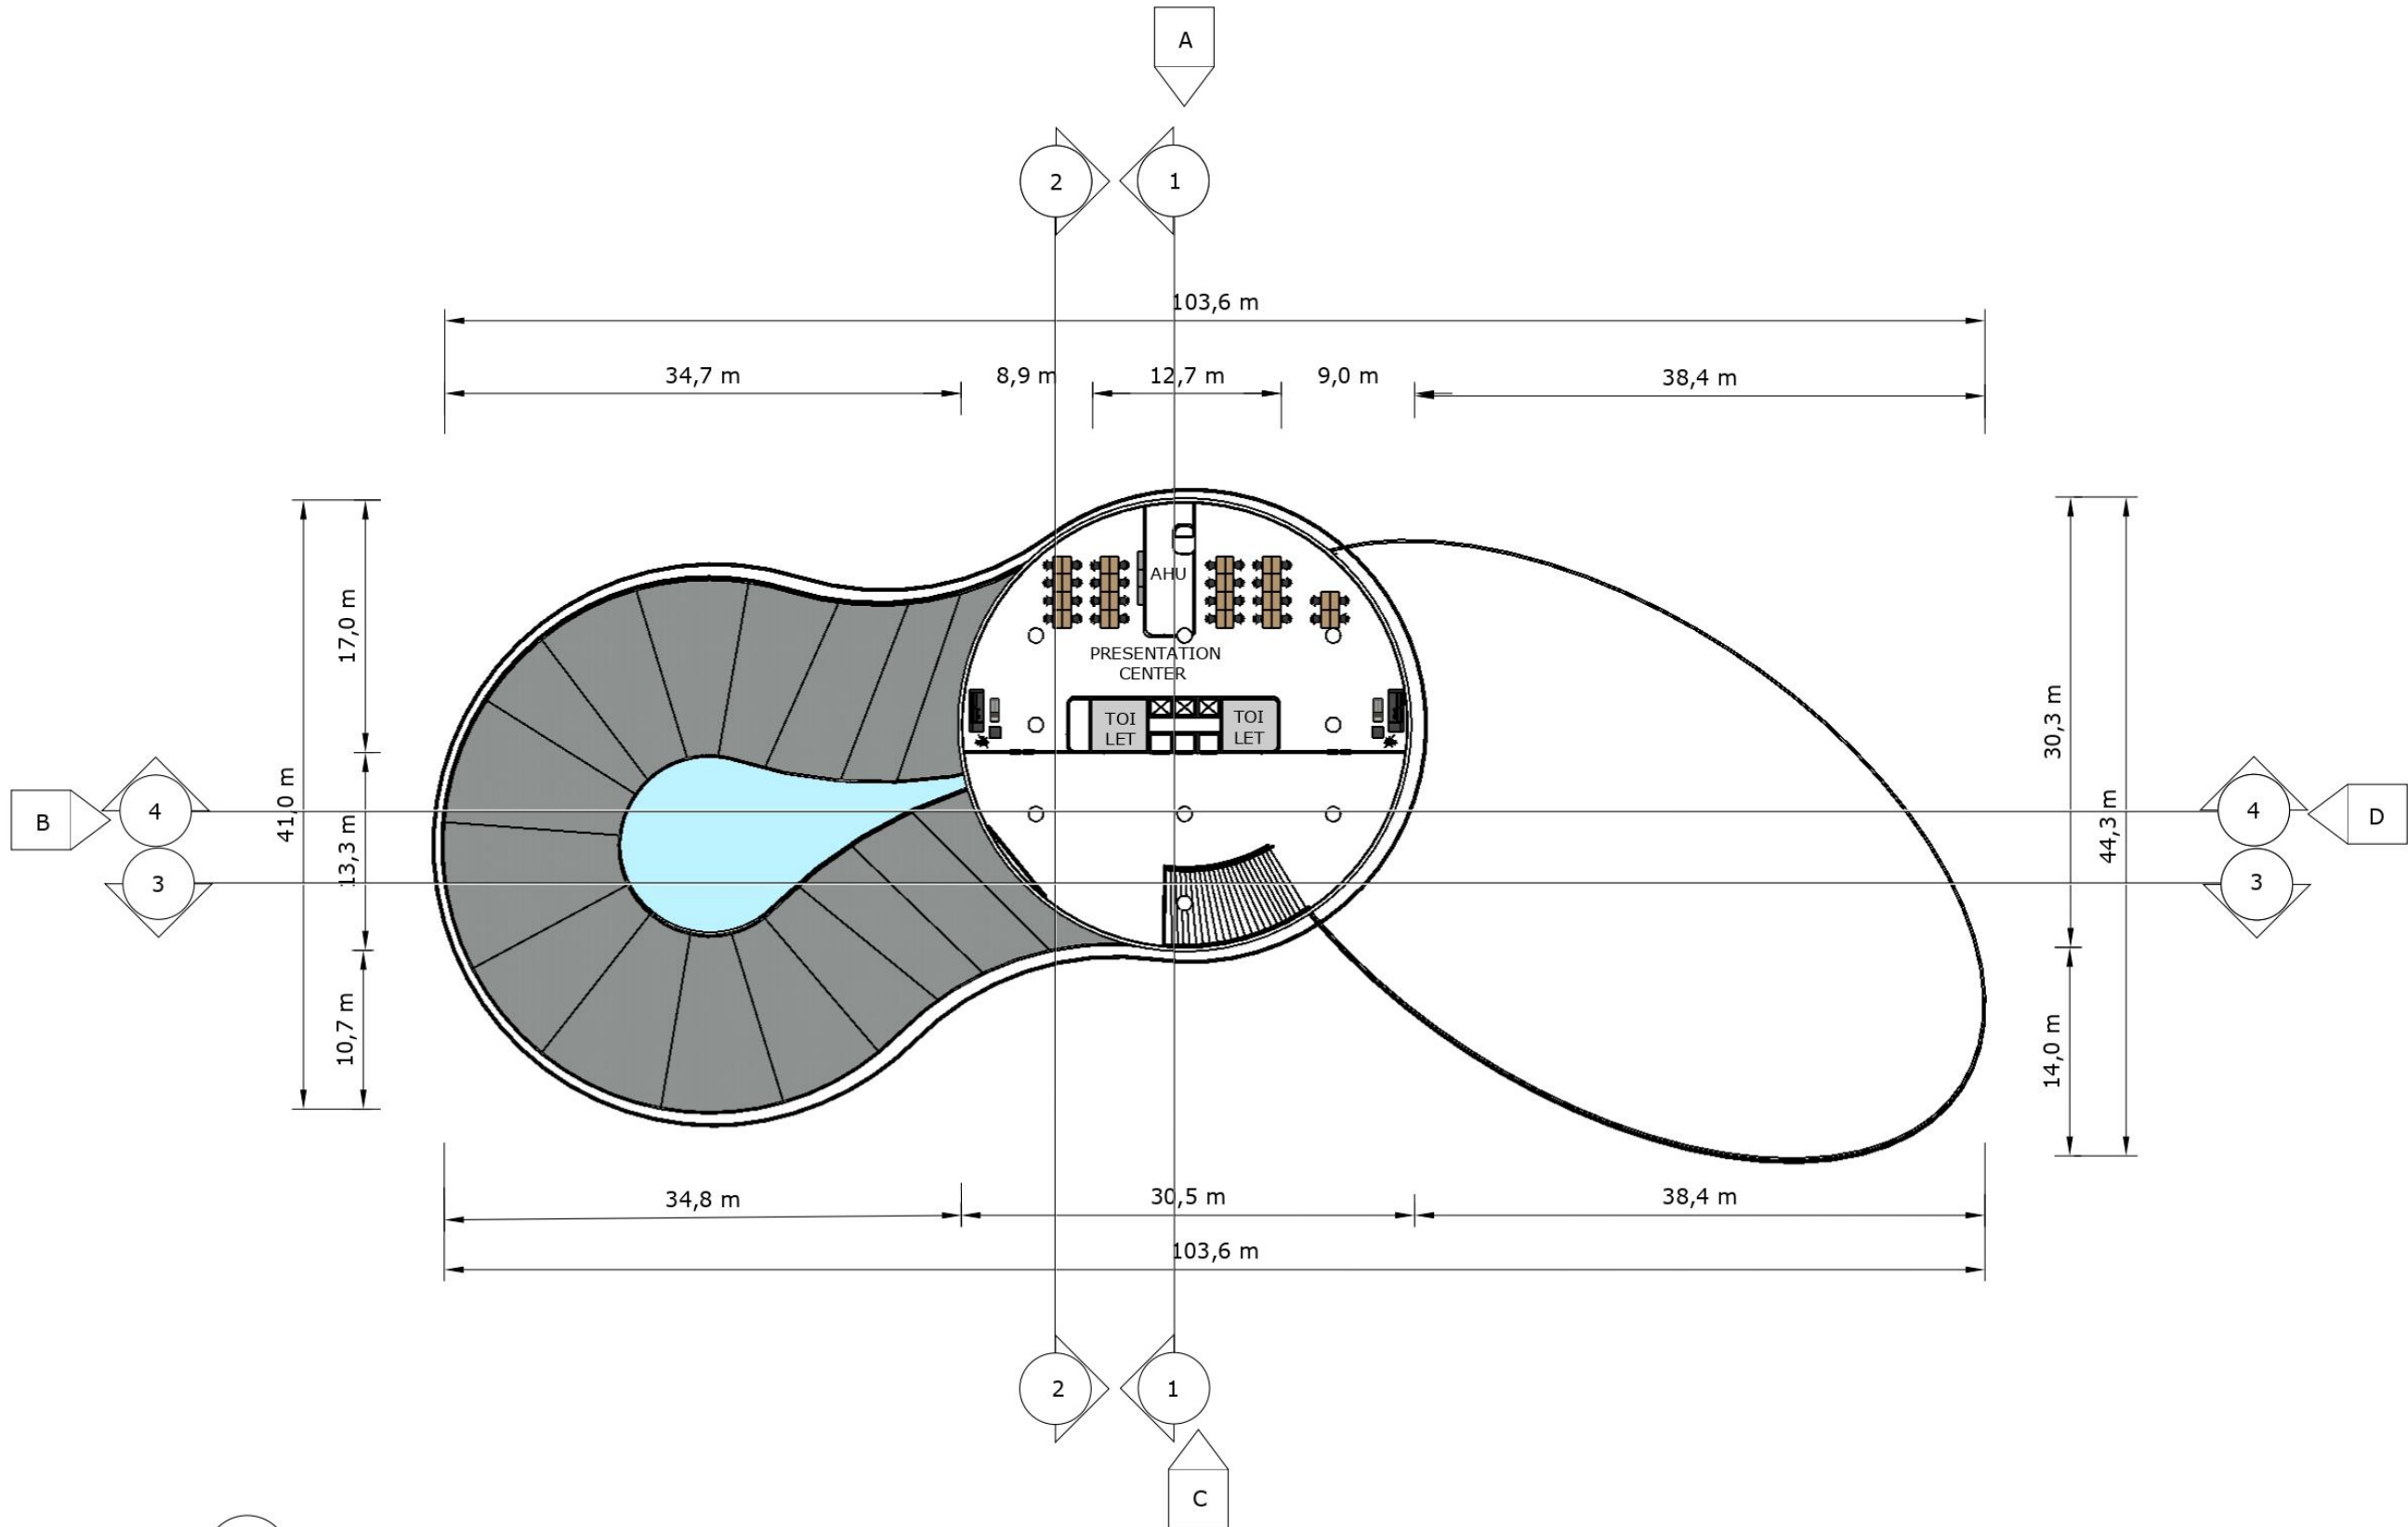

DENAH LT 3
 skala 1:400

	NAMA - NIM	MATA KULIAH	TUTOR	DOSEN
	JESSICA NATALIA 0206031910017	COMMERCIAL SPACE DESIGN	PAK FREDDY	PAK YUSUF




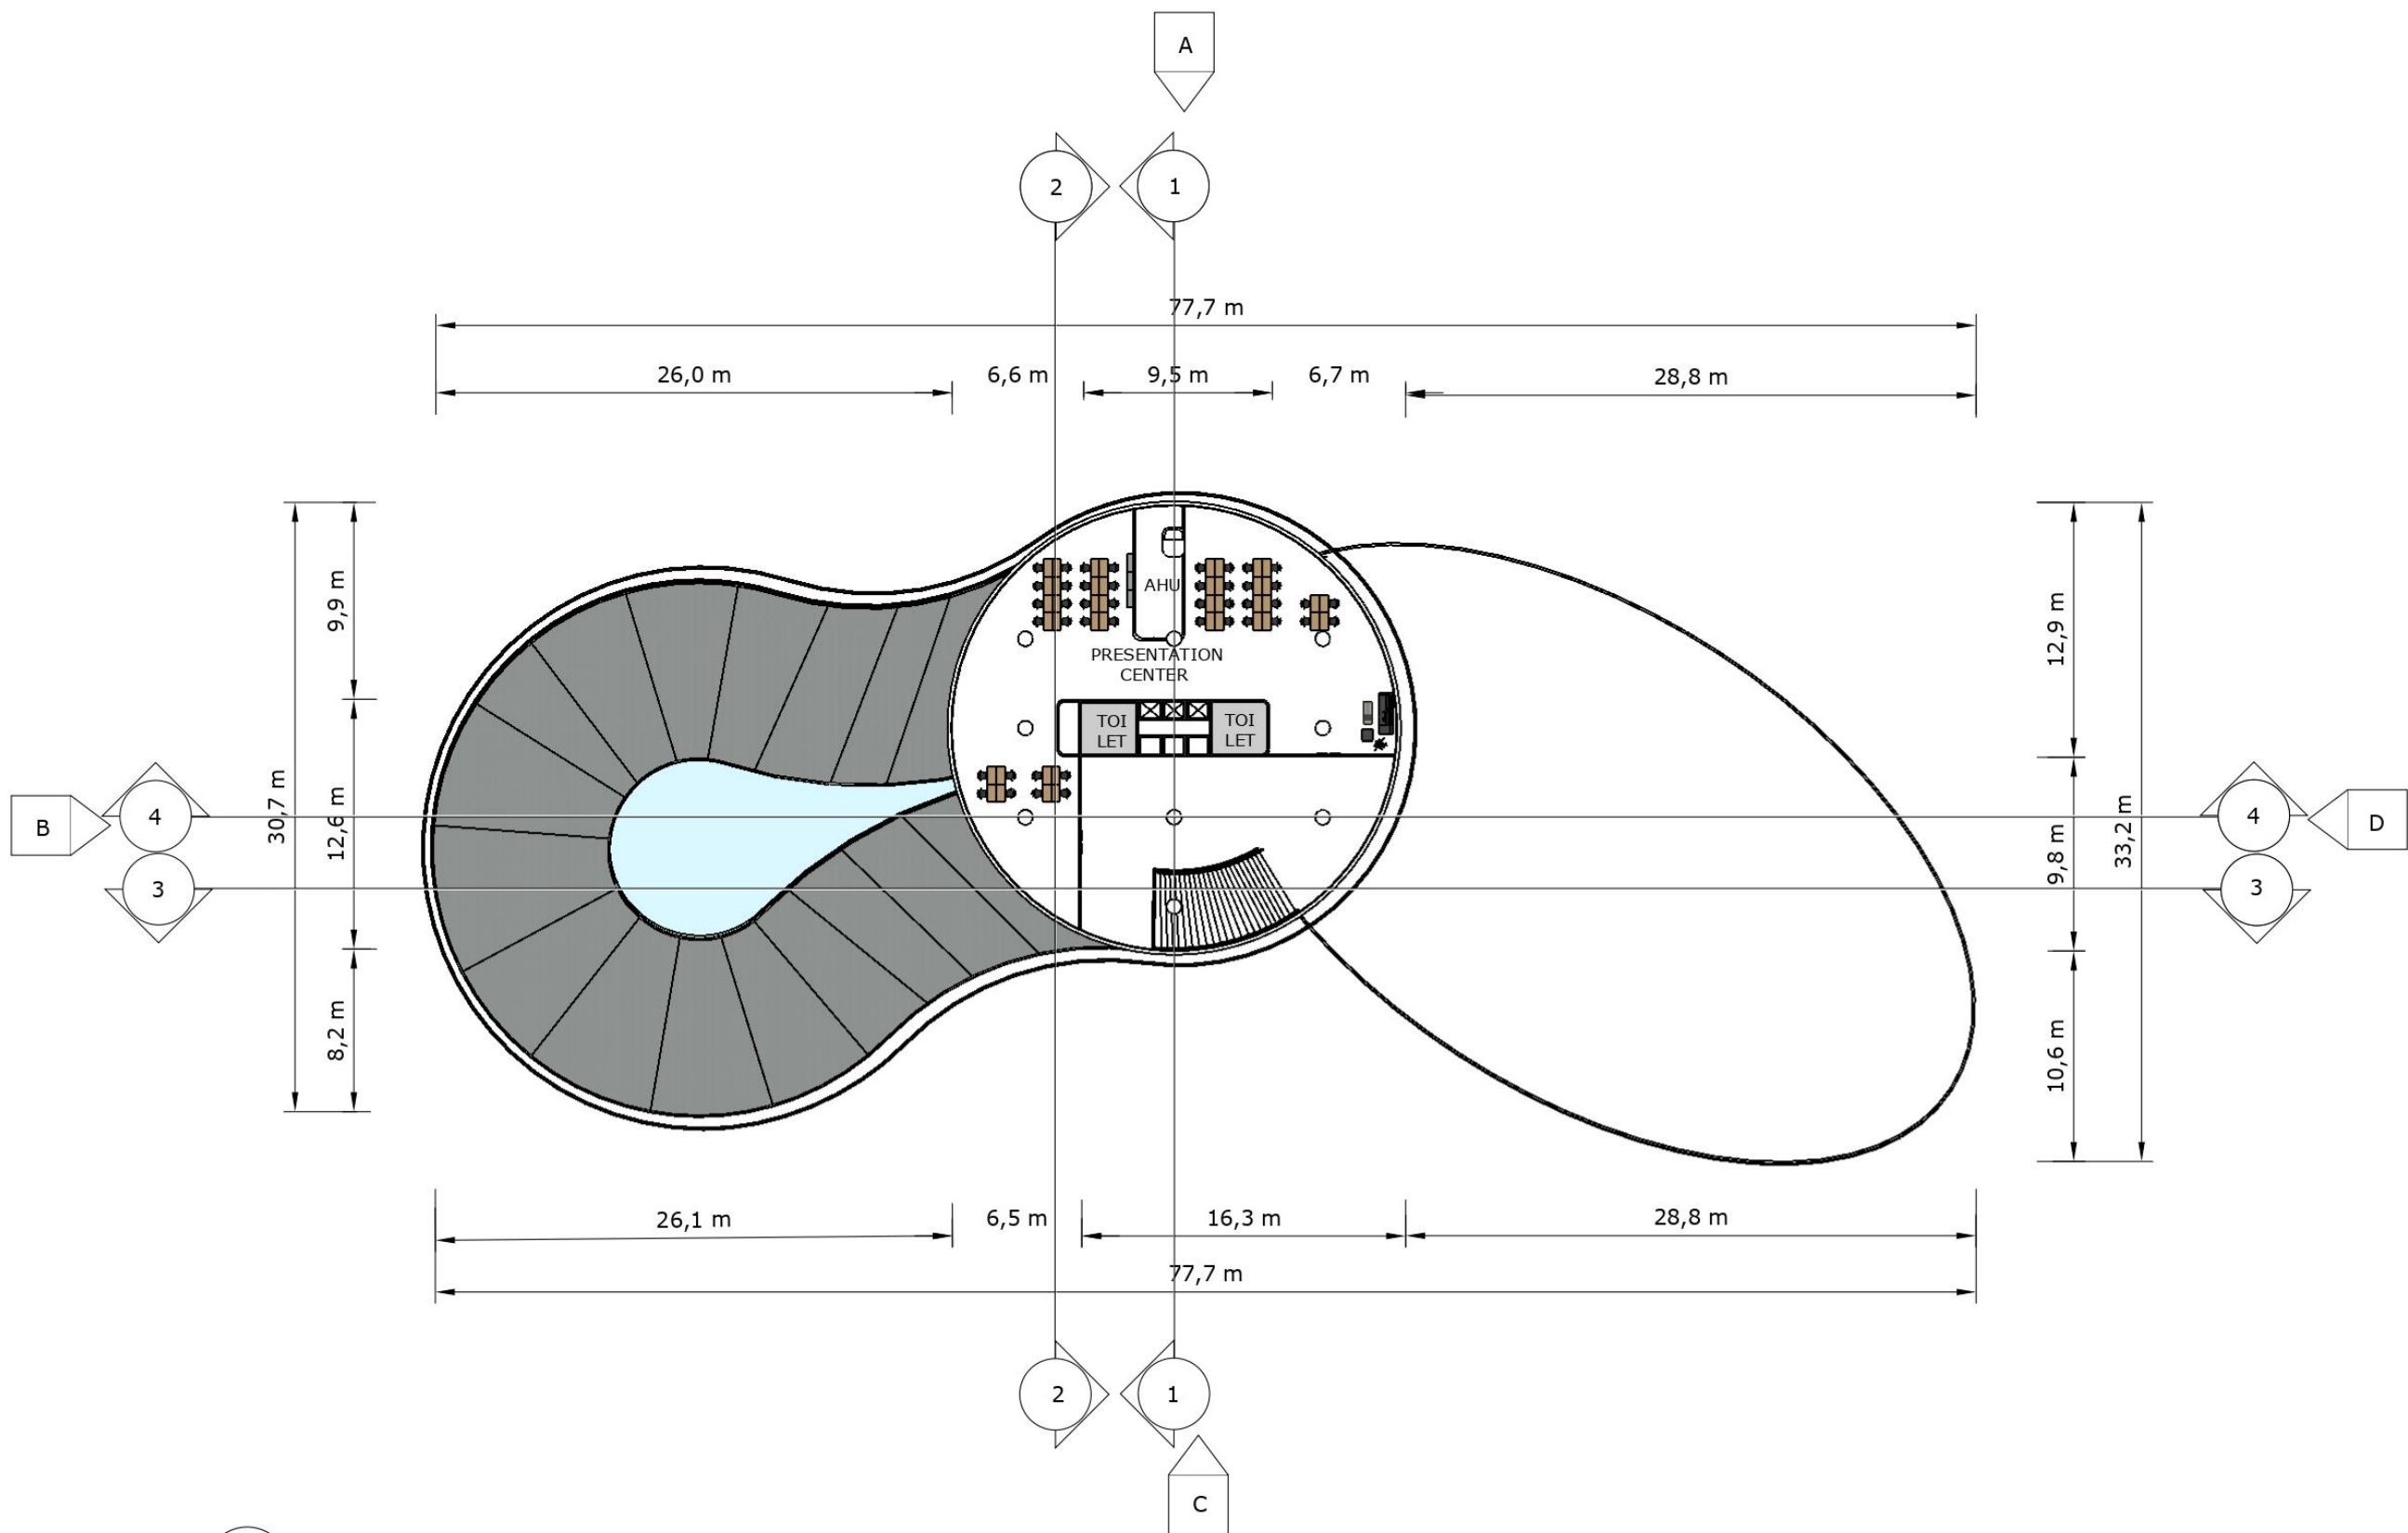

 DENAH LT 4
 skala 1:400


	NAMA - NIM	MATA KULIAH	TUTOR	DOSEN
	JESSICA NATALIA 0206031910017	COMMERCIAL SPACE DESIGN	PAK FREDDY	PAK YUSUF





DENAH LT 5
 skala 1:400

	NAMA - NIM	MATA KULIAH	TUTOR	DOSEN
	JESSICA NATALIA 0206031910017	COMMERCIAL SPACE DESIGN	PAK FREDDY	PAK YUSUF

 



 DENAH LT 6
 skala 1:400


	NAMA - NIM	MATA KULIAH	TUTOR	DOSEN
	JESSICA NATALIA 0206031910017	COMMERCIAL SPACE DESIGN	PAK FREDDY	PAK YUSUF




SECTIONS

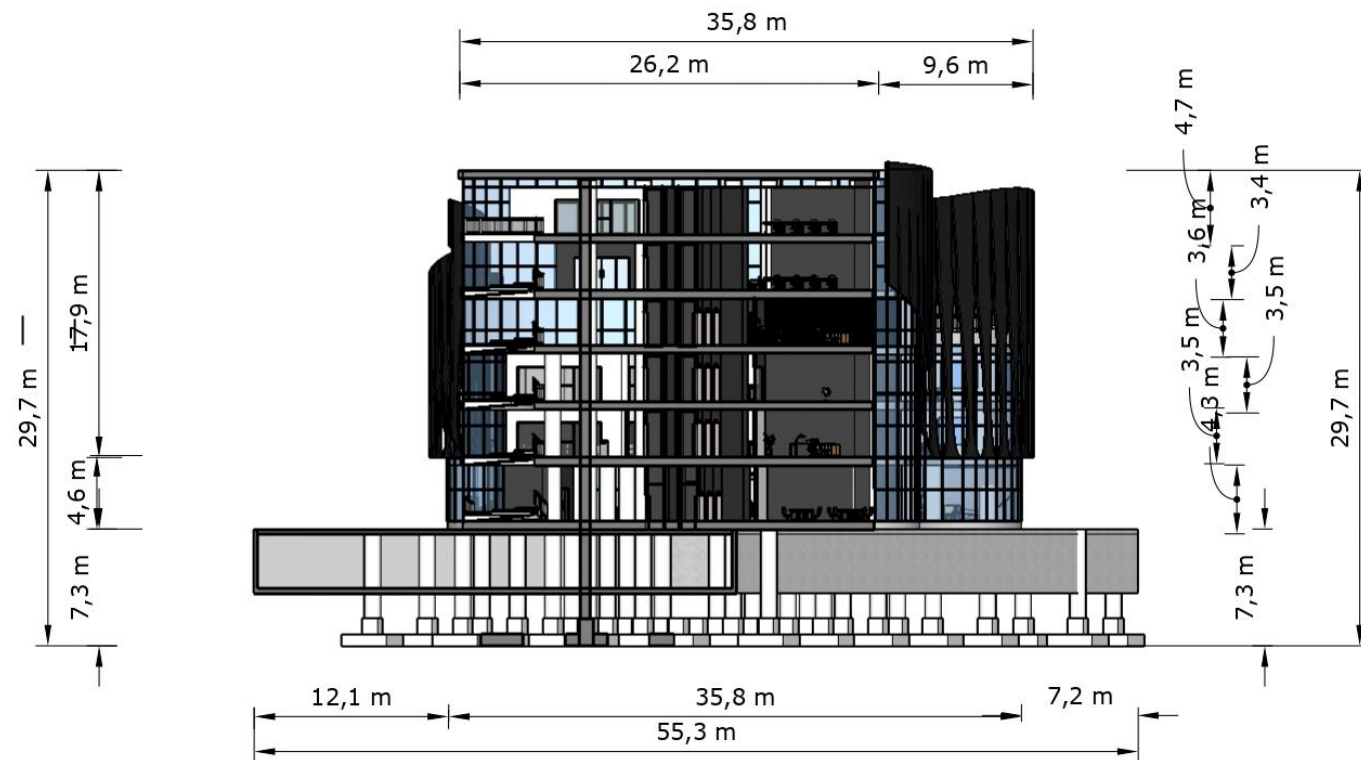


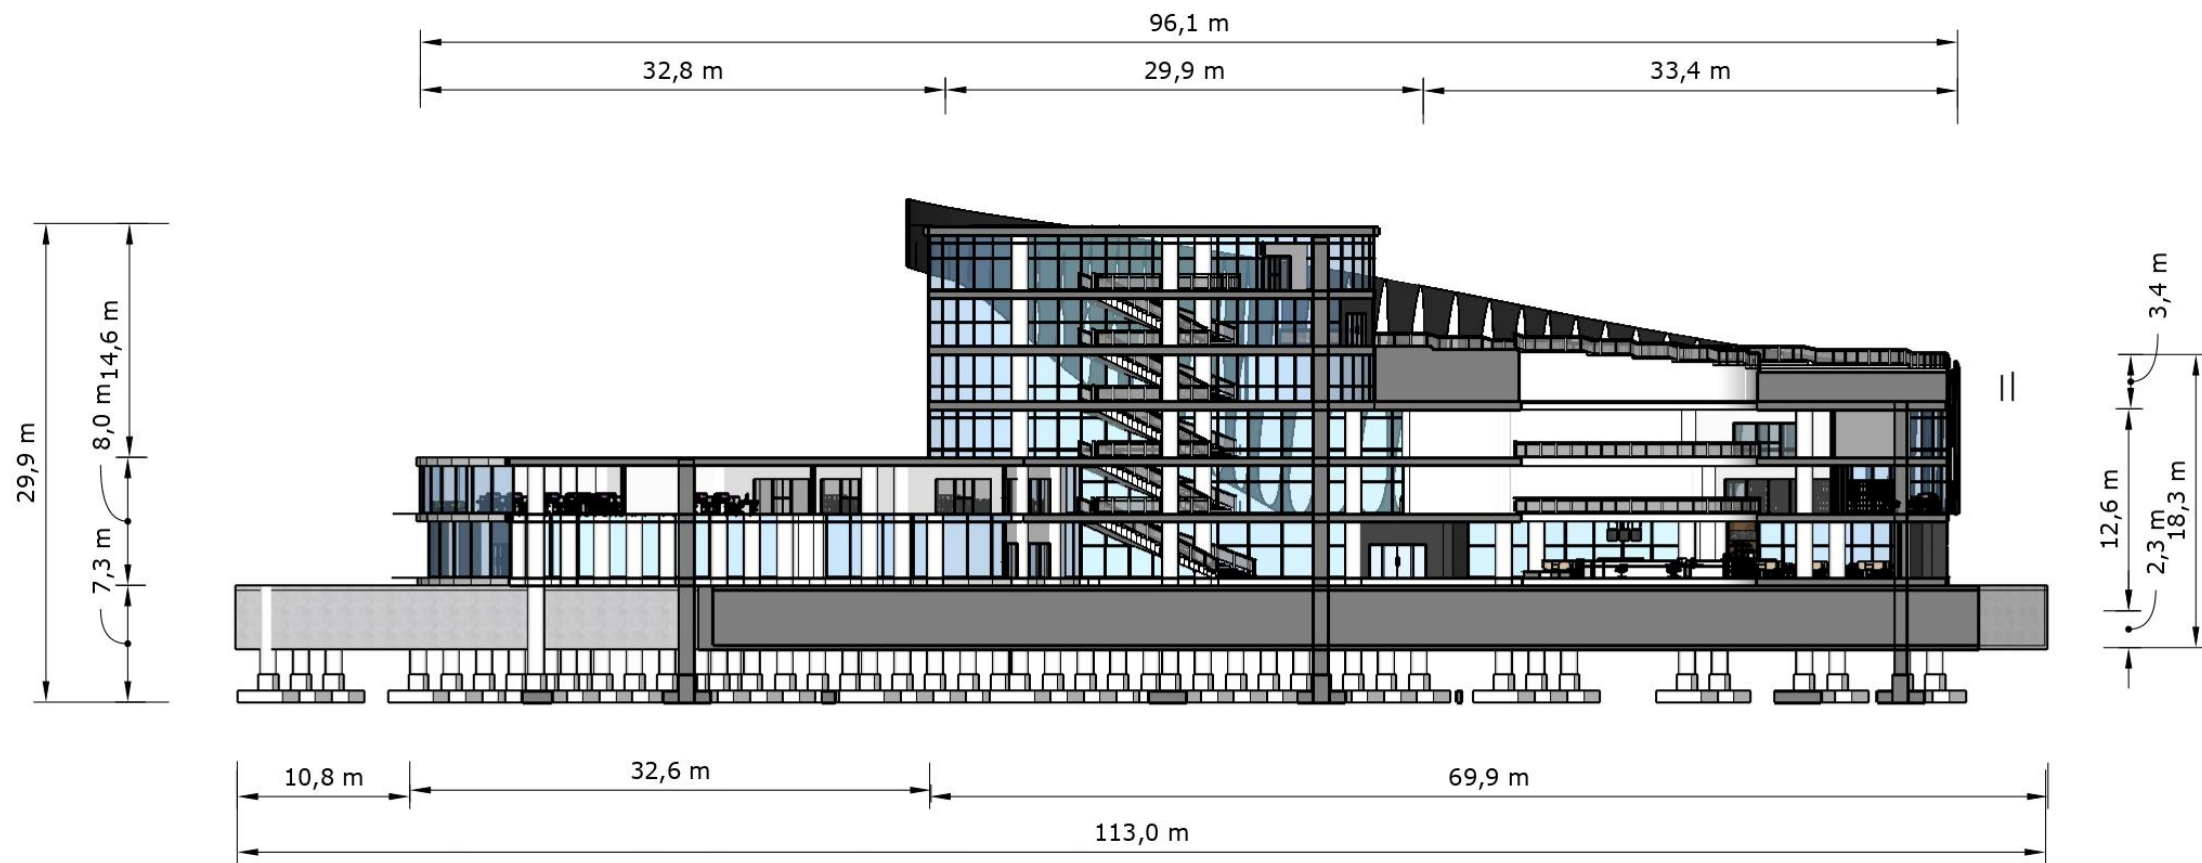
SECTION 1
skala 1:400

	NAMA - NIM	MATA KULIAH	TUTOR	DOSEN
	JESSICA NATALIA 0206031910017	COMMERCIAL SPACE DESIGN	PAK FREDDY	PAK YUSUF

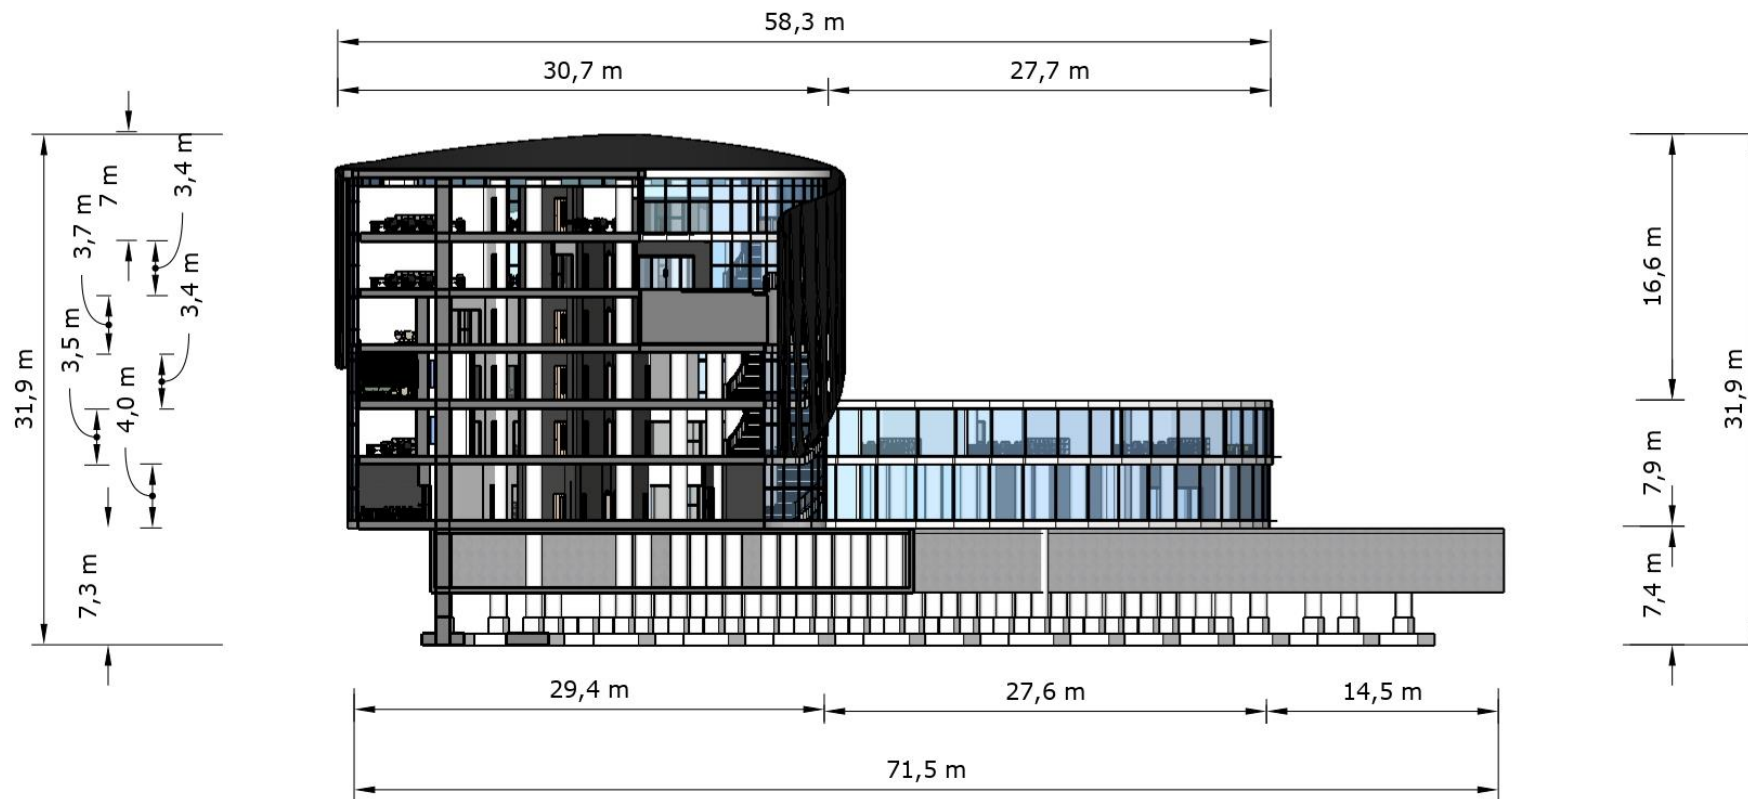


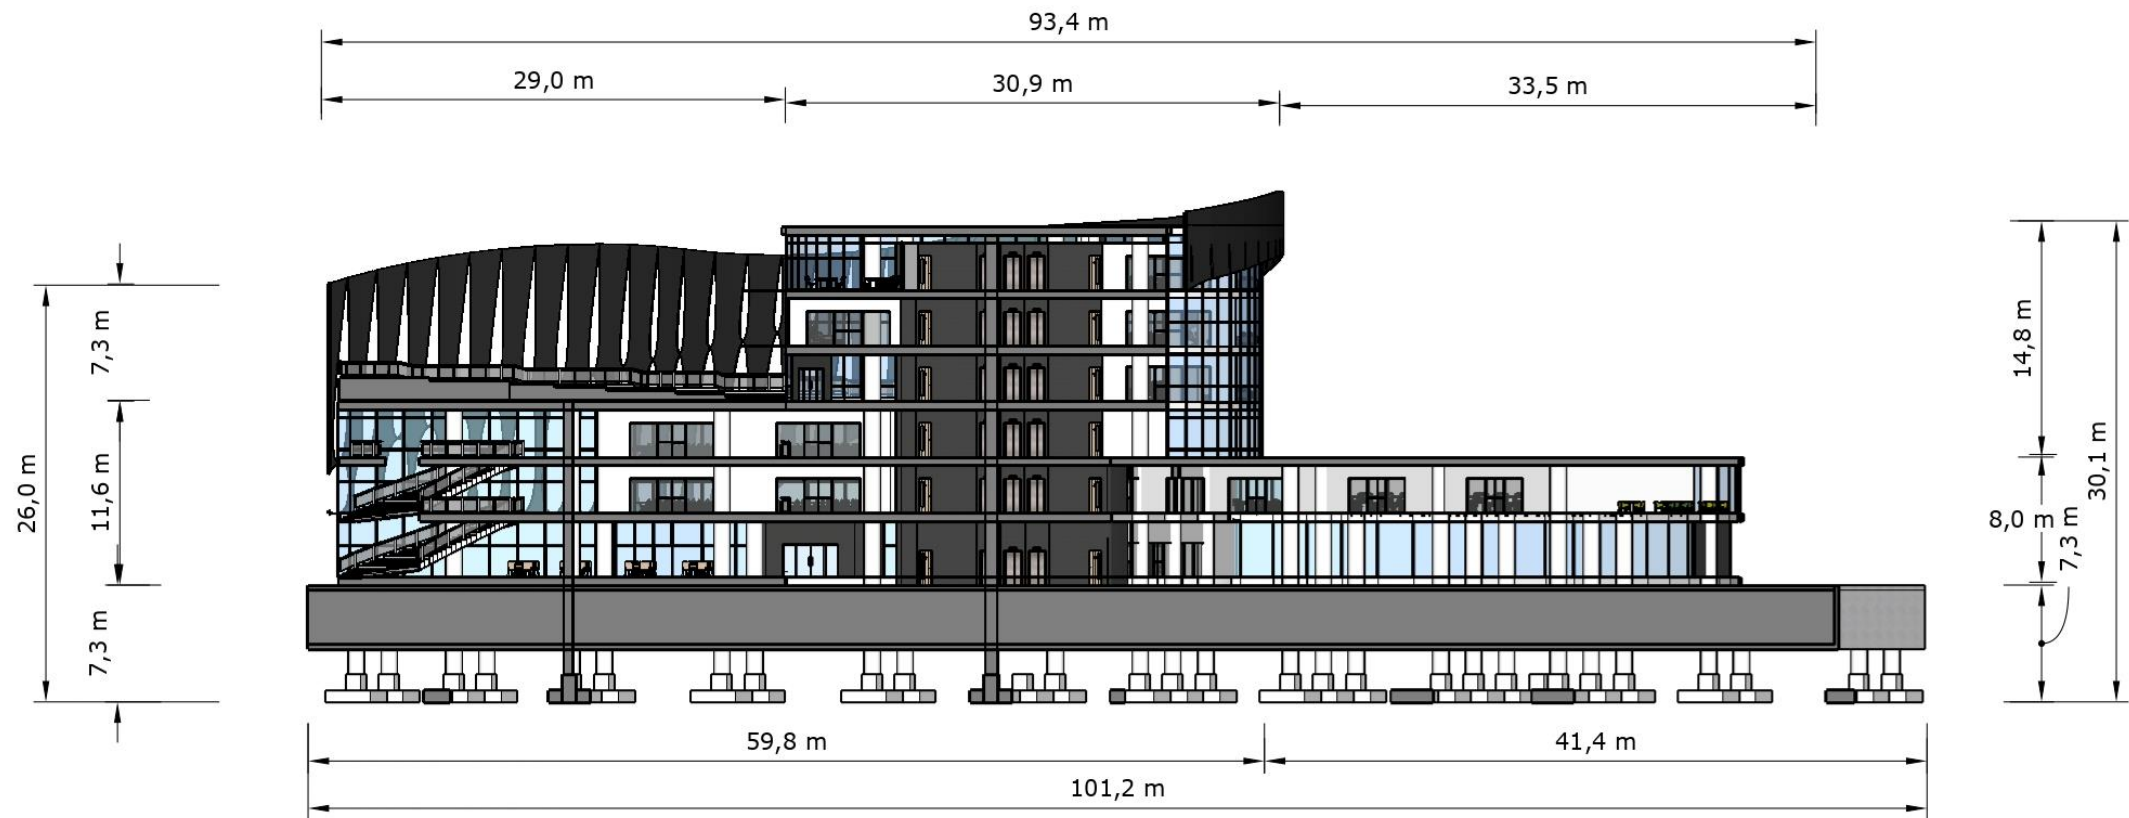
SECTION 2
skala 1:400

	NAMA - NIM	MATA KULIAH	TUTOR	DOSEN
	JESSICA NATALIA 0206031910017	COMMERCIAL SPACE DESIGN	PAK FREDDY	PAK YUSUF




SECTION 3
skala 1:400

	NAMA - NIM	MATA KULIAH	TUTOR	DOSEN
	JESSICA NATALIA 0206031910017	COMMERCIAL SPACE DESIGN	PAK FREDDY	PAK YUSUF




SECTION 4
skala 1:400


	NAMA - NIM	MATA KULIAH	TUTOR	DOSEN
	JESSICA NATALIA 0206031910017	COMMERCIAL SPACE DESIGN	PAK FREDDY	PAK YUSUF




 
ELEVATIONS

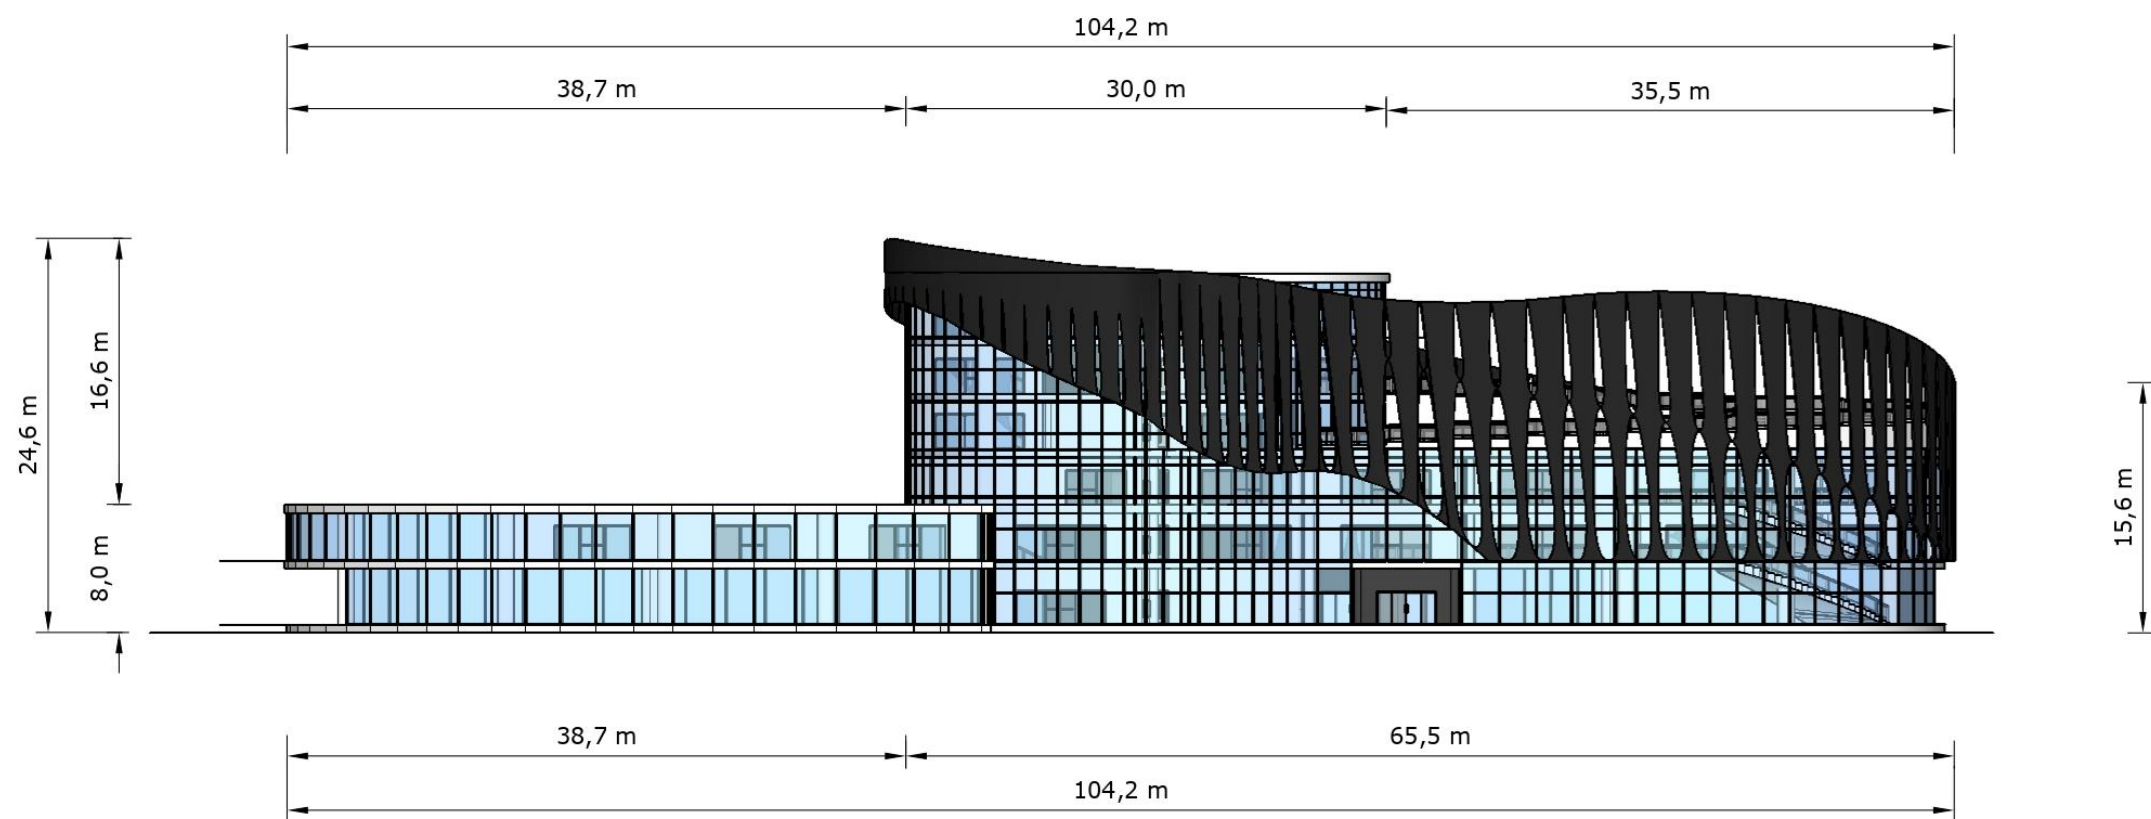


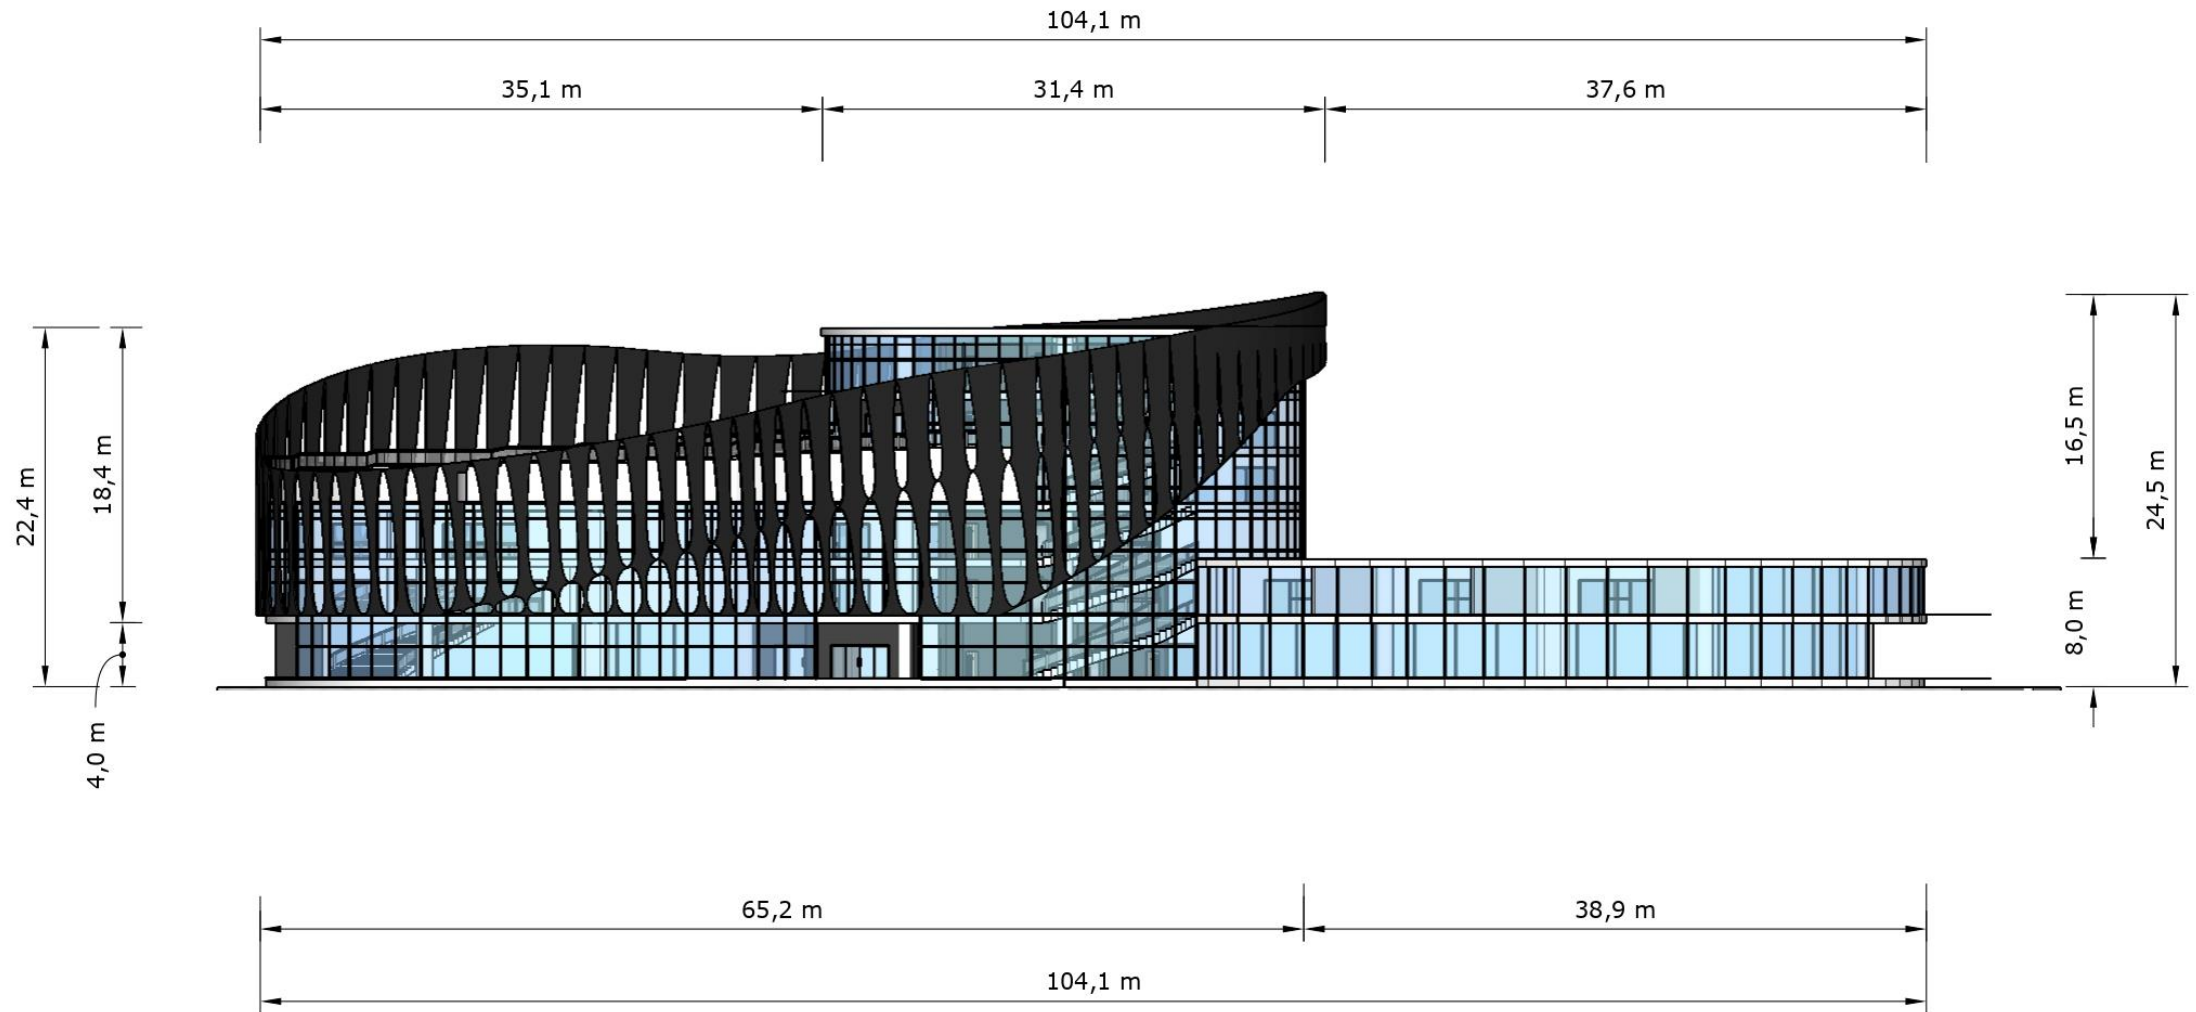

 TAMPAK A
 skala 1:400

	NAMA - NIM	MATA KULIAH	TUTOR	DOSEN
	JESSICA NATALIA 0206031910017	COMMERCIAL SPACE DESIGN	PAK FREDDY	PAK YUSUF

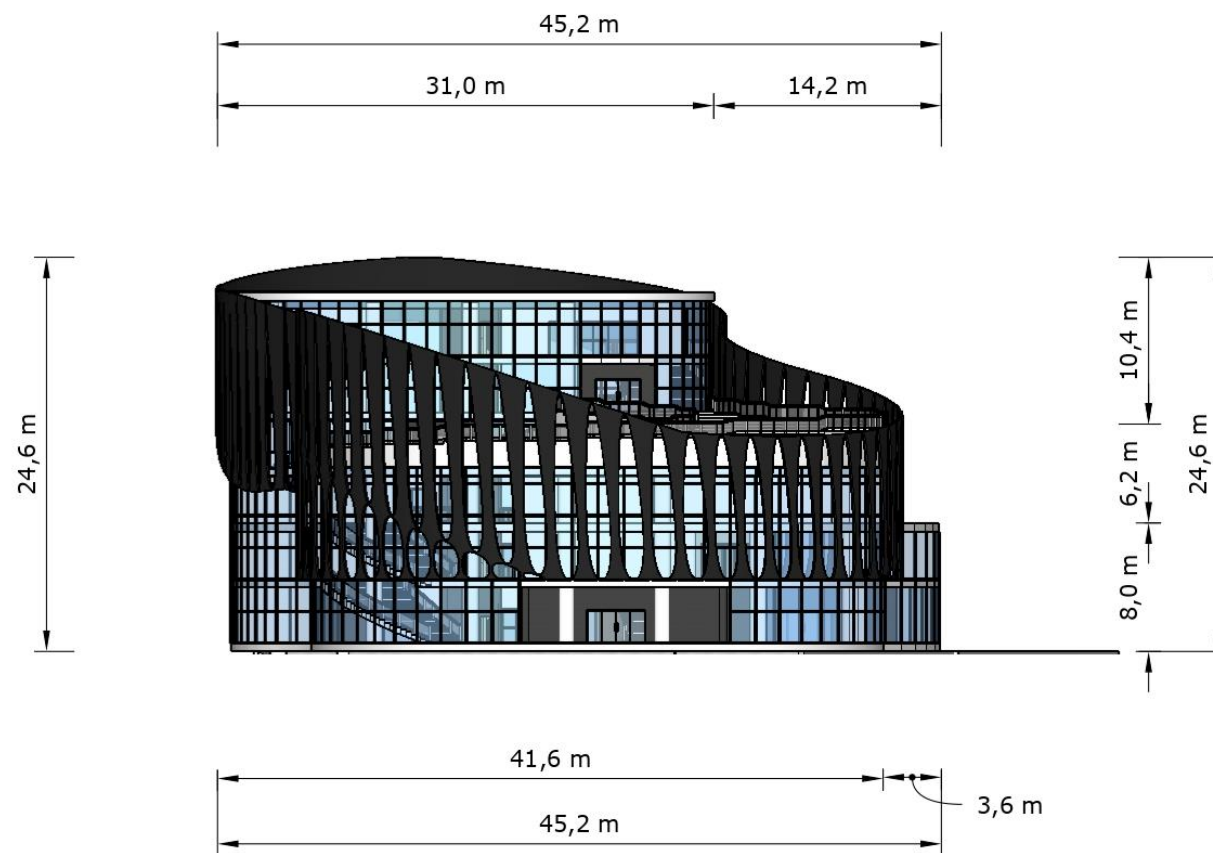


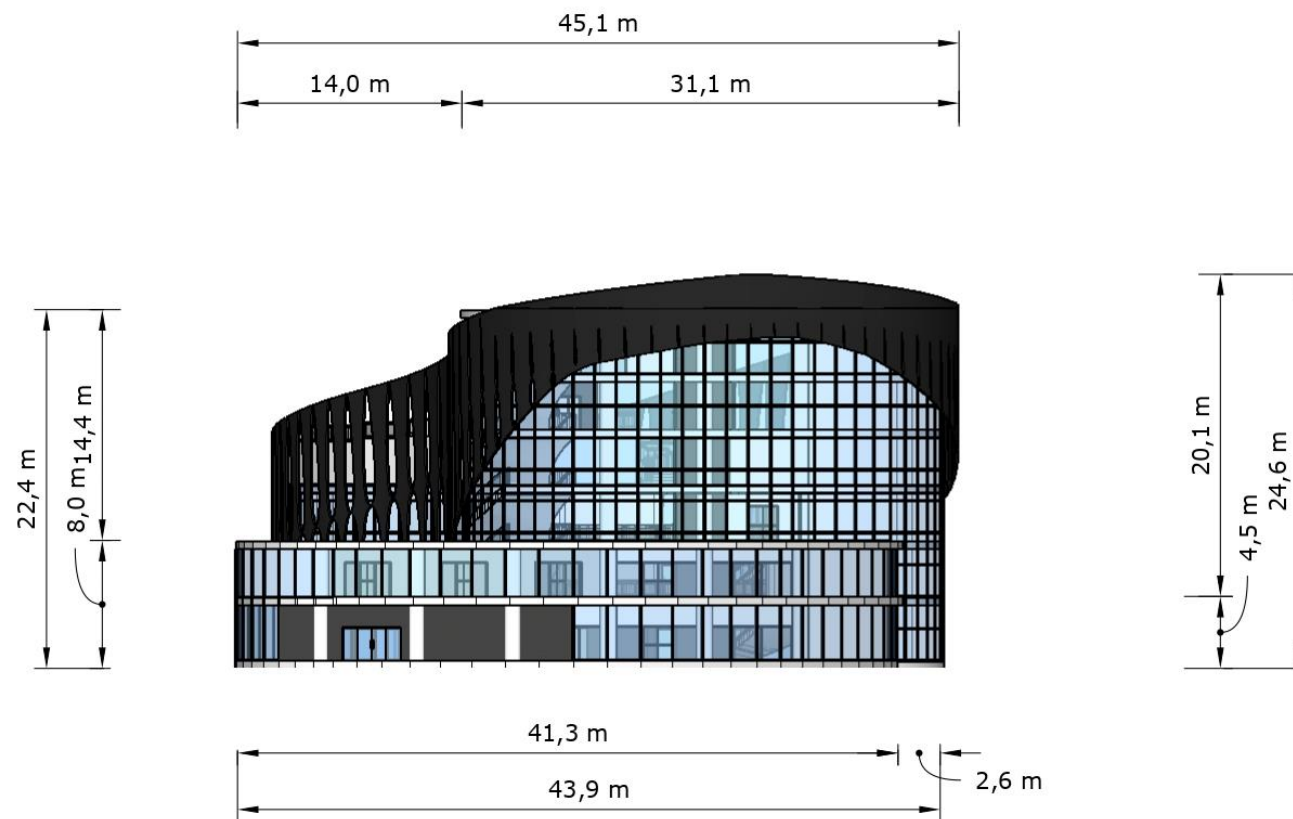

TAMPAK B
 skala 1:400

	NAMA - NIM	MATA KULIAH	TUTOR	DOSEN
	JESSICA NATALIA 0206031910017	COMMERCIAL SPACE DESIGN	PAK FREDDY	PAK YUSUF




TAMPAK C
skala 1:400

	NAMA - NIM	MATA KULIAH	TUTOR	DOSEN
	JESSICA NATALIA 0206031910017	COMMERCIAL SPACE DESIGN	PAK FREDDY	PAK YUSUF




TAMPAK D
skala 1:400


	NAMA - NIM	MATA KULIAH	TUTOR	DOSEN
	JESSICA NATALIA 0206031910017	COMMERCIAL SPACE DESIGN	PAK FREDDY	PAK YUSUF




ARCHITECTURAL DETAIL

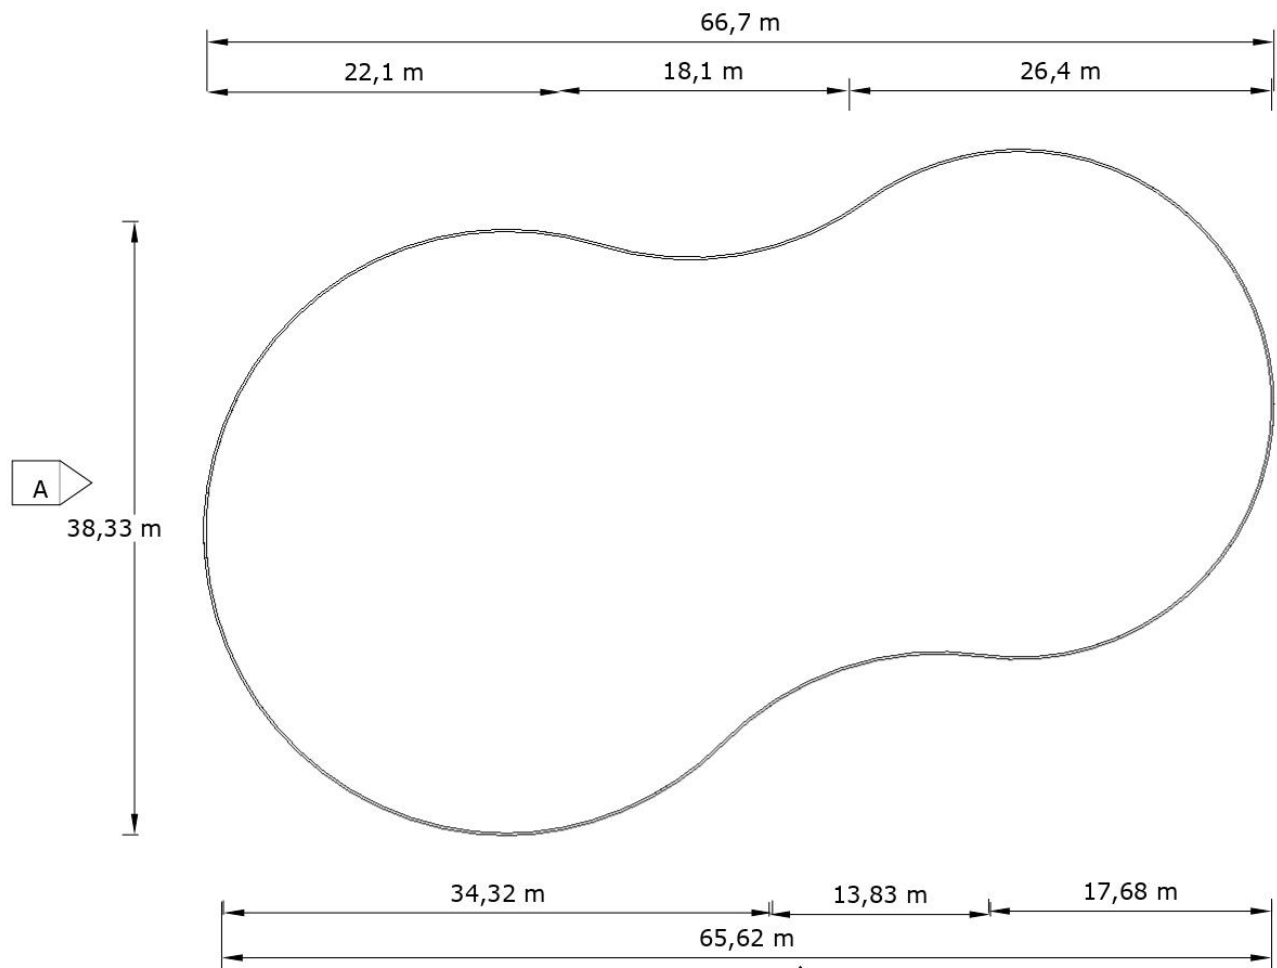

TAMPAK ATAS SECOND SKIN
skala 1:400

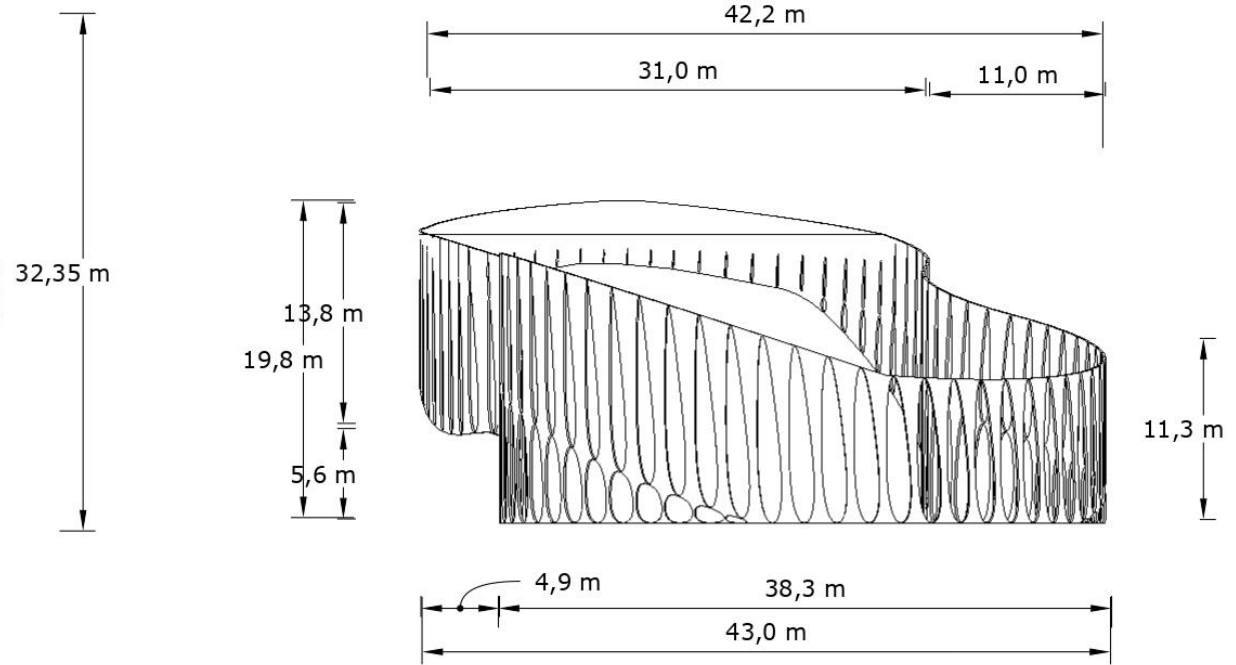


TAMPAK A SECOND SKIN
skala 1:400

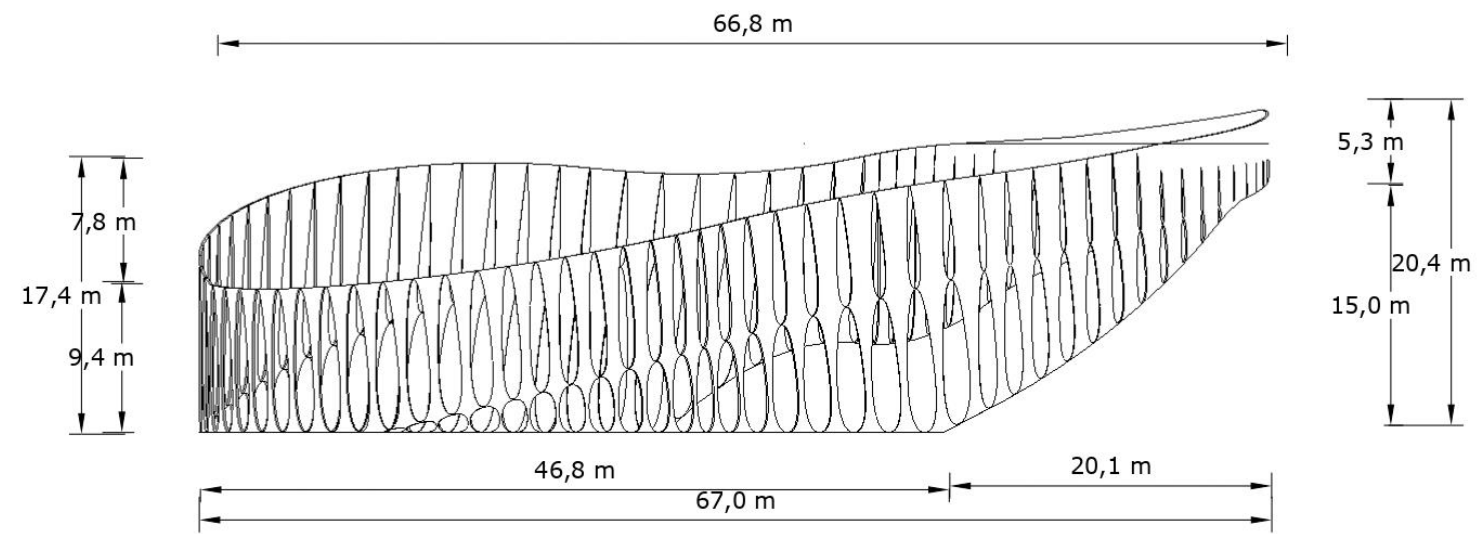


TAMPAK B SECOND SKIN
skala 1:400


	NAMA - NIM	MATA KULIAH	TUTOR	DOSEN
	JESSICA NATALIA 0206031910017	COMMERCIAL SPACE DESIGN	PAK FREDDY	PAK YUSUF

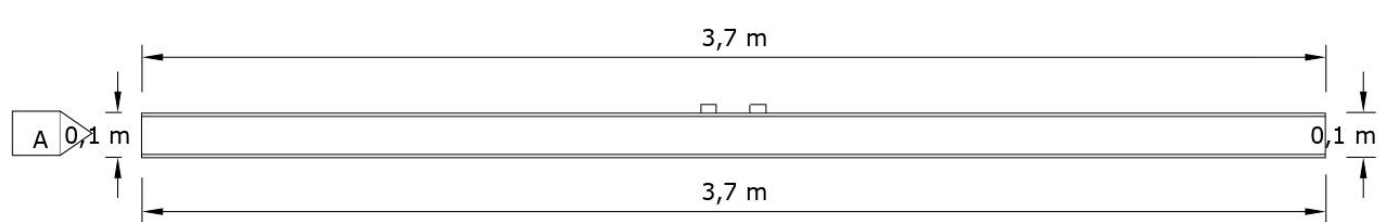

TAMPAK ATAS PINTU 1
skala 1:20

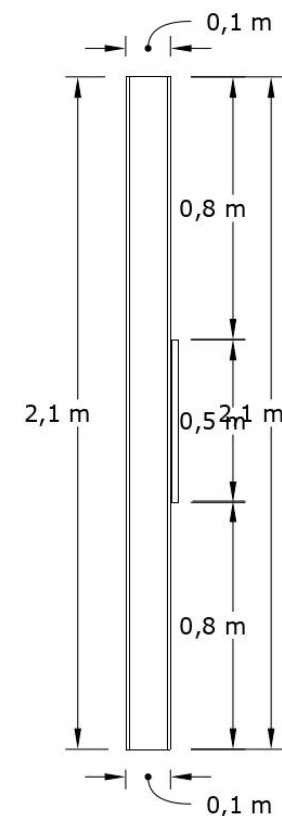


TAMPAK A PINTU 1
skala 1:20

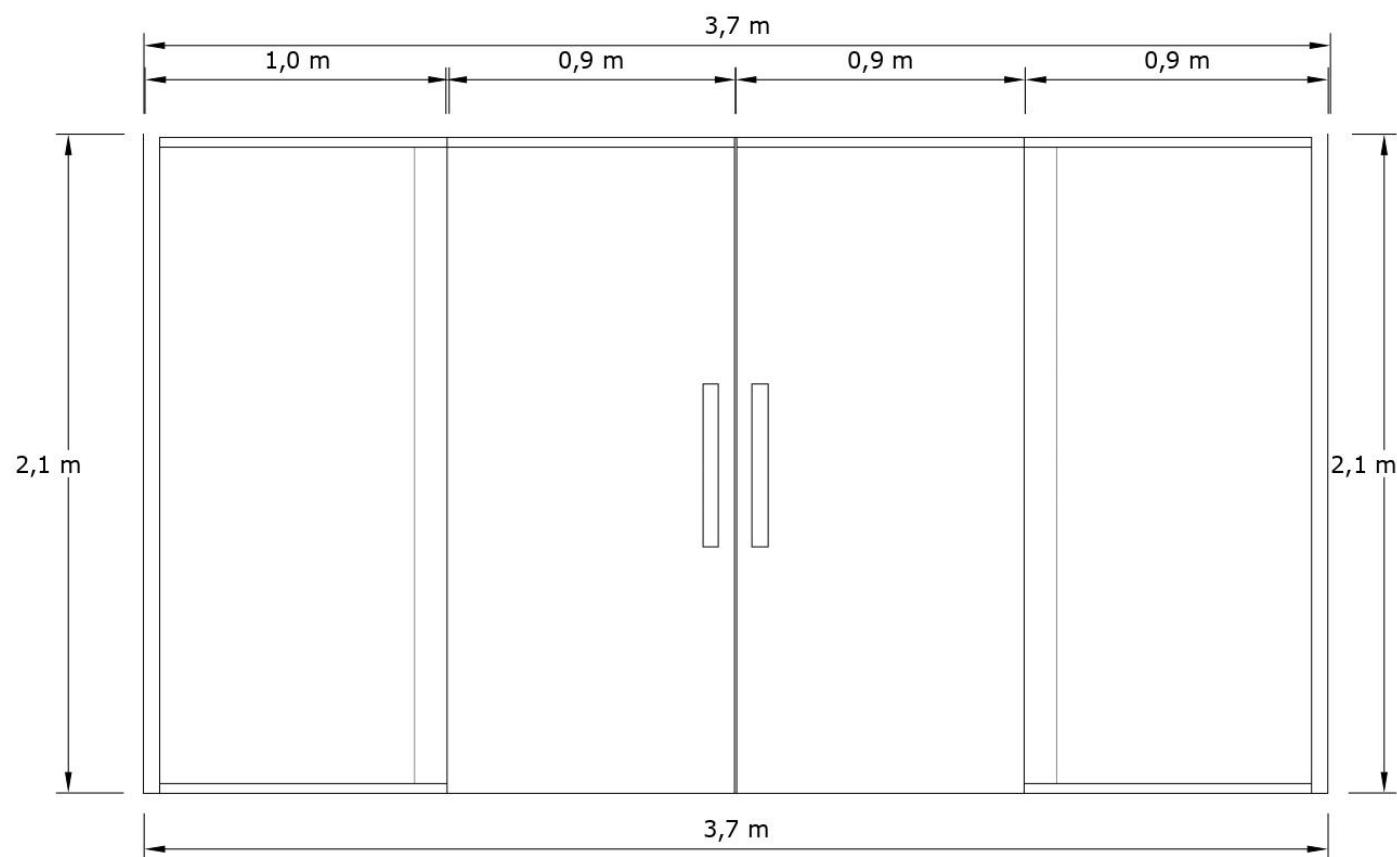


TAMPAK B PINTU 1
skala 1:20


	NAMA - NIM	MATA KULIAH	TUTOR	DOSEN
	JESSICA NATALIA 0206031910017	COMMERCIAL SPACE DESIGN	PAK FREDDY	PAK YUSUF

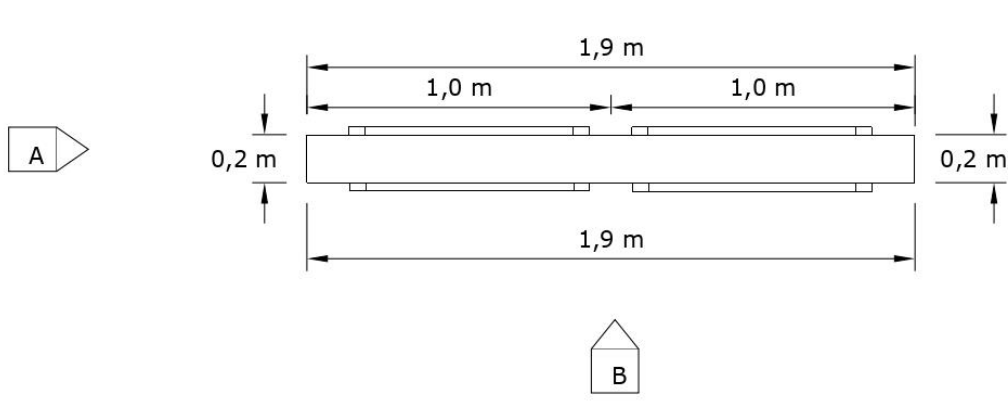


TAMPAK ATAS PINTU 2
skala 1:20

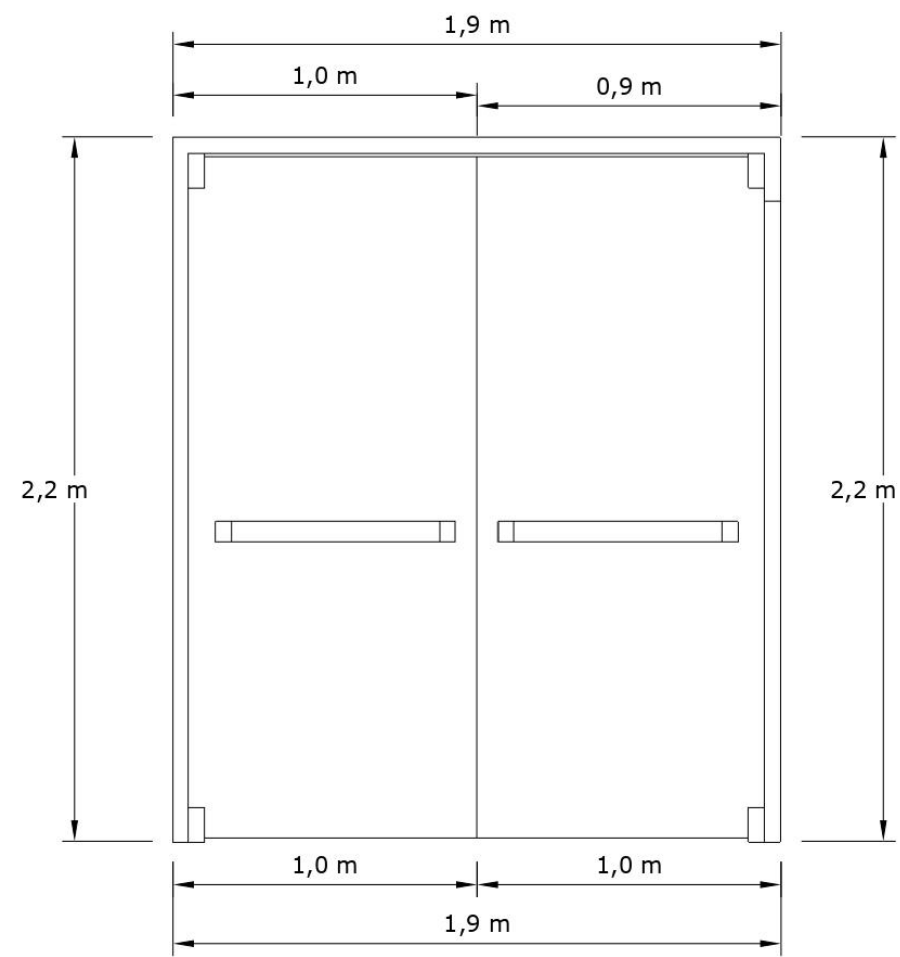

TAMPAK B PINTU 2
skala 1:20

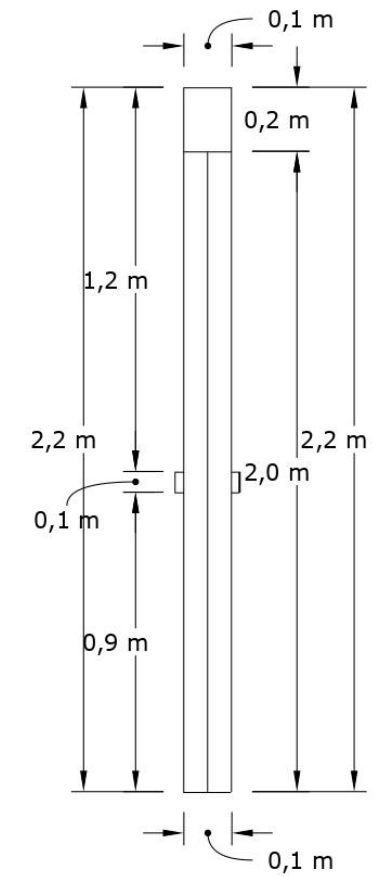

TAMPAK A PINTU 2
skala 1:20

	NAMA - NIM	MATA KULIAH	TUTOR	DOSEN
	JESSICA NATALIA 0206031910017	COMMERCIAL SPACE DESIGN	PAK FREDDY	PAK YUSUF




MEP

PLUMBING

PRODUCED BY AN AUTODESK STUDENT VERSION


PRODUCED BY AN AUTODESK STUDENT VERSION

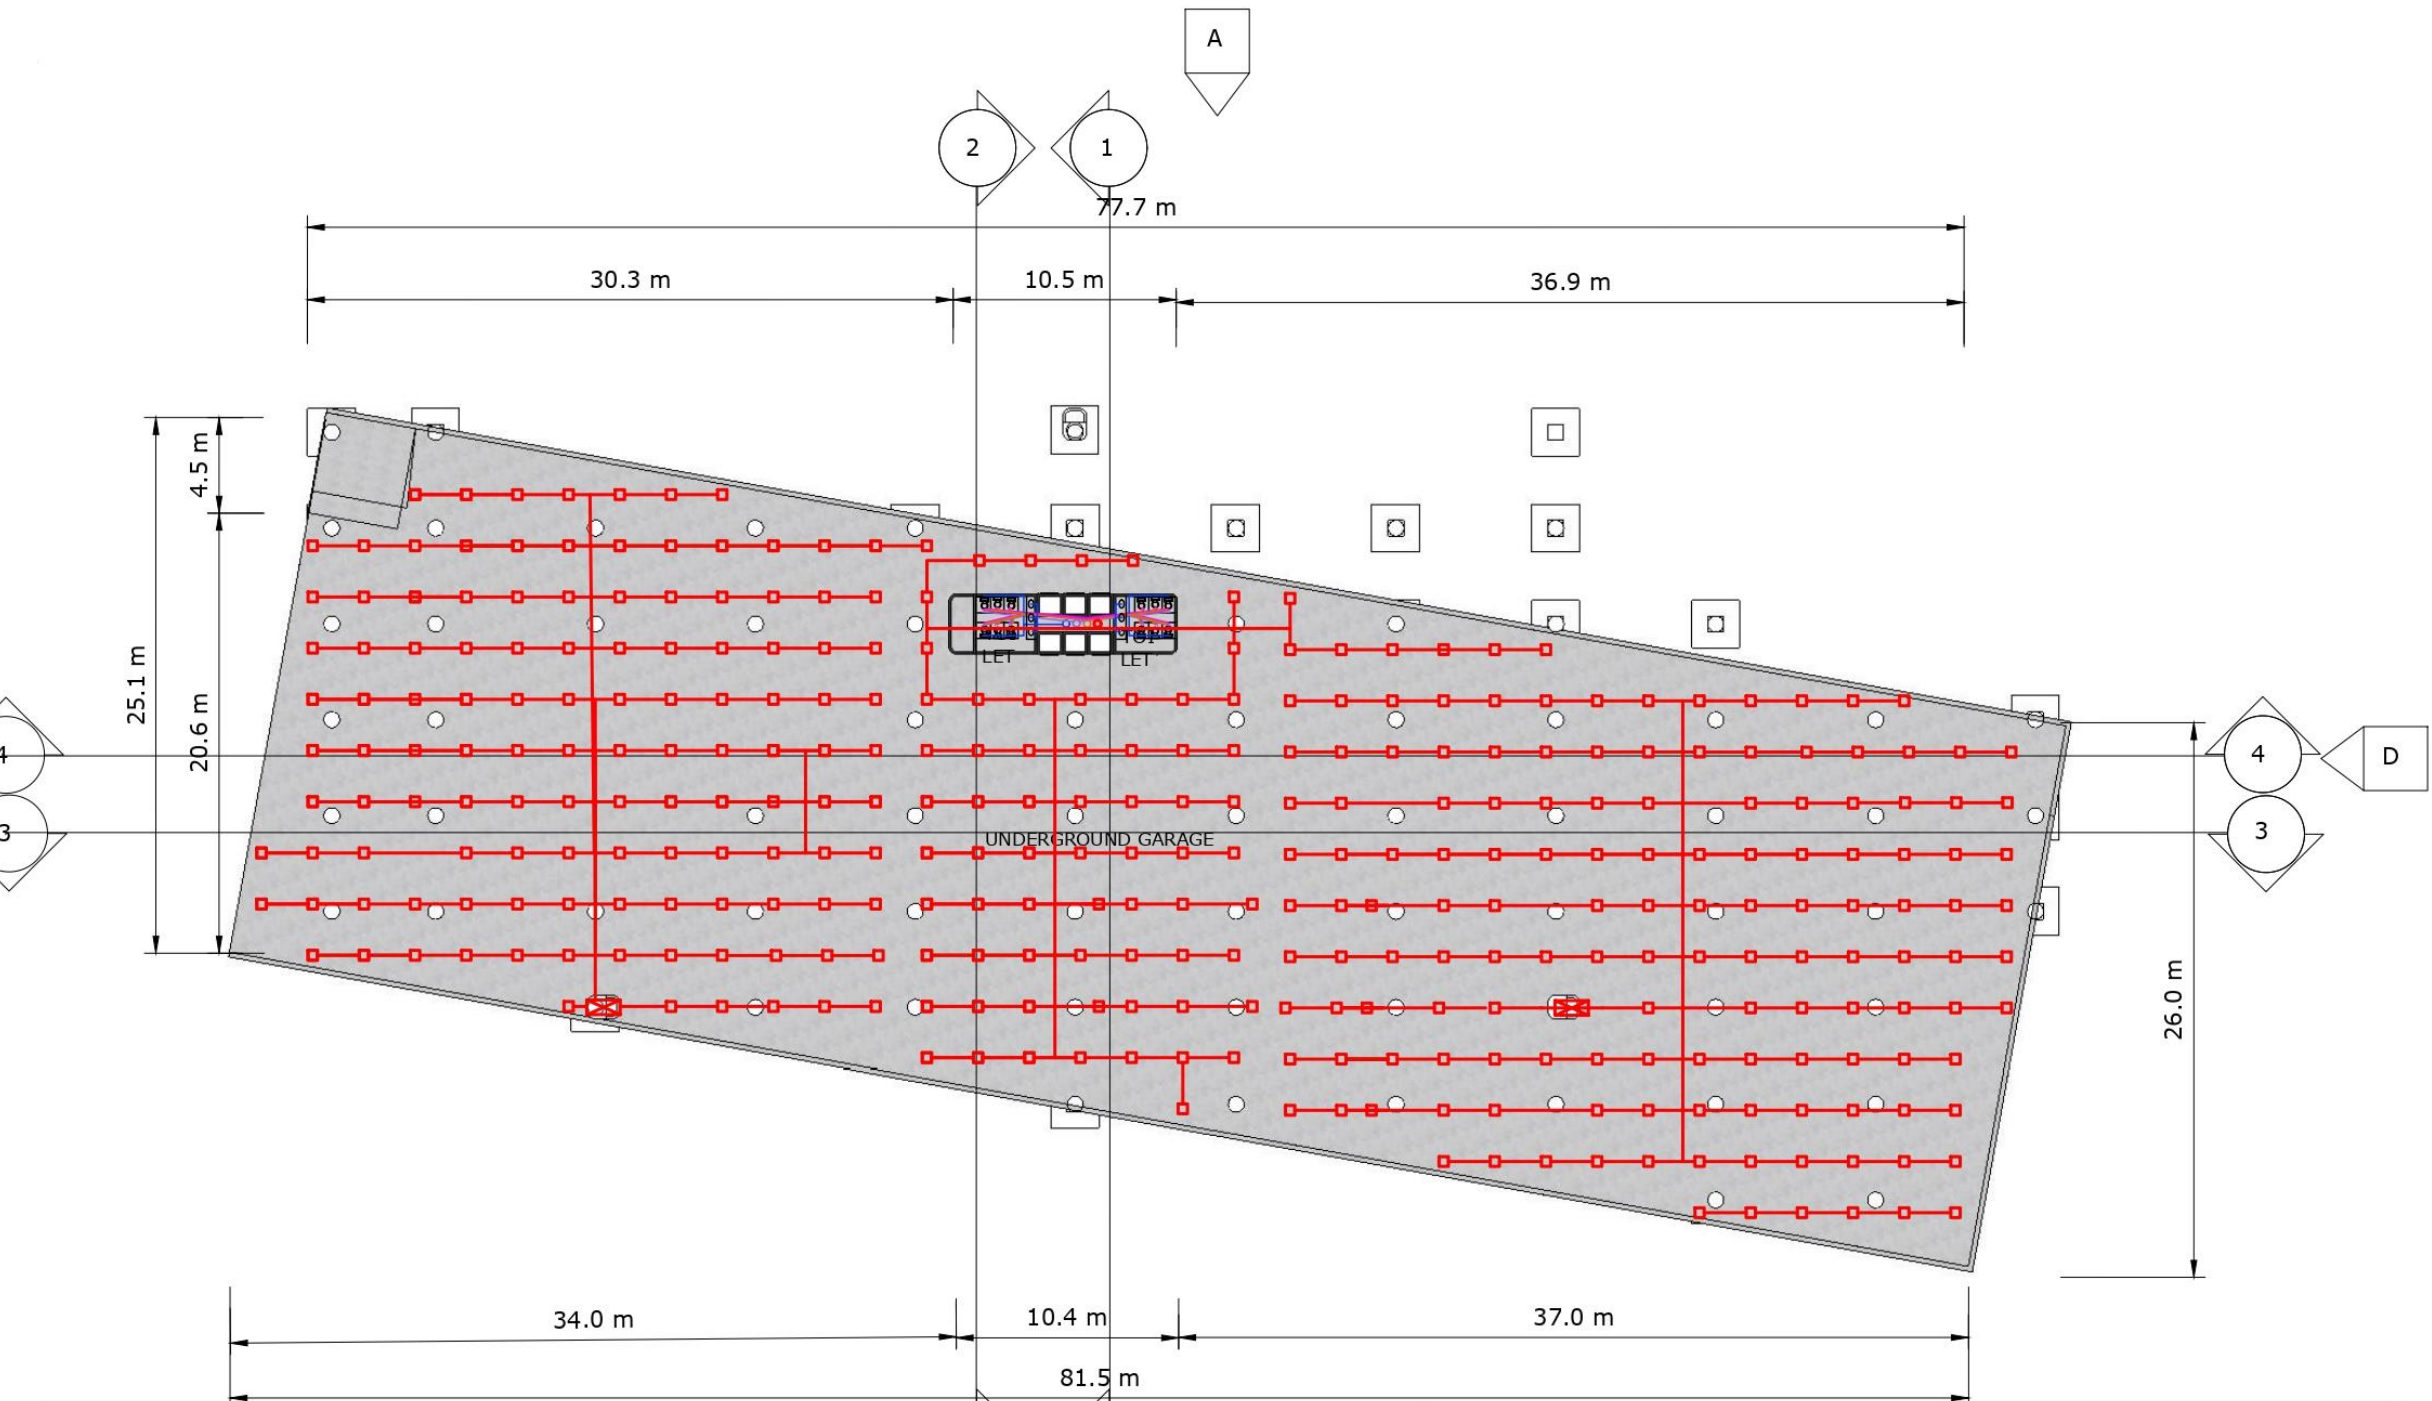

DENAH BASEMENT
skala 1:400


LEGENDA			
— (Blue)	PIPA AIR BERSIH	— (Red)	PIPA SPRINKLER
— (Purple)	PIPA AIR KOTOR	□ (Red)	SPRINKLER
— (Orange)	PIPA KOTORAN	⊗ (Red)	SHAFT SPRINKLER
— (Green)	PIPA VENT	○ (Yellow)	PIPA VERTIKAL KOTORAN
— (Blue)	PIPA VERTIKAL AIR HUJAN	○ (Red)	PIPA VERTIKAL SPRINKLER
○ (Blue)	METERAN AIR	⊕ (Blue)	POMPA AIR
⊕ (Blue)	TANDON AIR	⊕ (Blue)	KATUP AIR

PRODUCED BY AN AUTODESK STUDENT VERSION

	NAMA - NIM	MATA KULIAH	TUTOR	DOSEN
	JESSICA NATALIA 0206031910017	COMMERCIAL SPACE DESIGN	PAK FREDDY	PAK YUSUF

PRODUCED BY AN AUTODESK STUDENT VERSION

PRODUCED BY AN AUTODESK STUDENT VERSION

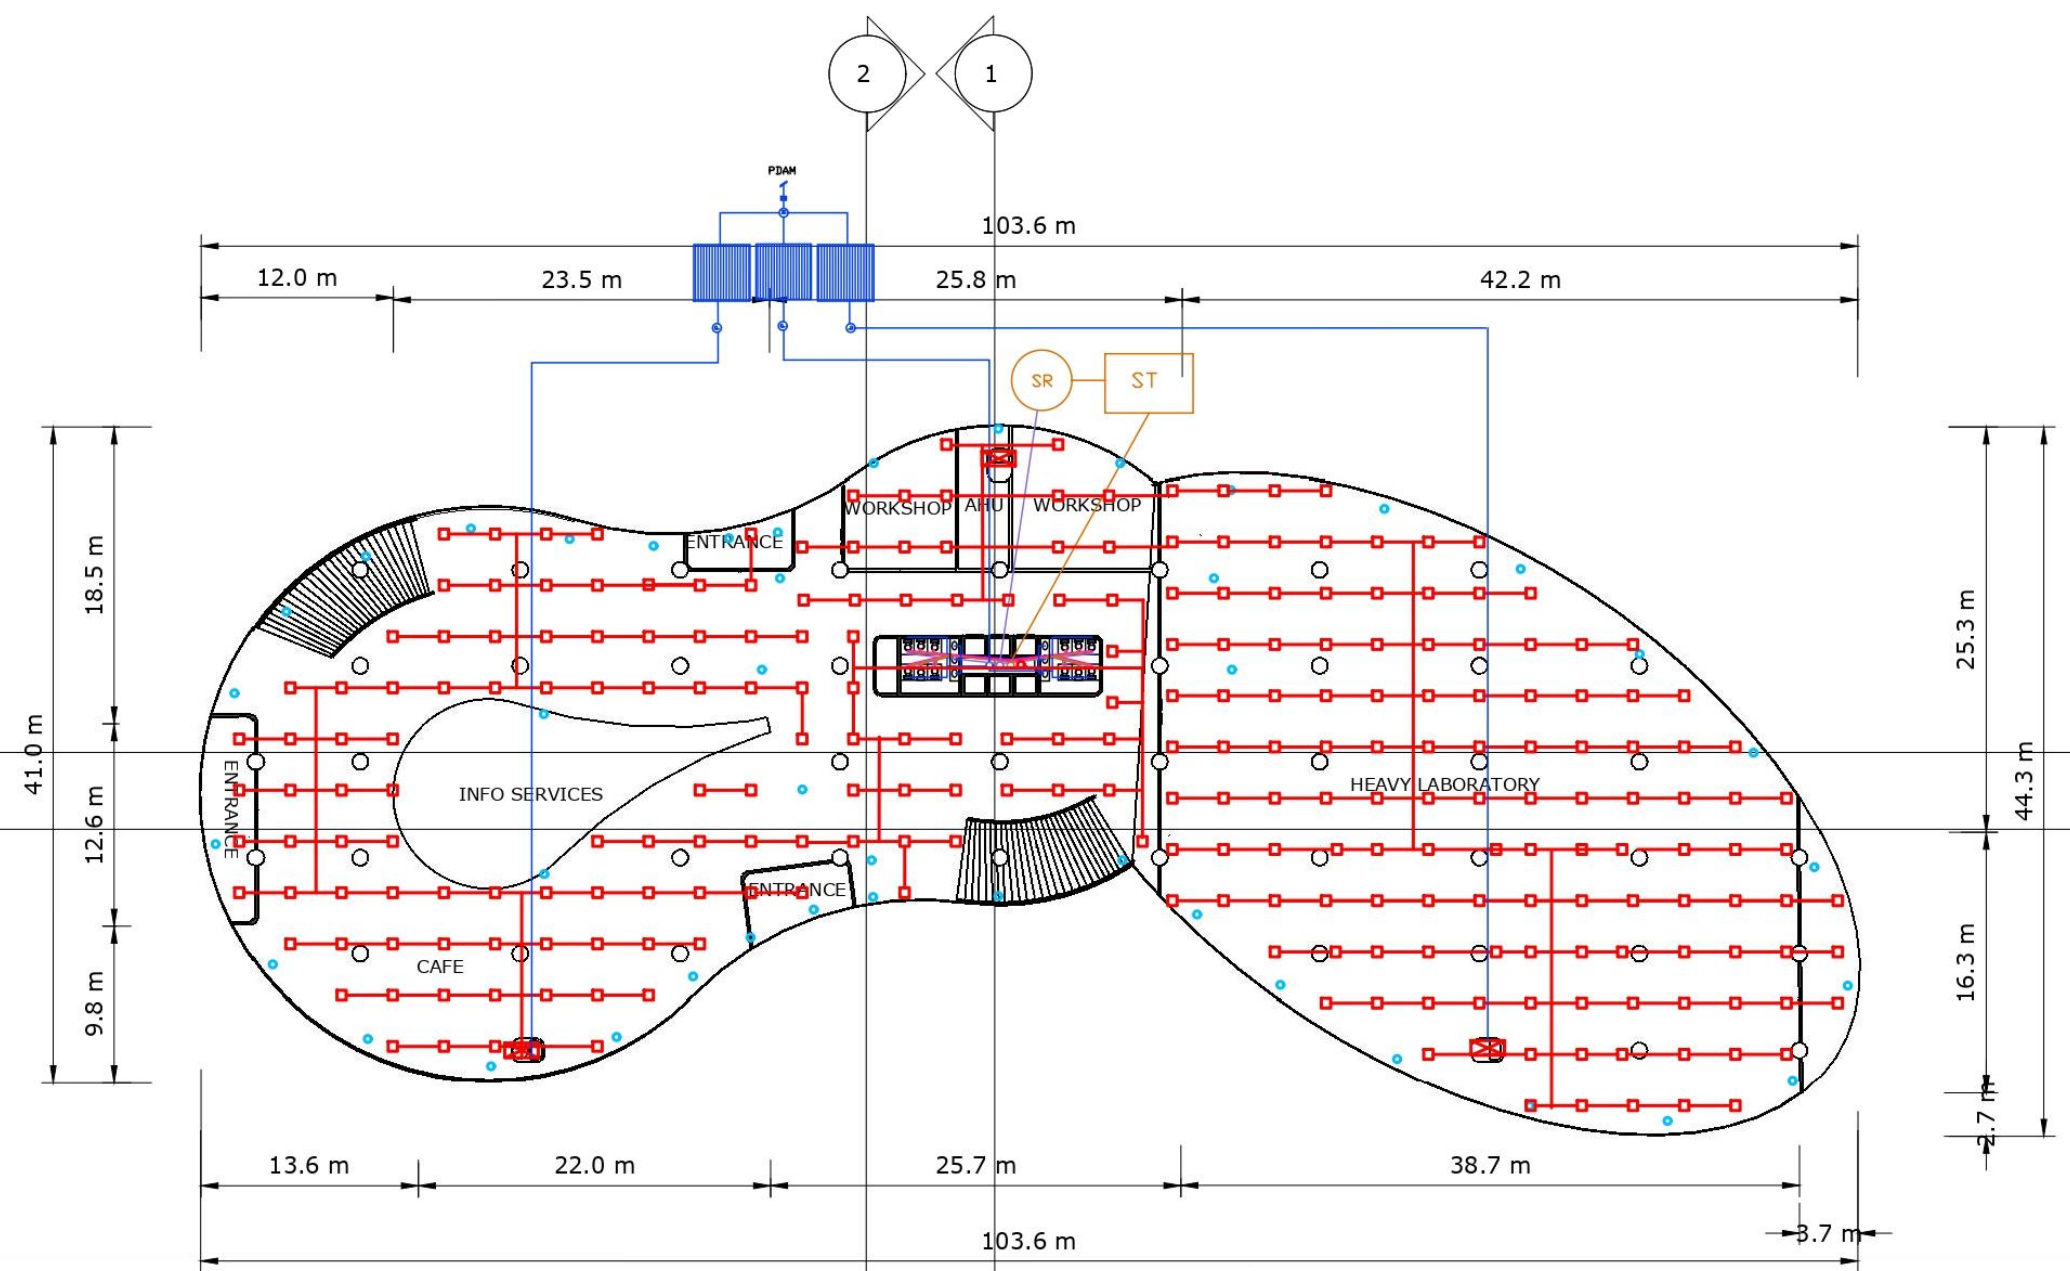


DENAH LT 1
skala 1:400

LEGENDA					
	PIPA AIR HUJAN		PIPA VERTIKAL KOTORAN		PIPA SPRINKLER
	PIPA AIR BERSIH		PIPA VERTIKAL SPRINKLER		SPRINKLER
	PIPA AIR KOTOR		METERAN AIR		SHAFT SPRINKLER
	PIPA KOTORAN		POMPA AIR		
	PIPA VENT		TANDON AIR		
	PIPA VERTIKAL AIR HUJAN		KATUP AIR		
	PIPA VERTIKAL AIR BERSIH		SEPTIC TANK		
	PIPA VERTIKAL AIR KOTOR		SUMUR RESAPAN		

	NAMA - NIM	MATA KULIAH	TUTOR	DOSEN
	JESSICA NATALIA 0206031910017	COMMERCIAL SPACE DESIGN	PAK FREDDY	PAK YUSUF

PRODUCED BY AN AUTODESK STUDENT VERSION

PRODUCED BY AN AUTODESK STUDENT VERSION

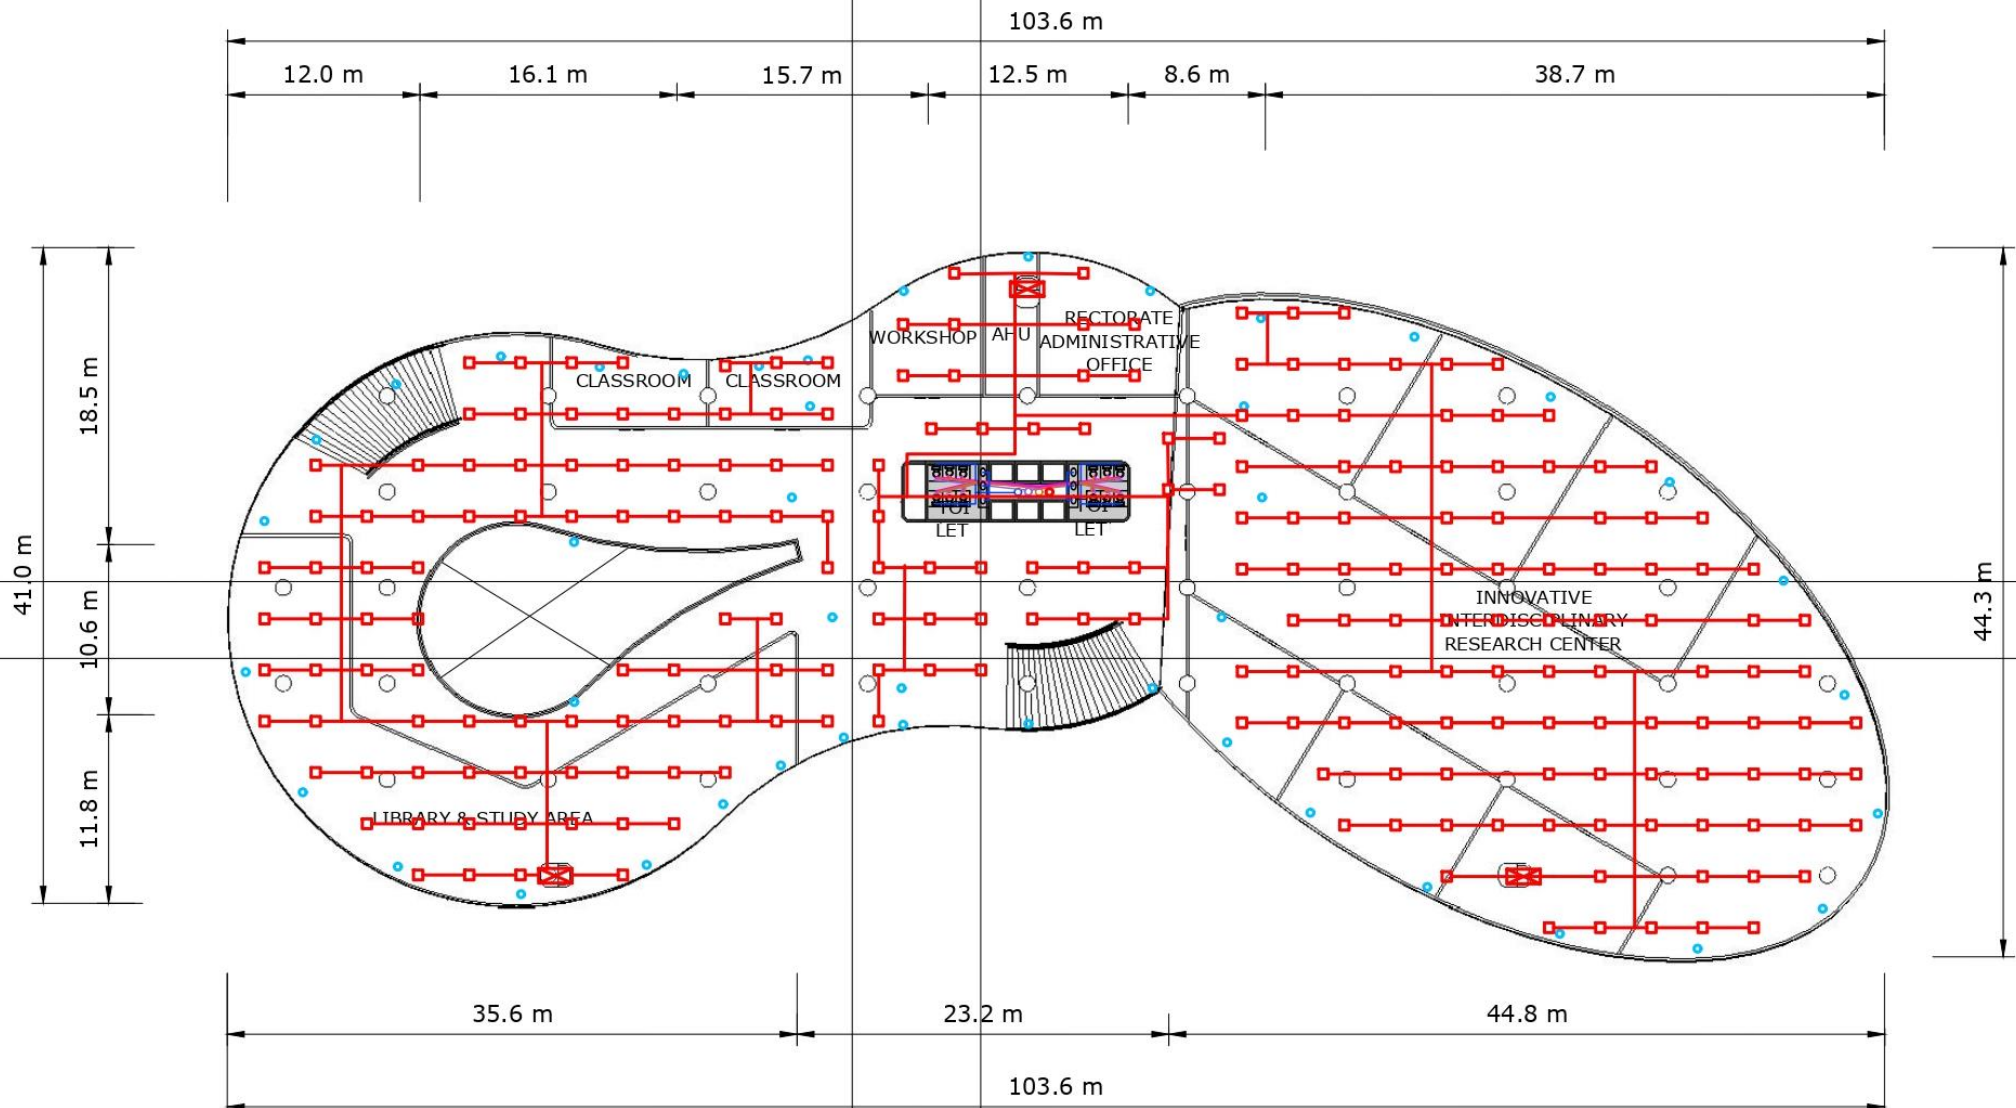


DENAH LT 2
skala 1:400

LEGENDA					
	PIPA AIR HUJAN		PIPA VERTIKAL KOTORAN		PIPA SPRINKLER
	PIPA AIR BERSIH		PIPA VERTIKAL SPRINKLER		SPRINKLER
	PIPA AIR KOTOR		METERAN AIR		SHAFT SPRINKLER
	PIPA KOTORAN		POMPA AIR		
	PIPA VENT		TANDON AIR		
	PIPA VERTIKAL AIR HUJAN		KATUP AIR		
	PIPA VERTIKAL AIR BERSIH		SEPTIC TANK		
	PIPA VERTIKAL AIR KOTOR		SUMUR RESAPAN		

	NAMA - NIM	MATA KULIAH	TUTOR	DOSEN
	JESSICA NATALIA 0206031910017	COMMERCIAL SPACE DESIGN	PAK FREDDY	PAK YUSUF

PRODUCED BY AN AUTODESK STUDENT VERSION


PRODUCED BY AN AUTODESK STUDENT VERSION

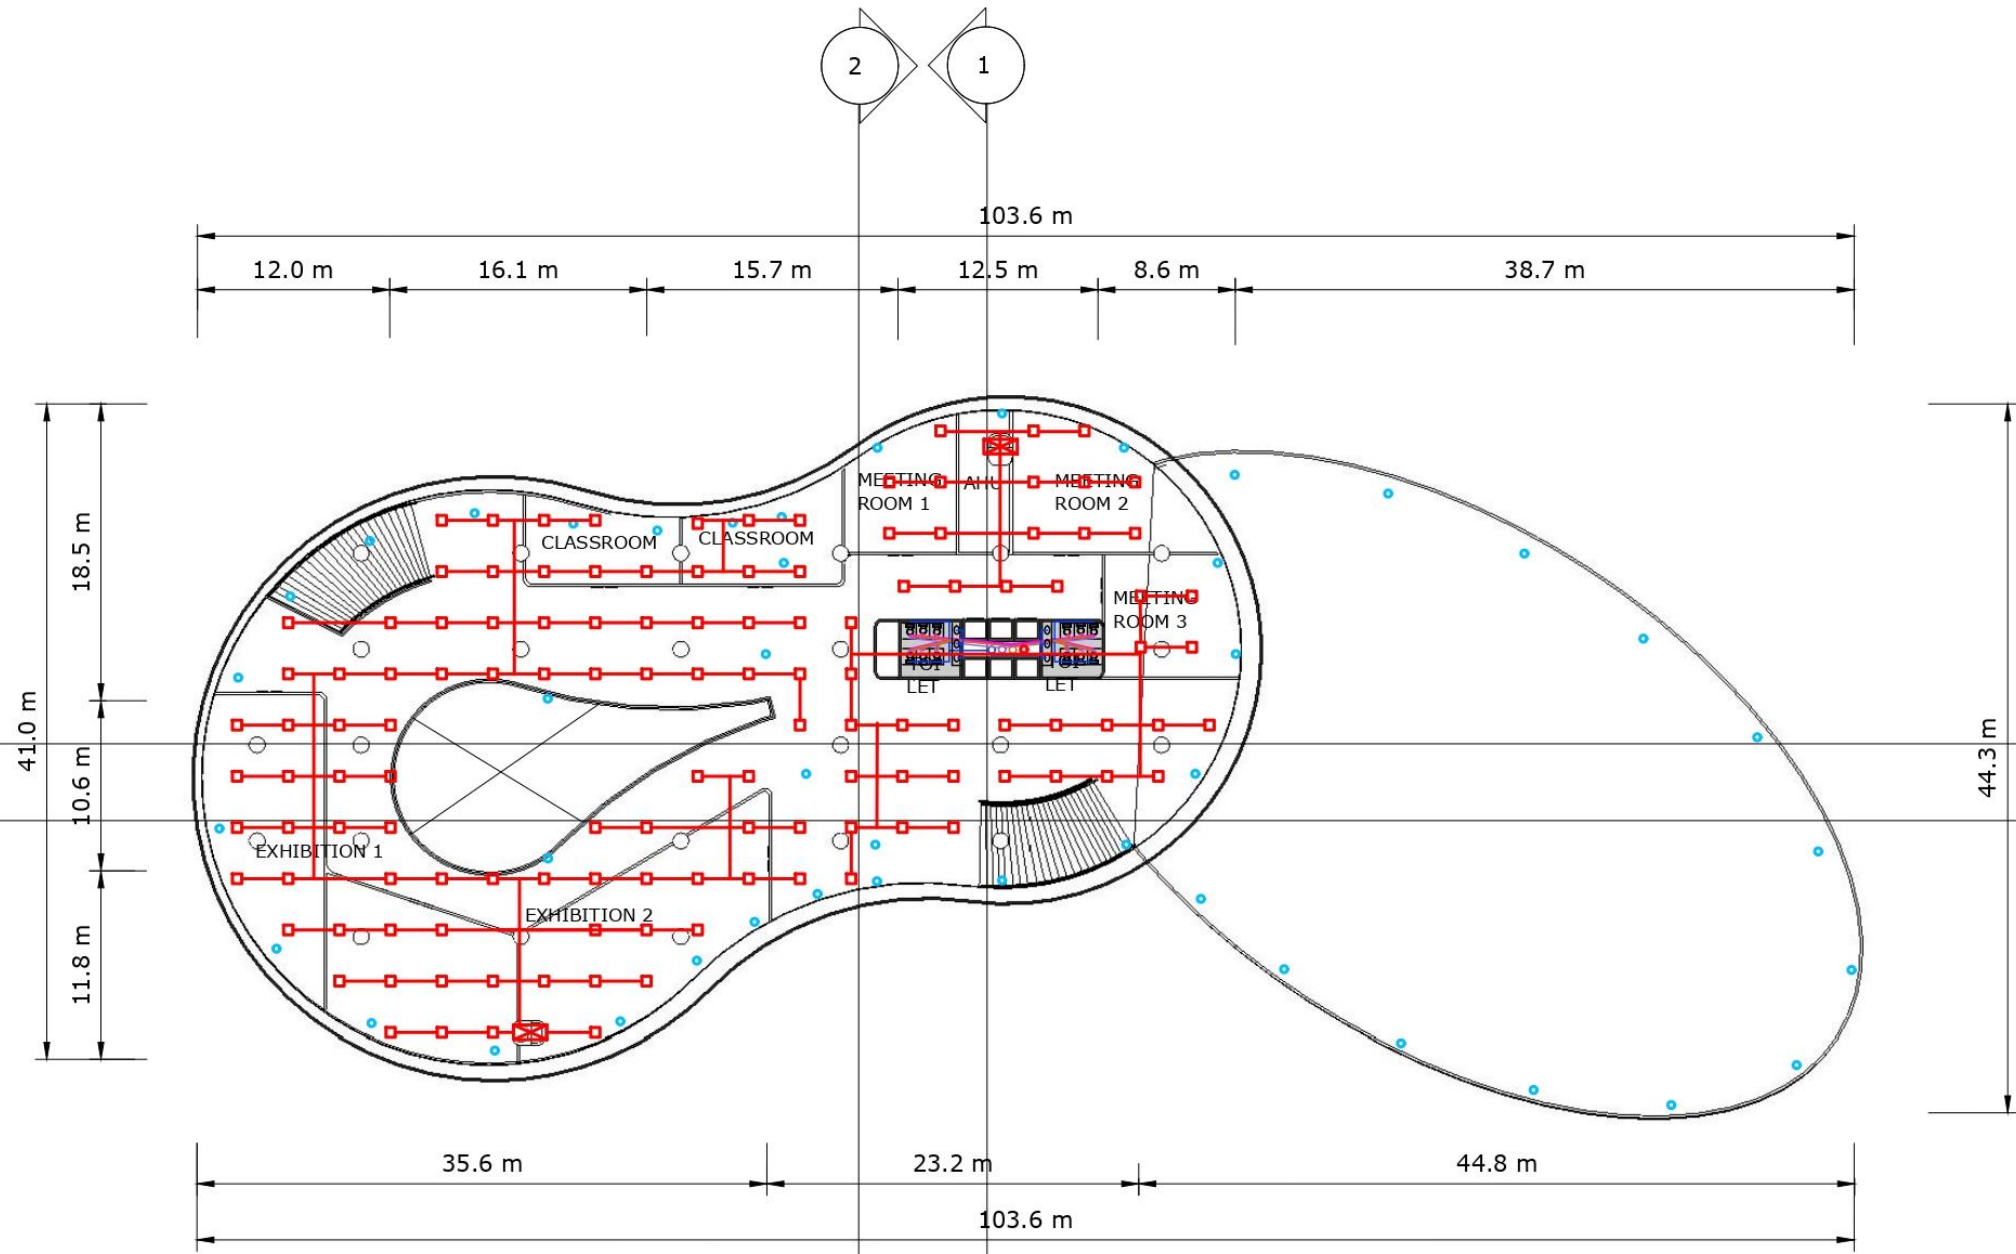

DENAH LT 3
skala 1:400


LEGENDA					
	PIPA AIR HUJAN		PIPA VERTIKAL KOTORAN		PIPA SPRINKLER
	PIPA AIR BERSIH				SPRINKLER
	PIPA AIR KOTOR				METERAN AIR
	PIPA KOTORAN				POMPA AIR
	PIPA VENT				TANDON AIR
	PIPA VERTIKAL AIR HUJAN				KATUP AIR
	PIPA VERTIKAL AIR BERSIH				SEPTIC TANK
	PIPA VERTIKAL AIR KOTOR				SUMUR RESAPAN

	NAMA - NIM	MATA KULIAH	TUTOR	DOSEN
	JESSICA NATALIA 0206031910017	COMMERCIAL SPACE DESIGN	PAK FREDDY	PAK YUSUF

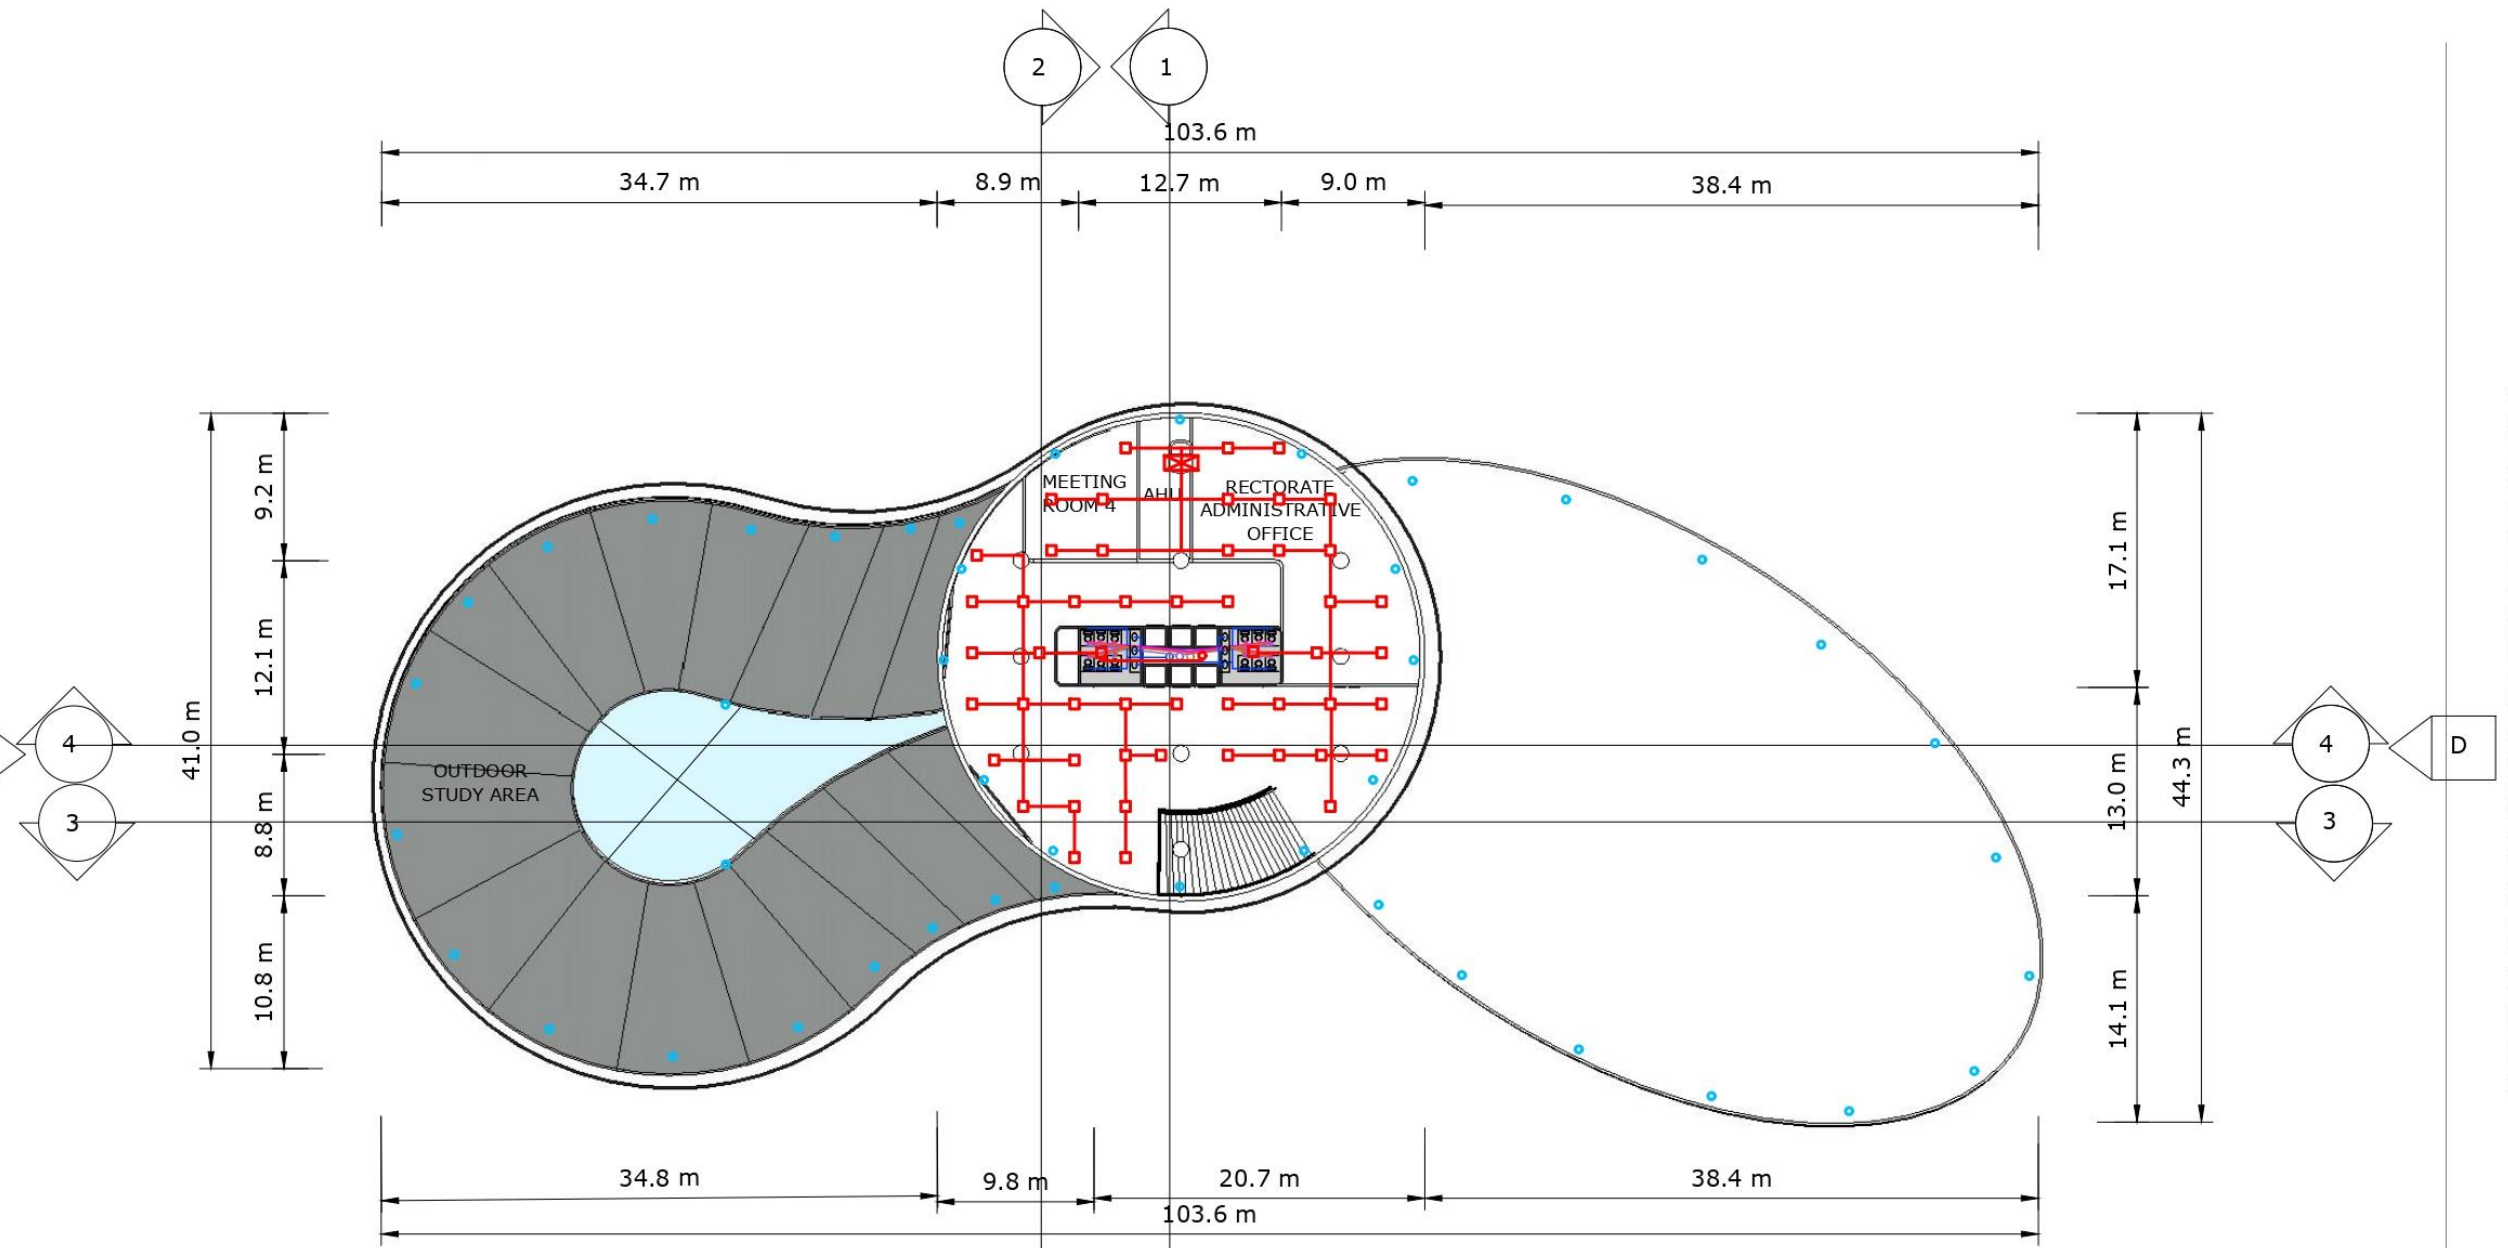


DENAH LT 4
skala 1:400

LEGENDA					
	PIPA AIR HUJAN		PIPA VERTIKAL KOTORAN		PIPA SPRINKLER
	PIPA AIR BERSIH		PIPA VERTIKAL SPRINKLER		SPRINKLER
	PIPA AIR KOTOR		METERAN AIR		
	PIPA KOTORAN		POMPA AIR		
	PIPA VENT		TANDON AIR		
	PIPA VERTIKAL AIR HUJAN		KATUP AIR		
	PIPA VERTIKAL AIR BERSIH		SEPTIC TANK		
	PIPA VERTIKAL AIR KOTOR		SUMUR RESAPAN		

	NAMA - NIM	MATA KULIAH	TUTOR	DOSEN
	JESSICA NATALIA 0206031910017	COMMERCIAL SPACE DESIGN	PAK FREDDY	PAK YUSUF


PRODUCED BY AN AUTODESK STUDENT VERSION

PRODUCED BY AN AUTODESK STUDENT VERSION

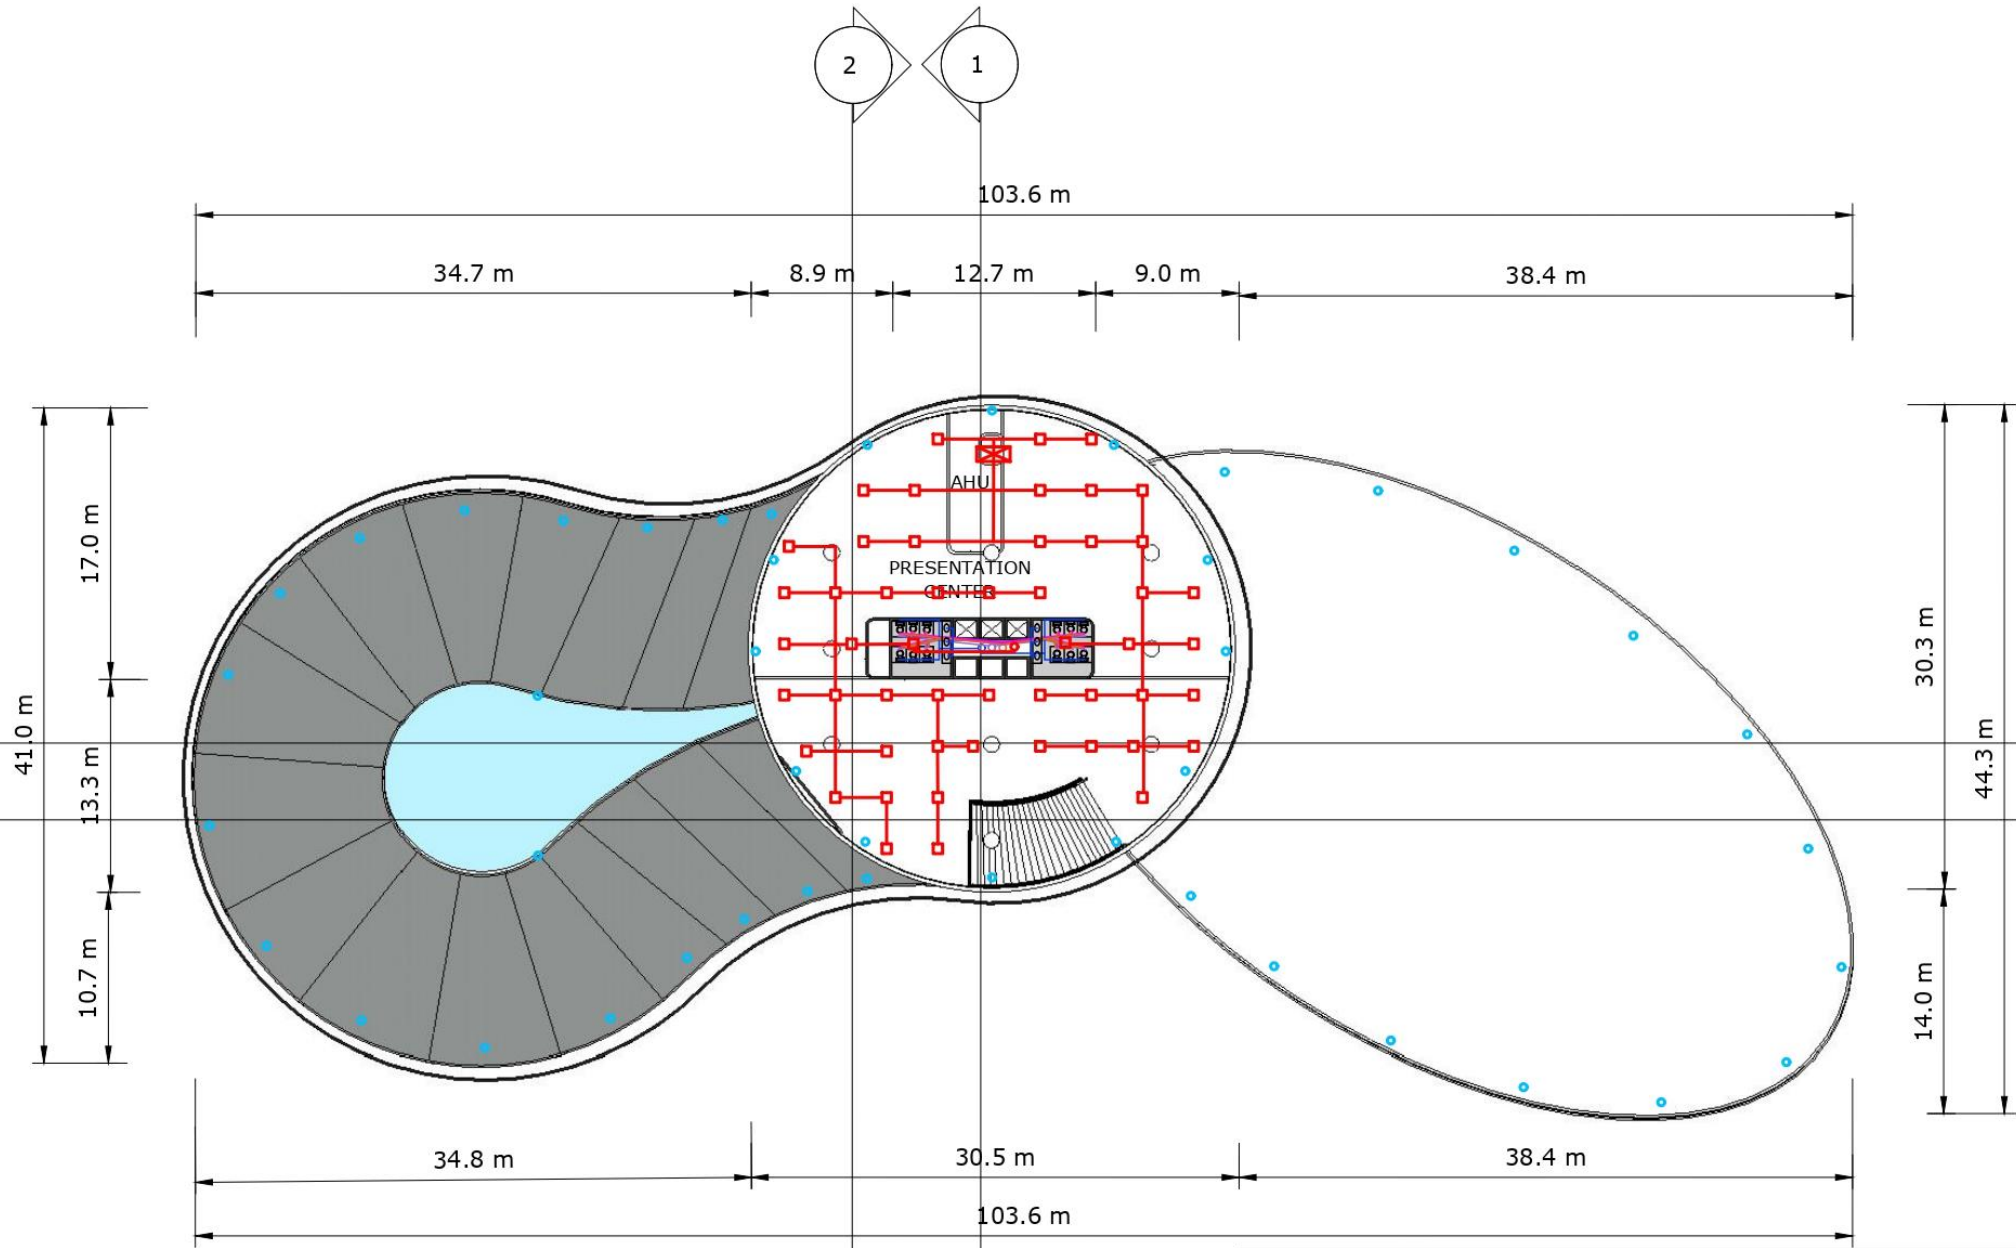


LEGENDA					
	PIPA AIR HUJAN		PIPA VERTIKAL KOTORAN		PIPA SPRINKLER
	PIPA AIR BERSIH		PIPA VERTIKAL SPRINKLER		SPRINKLER
	PIPA AIR KOTOR		METERAN AIR		
	PIPA KOTORAN		POMPA AIR		
	PIPA VENT		TANDON AIR		
	PIPA VERTIKAL AIR HUJAN		KATUP AIR		
	PIPA VERTIKAL AIR BERSIH		SEPTIC TANK		
	PIPA VERTIKAL AIR KOTOR		SUMUR RESAPAN		

DENAH LT 5
skala 1:400

	NAMA - NIM	MATA KULIAH	TUTOR	DOSEN
	JESSICA NATALIA 0206031910017	COMMERCIAL SPACE DESIGN	PAK FREDDY	PAK YUSUF

PRODUCED BY AN AUTODESK STUDENT VERSION

PRODUCED BY AN AUTODESK STUDENT VERSION

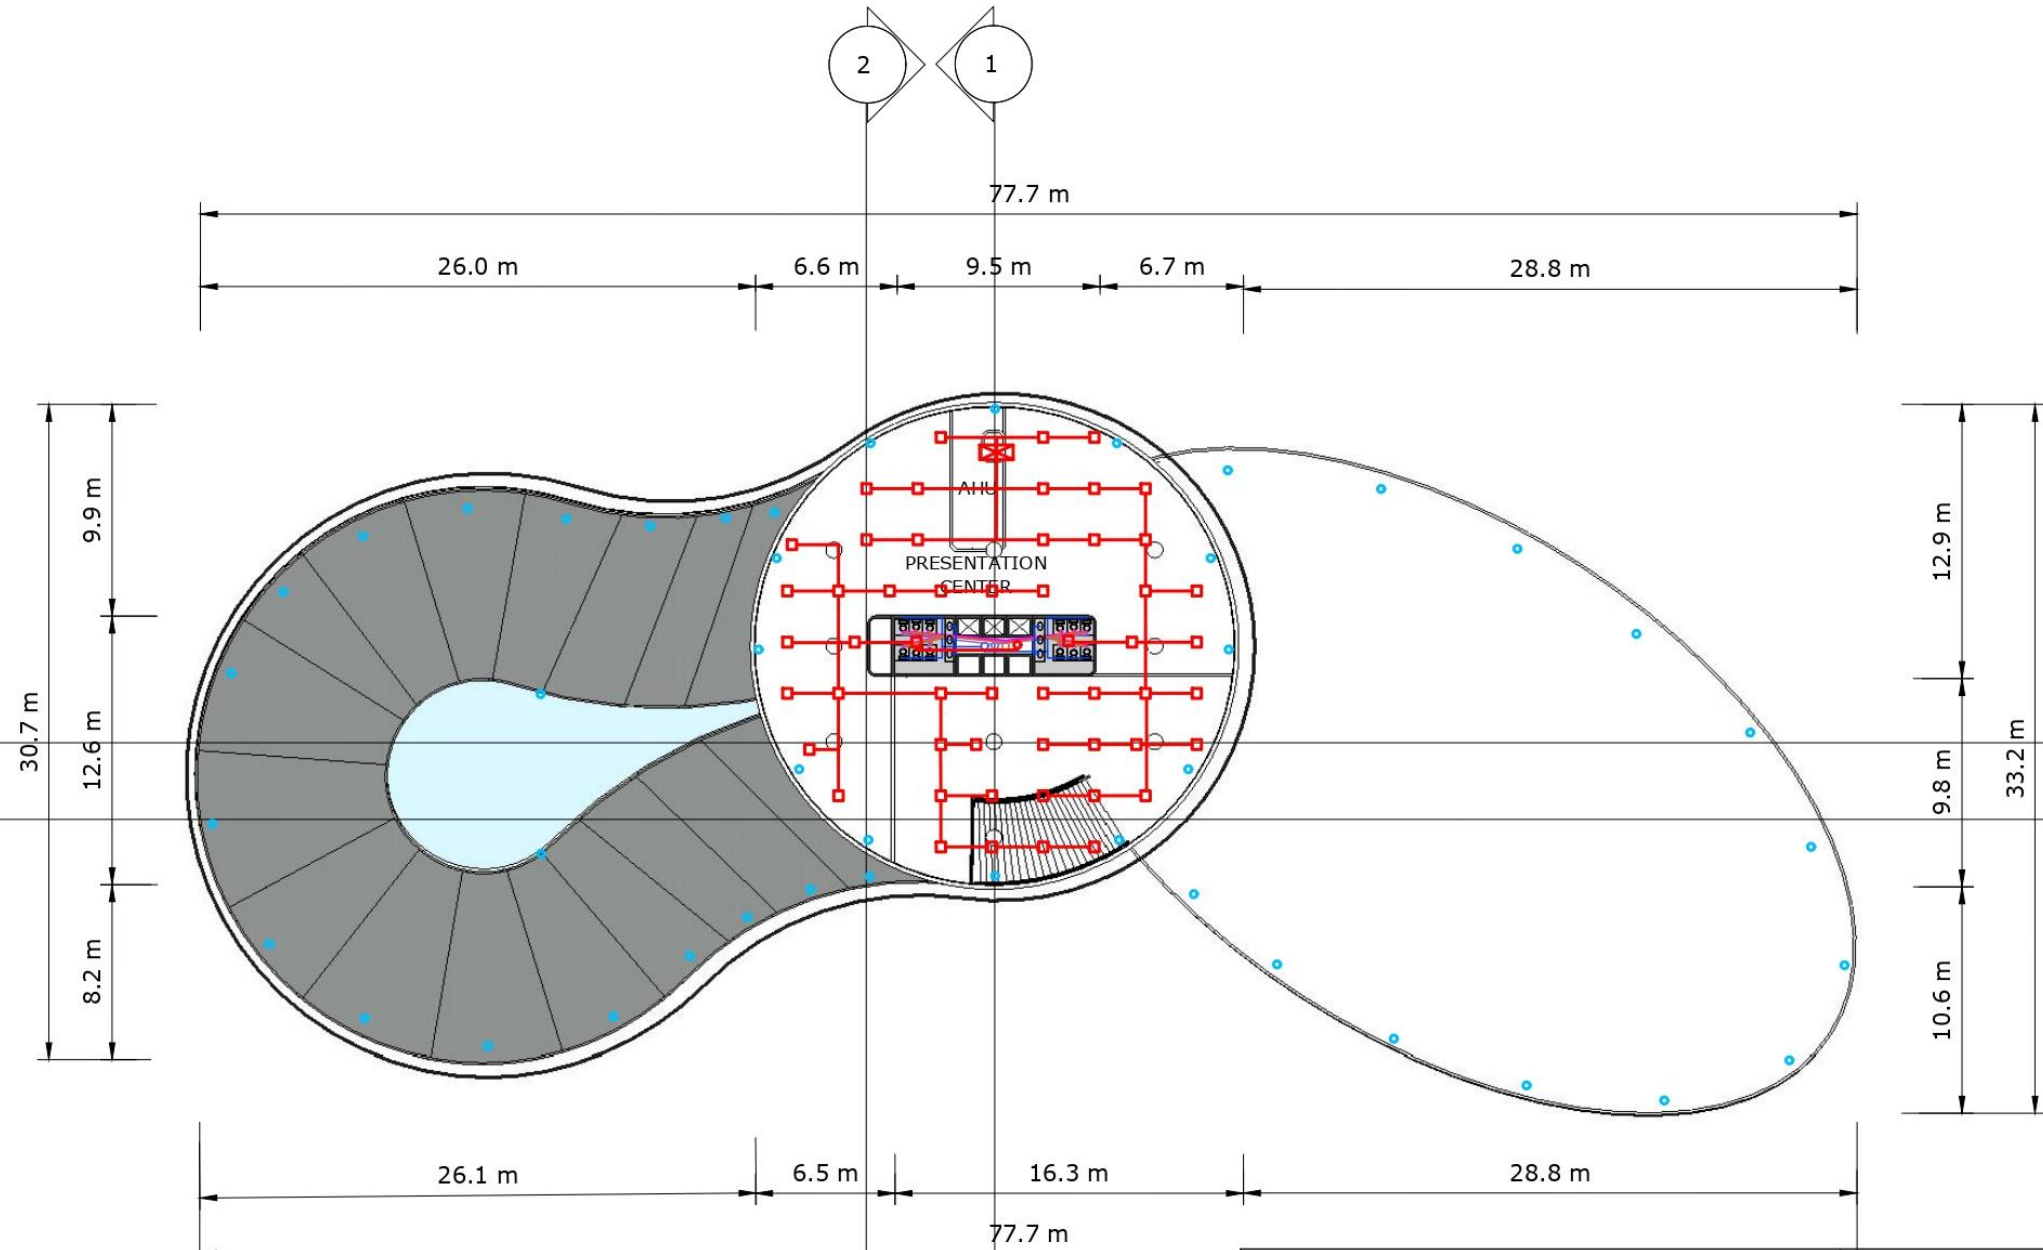

LEGENDA					
	PIPA AIR HUJAN		PIPA VERTIKAL KOTORAN		PIPA SPRINKLER
	PIPA AIR BERSIH		PIPA VERTIKAL SPRINKLER		SPRINKLER
	PIPA AIR KOTOR		METERAN AIR		
	PIPA KOTORAN		POMPA AIR		
	PIPA VENT		TANDON AIR		
	PIPA VERTIKAL AIR HUJAN		KATUP AIR		
	PIPA VERTIKAL AIR BERSIH		SEPTIC TANK		
	PIPA VERTIKAL AIR KOTOR		SUMUR RESAPAN		

DENAH LT 6
skala 1:400

	NAMA - NIM	MATA KULIAH	TUTOR	DOSEN
	JESSICA NATALIA 0206031910017	COMMERCIAL SPACE DESIGN	PAK FREDDY	PAK YUSUF




MEP

HVAC

PRODUCED BY AN AUTODESK STUDENT VERSION

PRODUCED BY AN AUTODESK STUDENT VERSION

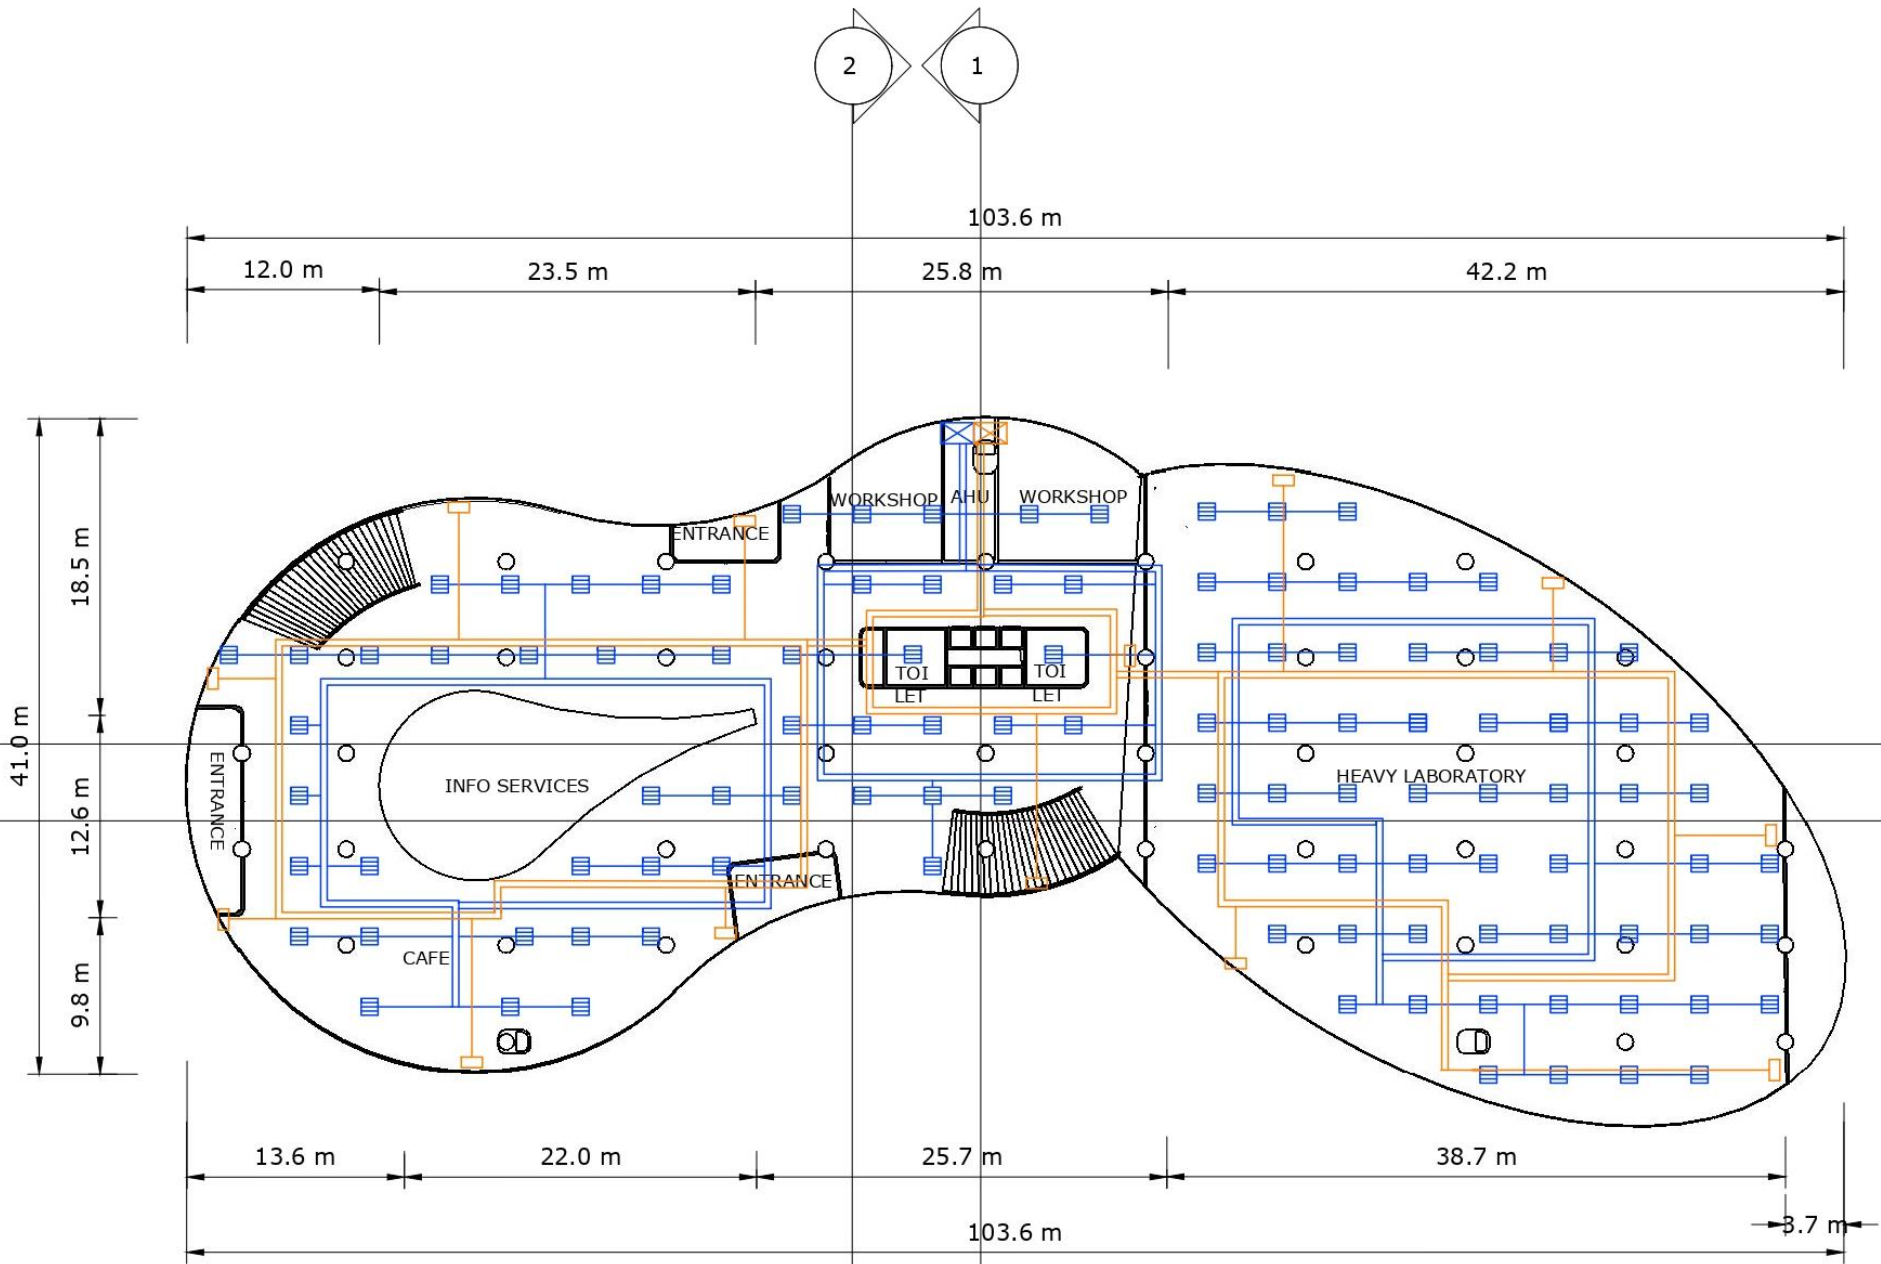


DENAH LT 1
skala 1:400

LEGENDA	
	SUPPLY AIR GRILLE
	RETURN AIR GRILLE
	PIPA SUPPLY AIR GRILLE
	PIPA RETURN AIR GRILLE
	SHAFT

	NAMA - NIM	MATA KULIAH	TUTOR	DOSEN
	JESSICA NATALIA 0206031910017	COMMERCIAL SPACE DESIGN	PAK FREDDY	PAK YUSUF

PRODUCED BY AN AUTODESK STUDENT VERSION

PRODUCED BY AN AUTODESK STUDENT VERSION

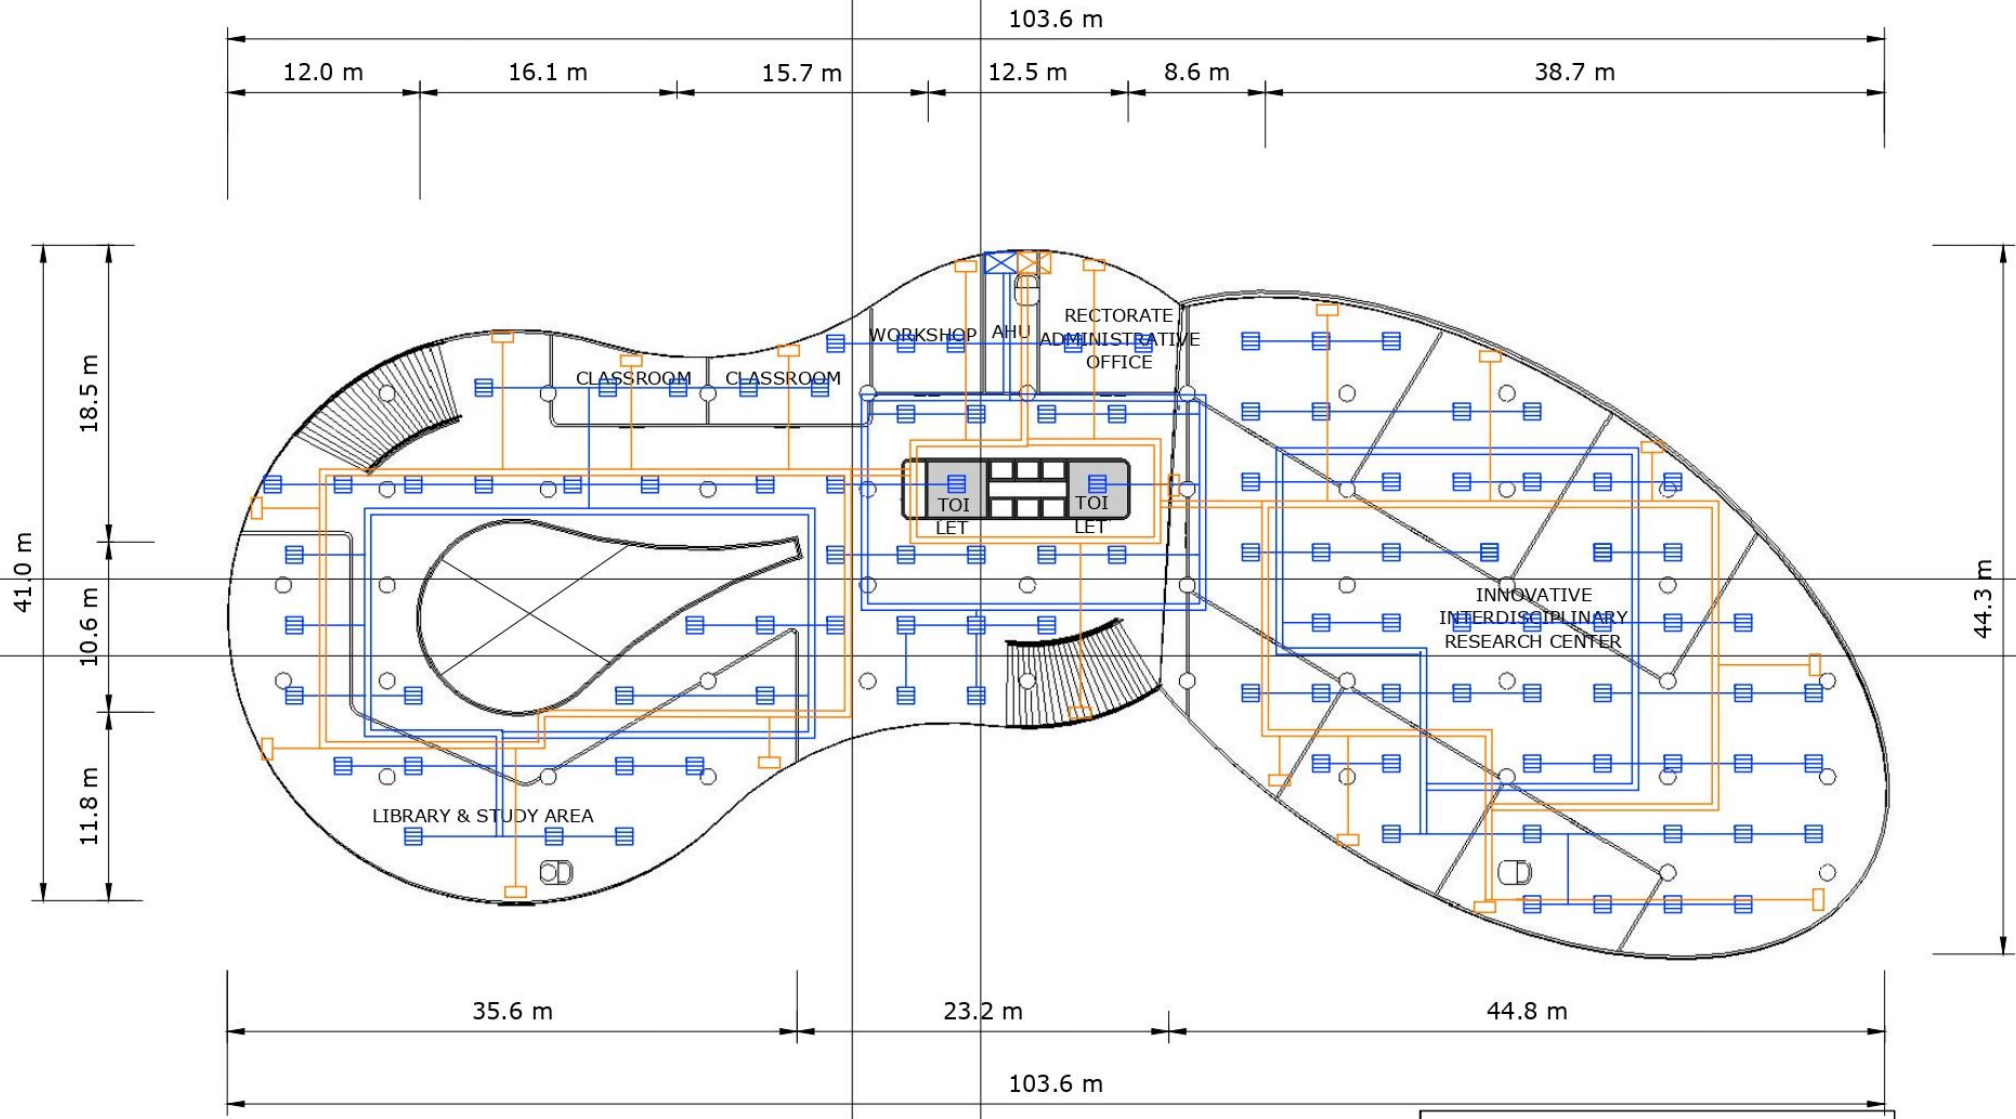


LEGENDA	
	SUPPLY AIR GRILLE
	RETURN AIR GRILLE
	PIPA SUPPLY AIR GRILLE
	PIPA RETURN AIR GRILLE
	SHAFT

DENAH LT 2
skala 1:400

	NAMA - NIM	MATA KULIAH	TUTOR	DOSEN
	JESSICA NATALIA 0206031910017	COMMERCIAL SPACE DESIGN	PAK FREDDY	PAK YUSUF

PRODUCED BY AN AUTODESK STUDENT VERSION

PRODUCED BY AN AUTODESK STUDENT VERSION

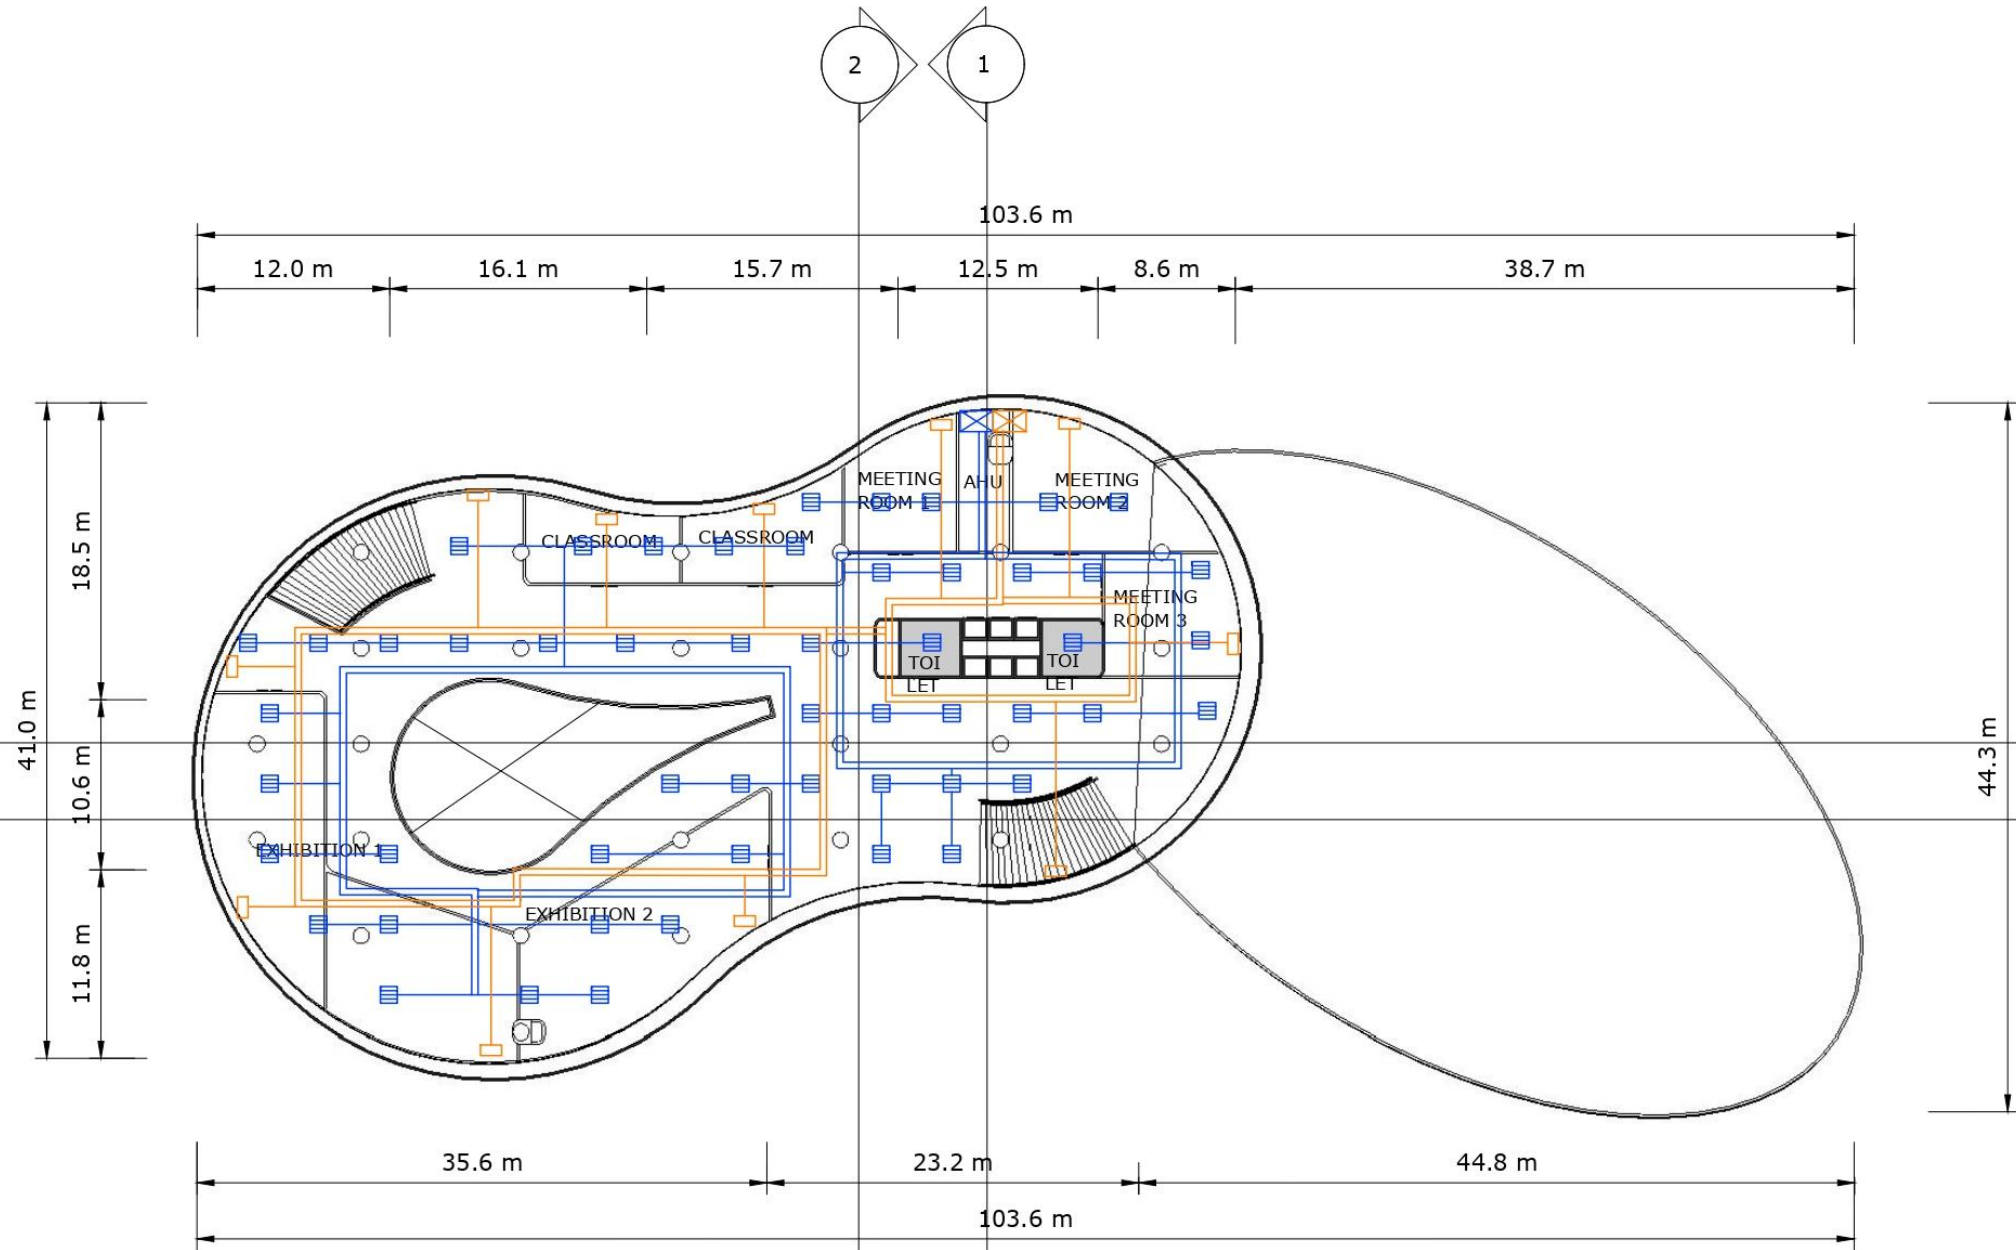


LEGENDA	
	SUPPLY AIR GRILLE
	RETURN AIR GRILLE
	PIPA SUPPLY AIR GRILLE
	PIPA RETURN AIR GRILLE
	SHAFT

DENAH LT 3
skala 1:400

	NAMA - NIM	MATA KULIAH	TUTOR	DOSEN
	JESSICA NATALIA 0206031910017	COMMERCIAL SPACE DESIGN	PAK FREDDY	PAK YUSUF

PRODUCED BY AN AUTODESK STUDENT VERSION


PRODUCED BY AN AUTODESK STUDENT VERSION

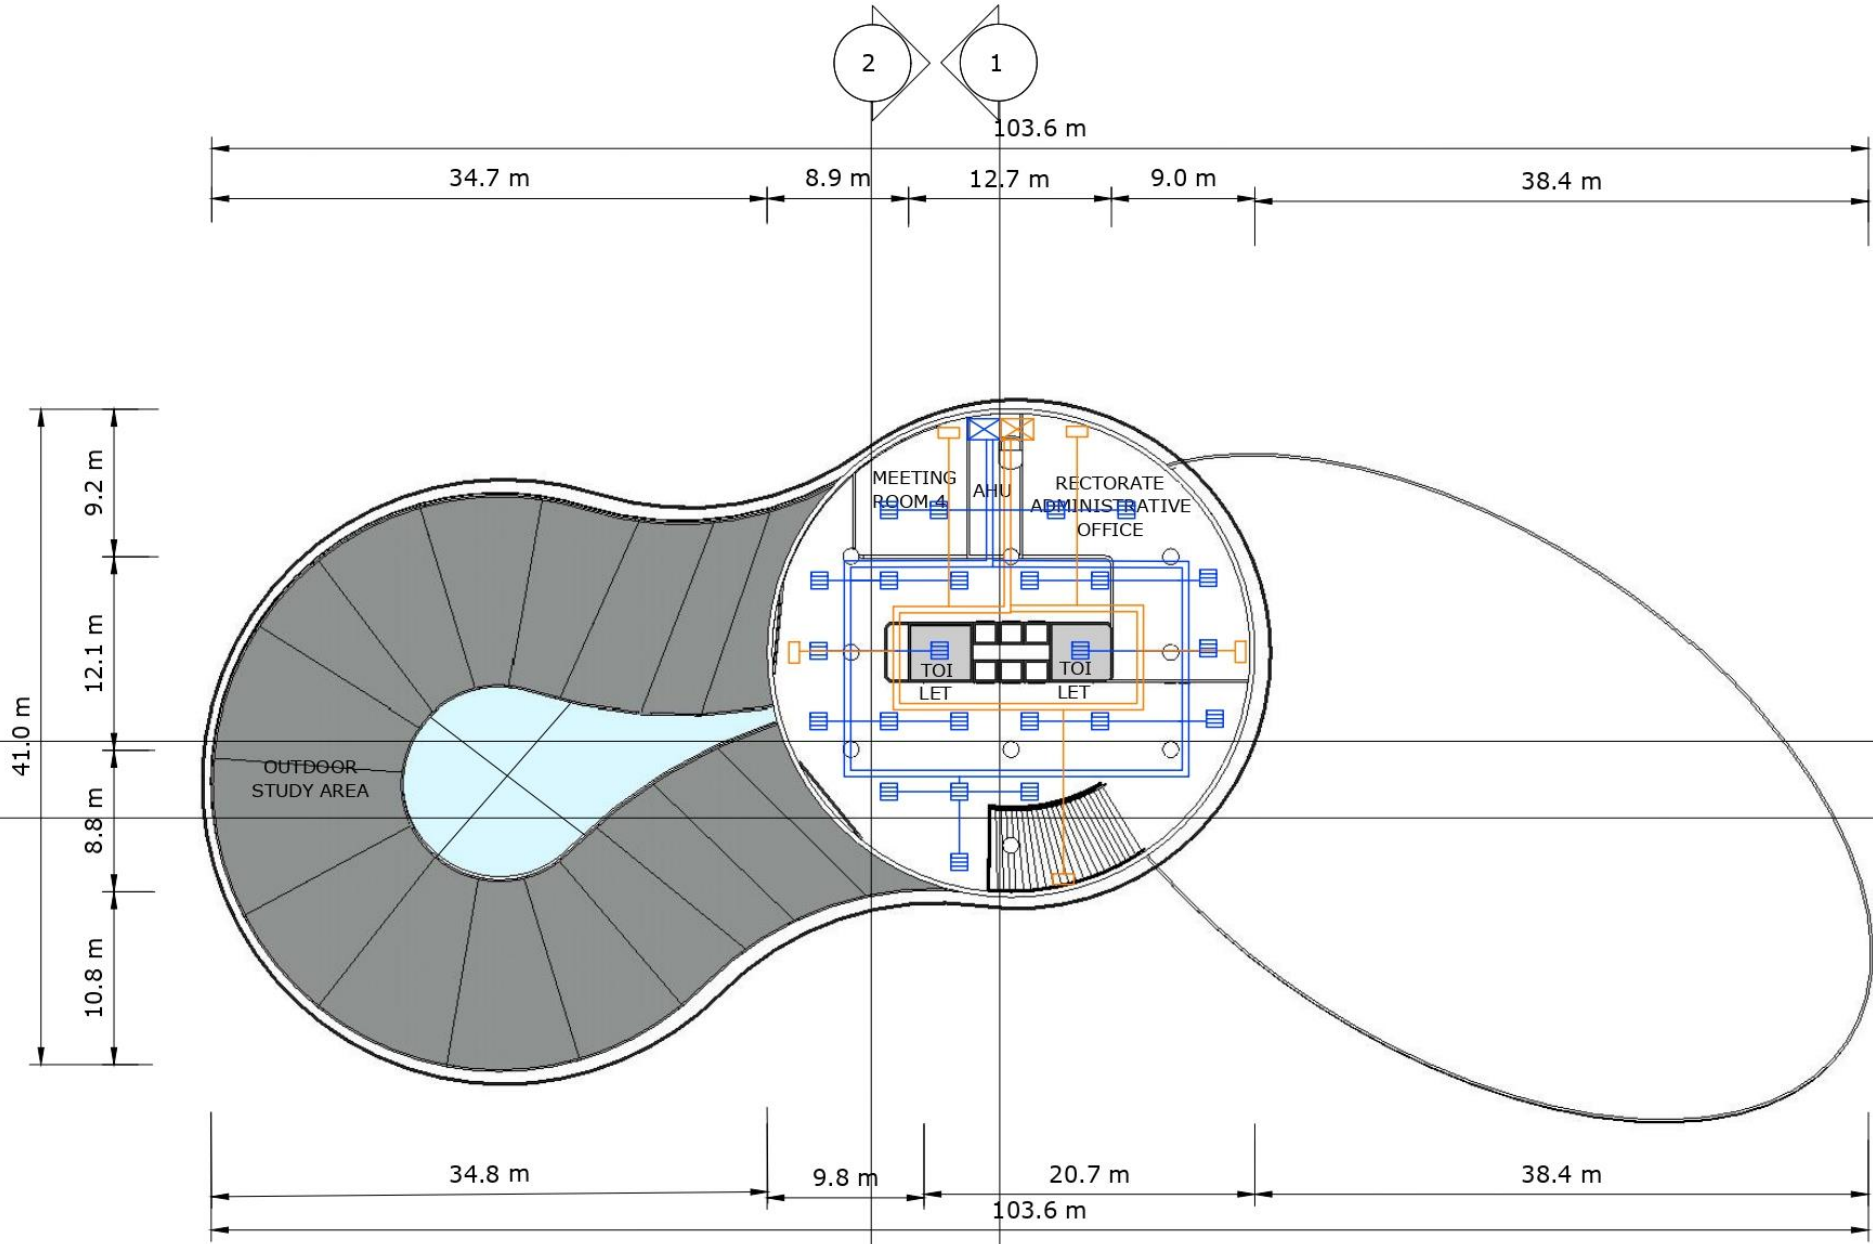

DENAH LT 4
skala 1:400


LEGENDA	
	SUPPLY AIR GRILLE
	RETURN AIR GRILLE
	PIPA SUPPLY AIR GRILLE
	PIPA RETURN AIR GRILLE
	SHAFT

PRODUCED BY AN AUTODESK STUDENT VERSION

	NAMA - NIM	MATA KULIAH	TUTOR	DOSEN
	JESSICA NATALIA 0206031910017	COMMERCIAL SPACE DESIGN	PAK FREDDY	PAK YUSUF

PRODUCED BY AN AUTODESK STUDENT VERSION

PRODUCED BY AN AUTODESK STUDENT VERSION

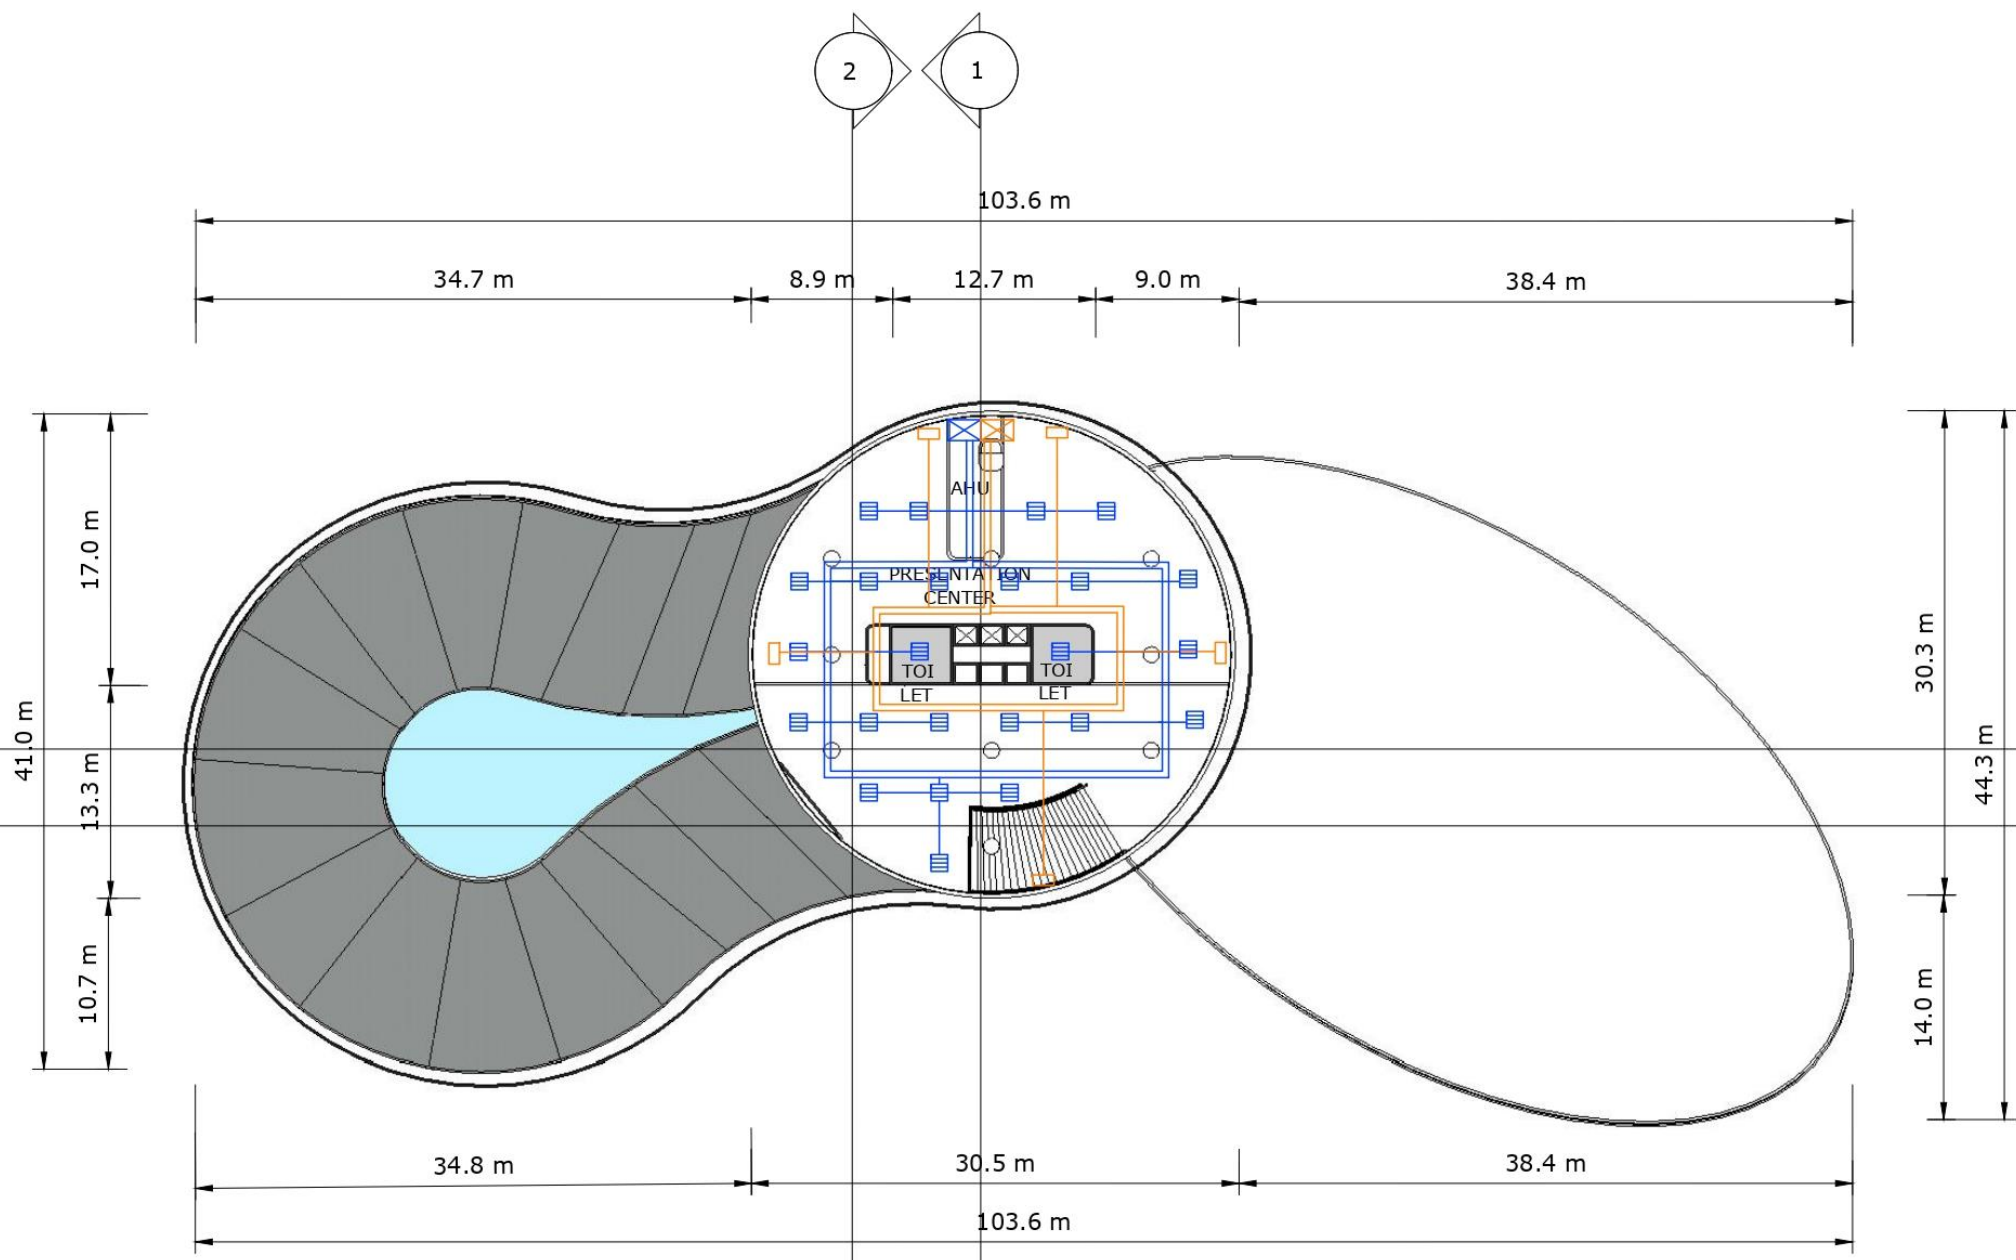


LEGENDA	
	SUPPLY AIR GRILLE
	RETURN AIR GRILLE
	PIPA SUPPLY AIR GRILLE
	PIPA RETURN AIR GRILLE
	SHAFT

DENAH LT 5
skala 1:400

	NAMA - NIM	MATA KULIAH	TUTOR	DOSEN
	JESSICA NATALIA 0206031910017	COMMERCIAL SPACE DESIGN	PAK FREDDY	PAK YUSUF

PRODUCED BY AN AUTODESK STUDENT VERSION

PRODUCED BY AN AUTODESK STUDENT VERSION

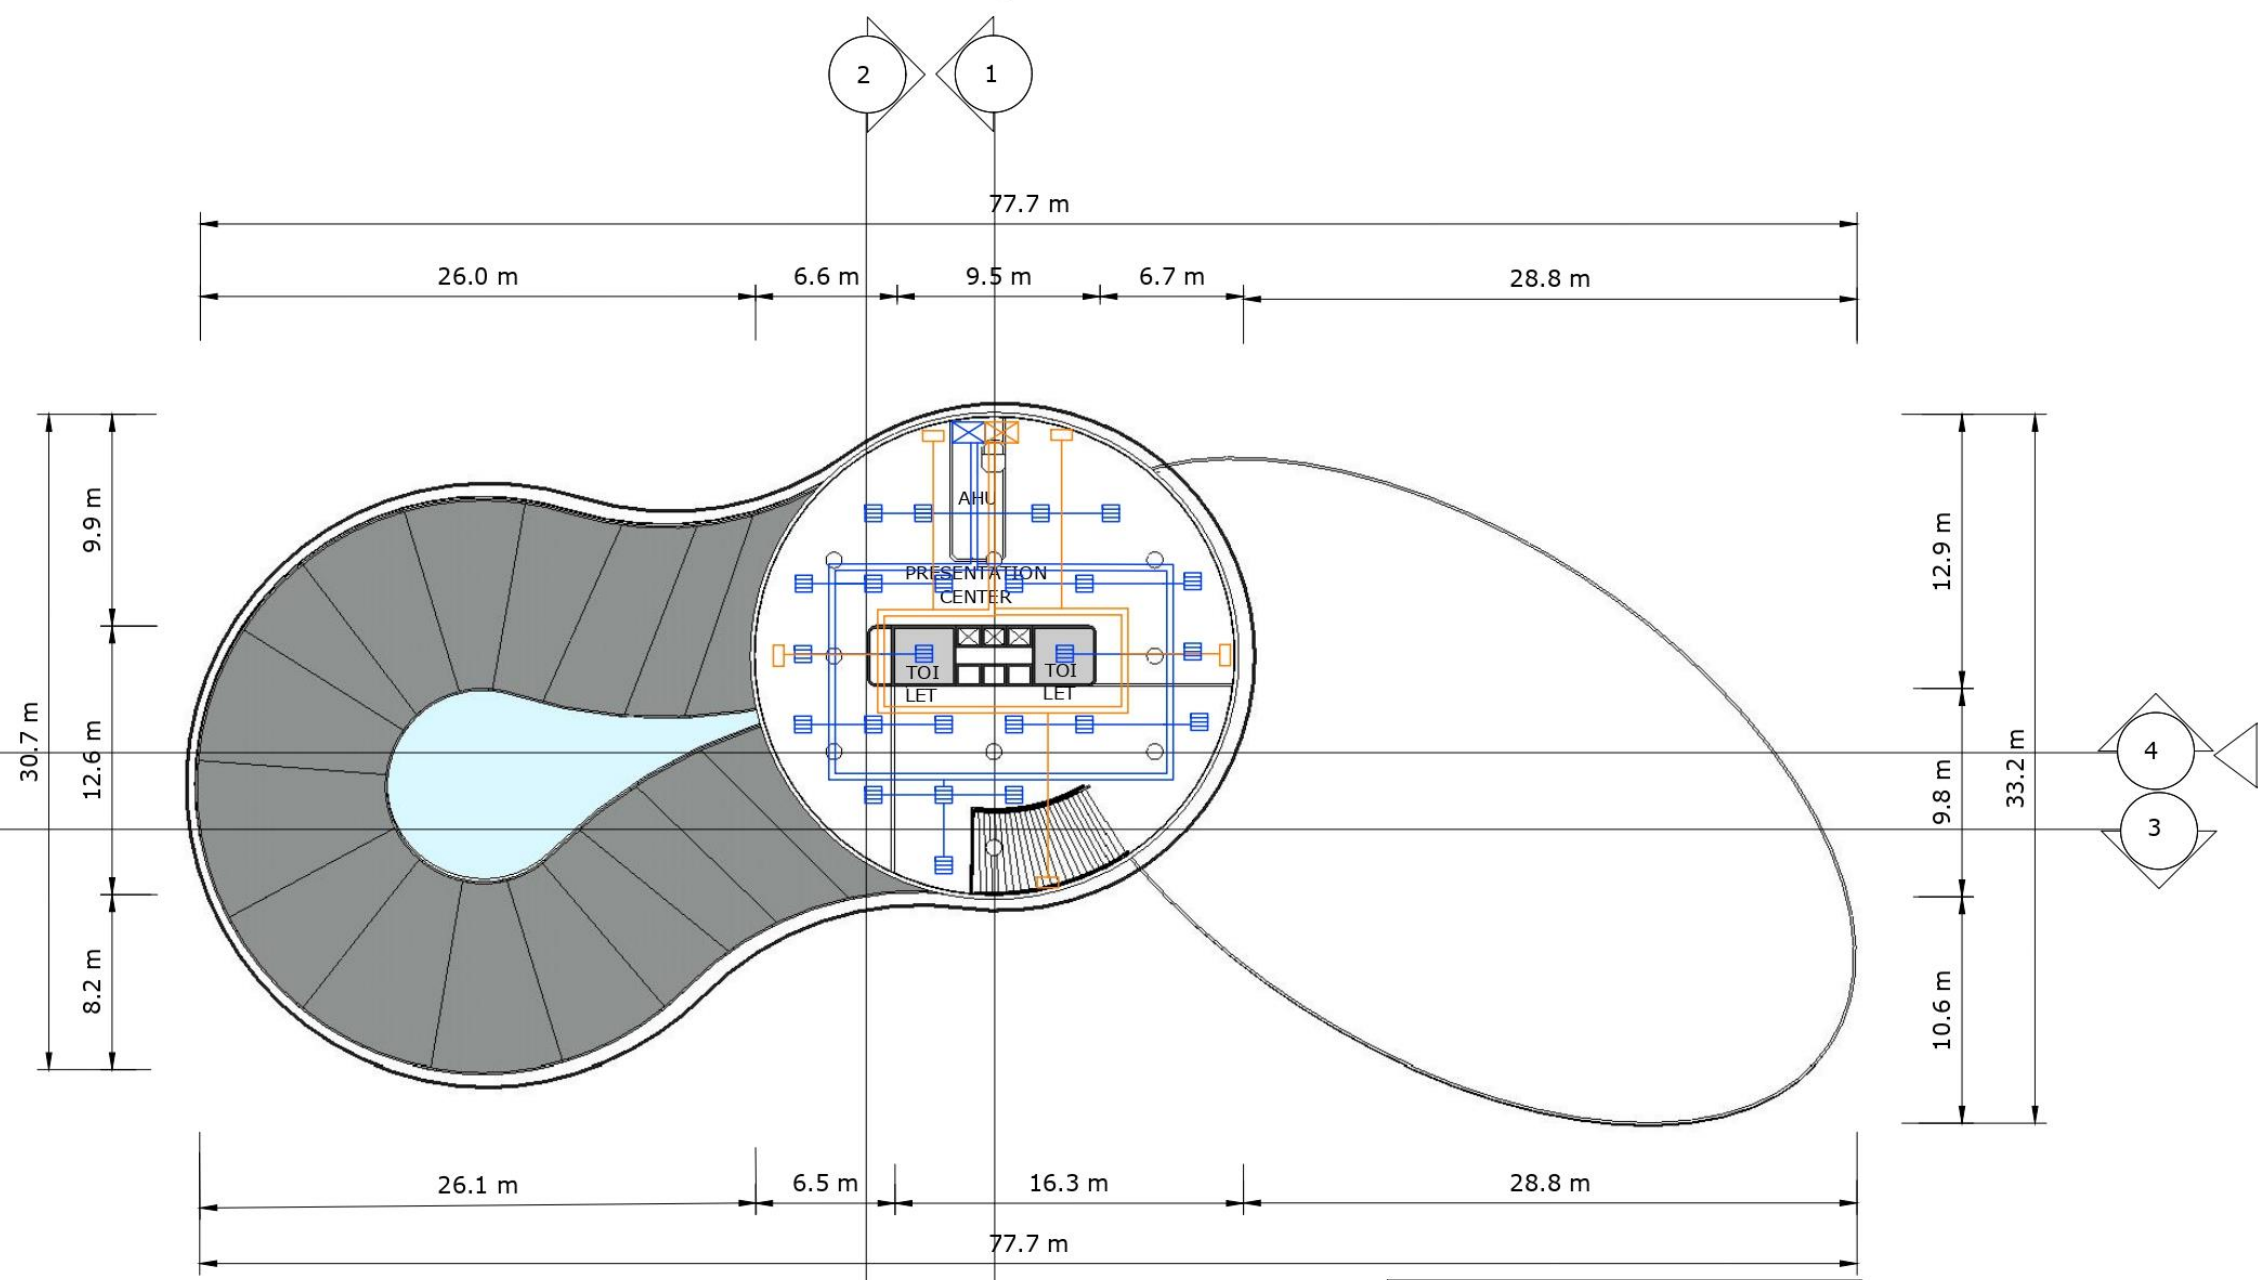

LEGENDA	
	SUPPLY AIR GRILLE
	RETURN AIR GRILLE
	PIPA SUPPLY AIR GRILLE
	PIPA RETURN AIR GRILLE
	SHAFT

DENAH LT 6
skala 1:400

	NAMA - NIM	MATA KULIAH	TUTOR	DOSEN
	JESSICA NATALIA 0206031910017	COMMERCIAL SPACE DESIGN	PAK FREDDY	PAK YUSUF




MEP

ELECTRICAL

PRODUCED BY AN AUTODESK STUDENT VERSION

PRODUCED BY AN AUTODESK STUDENT VERSION

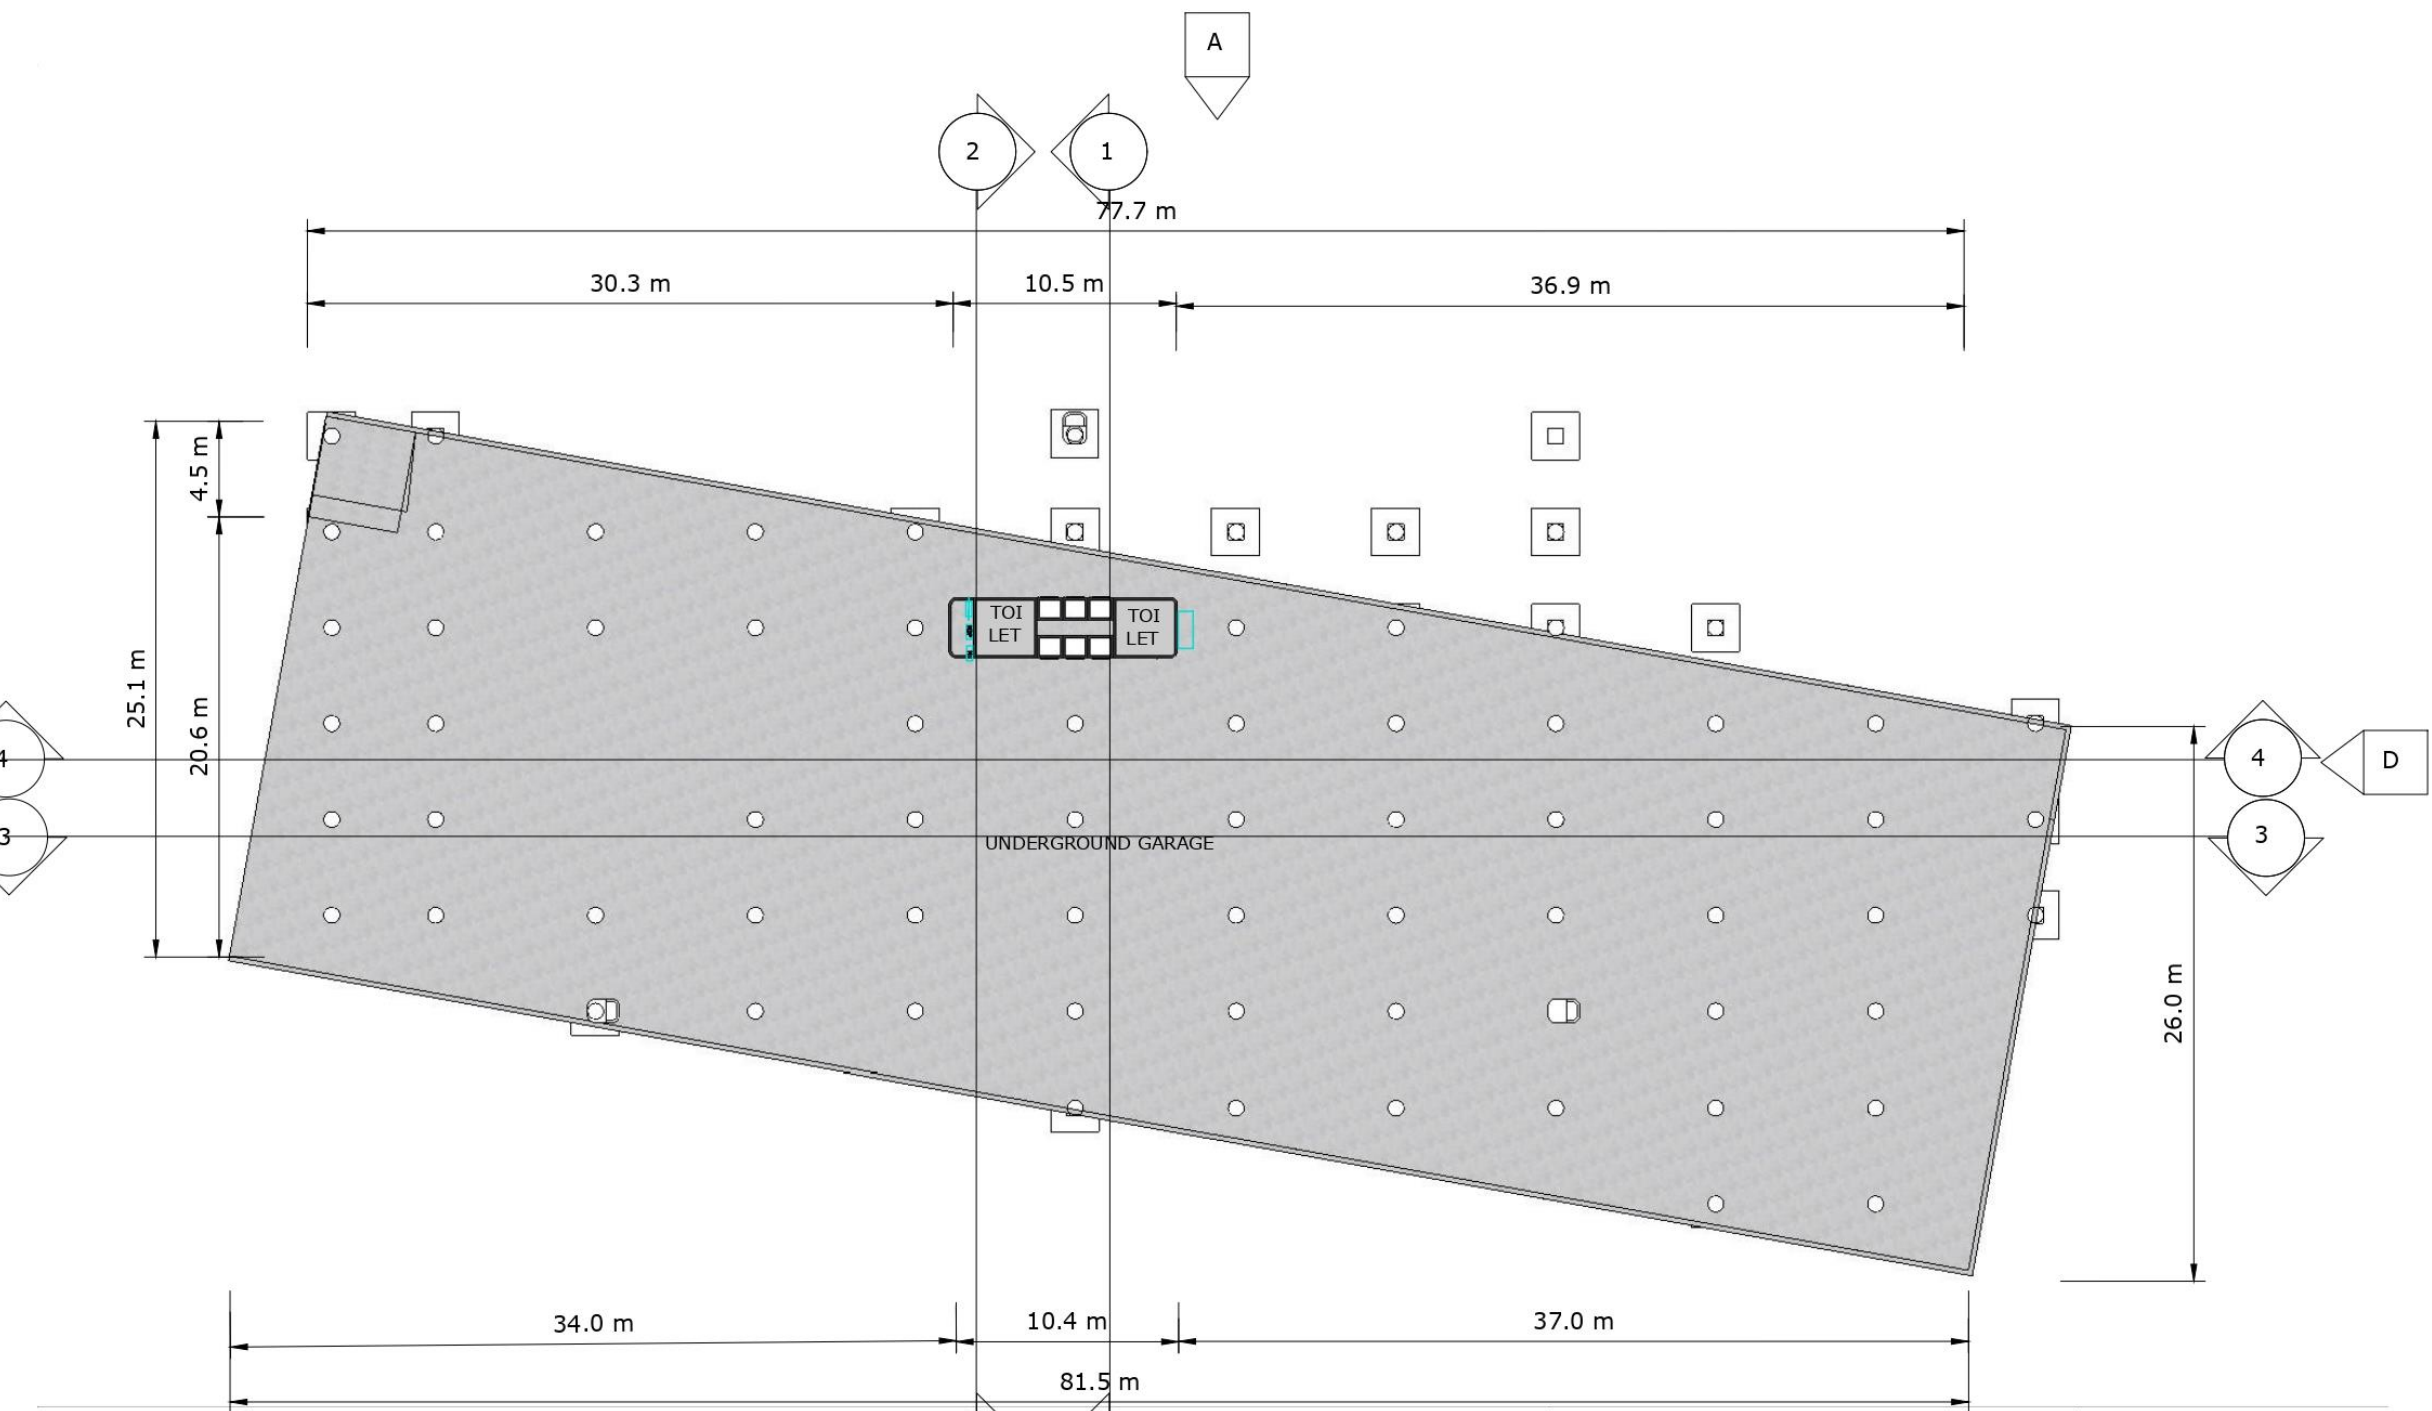

DENAH BASEMENT
skala 1:400


LEGENDA	
	STOPKONTAK
	PANEL SEKRING RUANG
	PANEL SEKRING LANTAI
	MATI PANEL

PRODUCED BY AN AUTODESK STUDENT VERSION

	NAMA - NIM	MATA KULIAH	TUTOR	DOSEN
	JESSICA NATALIA 0206031910017	COMMERCIAL SPACE DESIGN	PAK FREDDY	PAK YUSUF

PRODUCED BY AN AUTODESK STUDENT VERSION

PRODUCED BY AN AUTODESK STUDENT VERSION

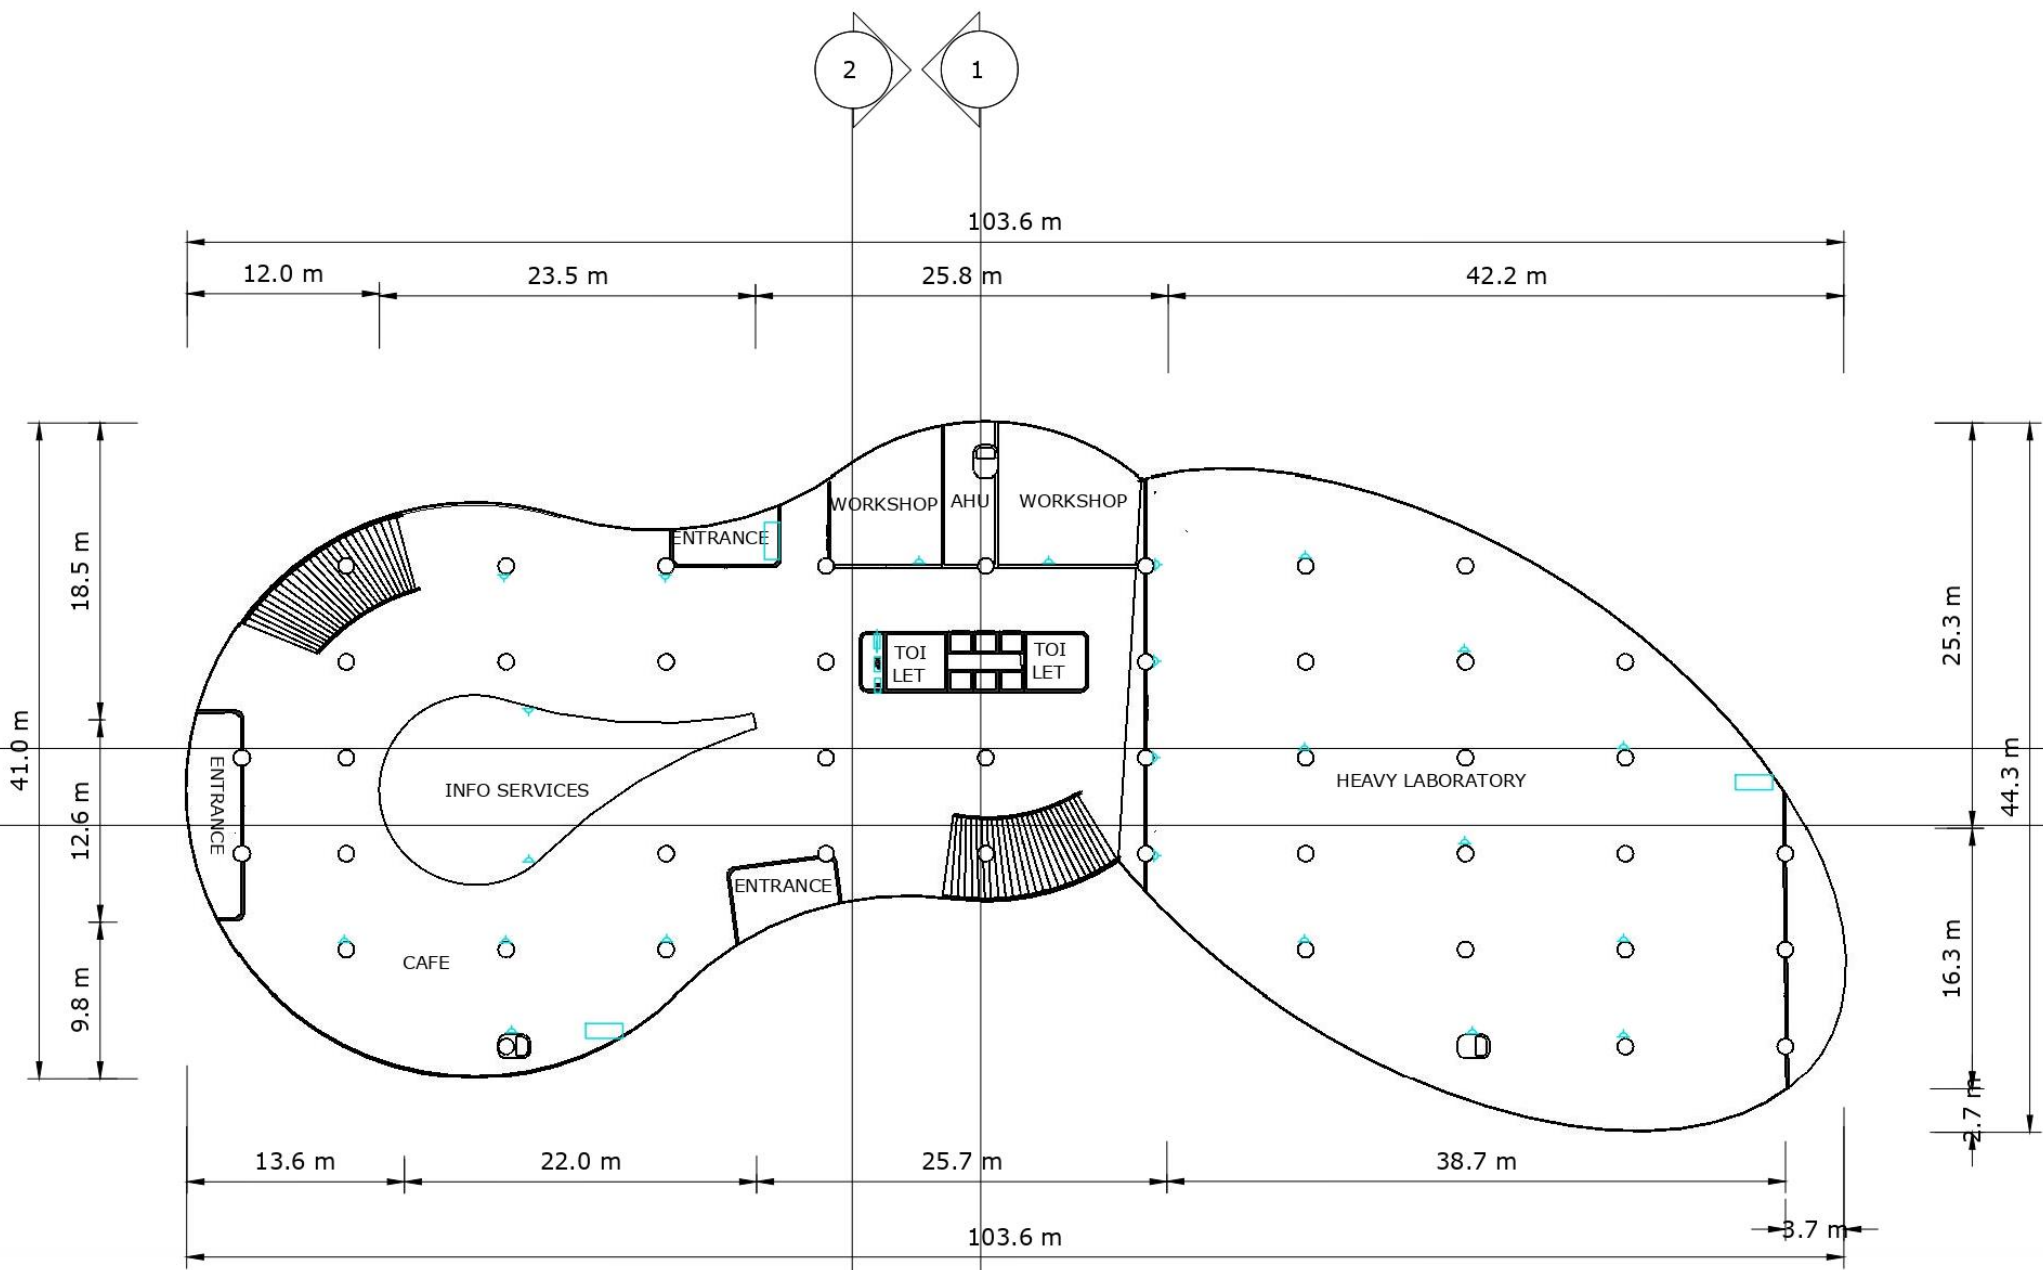


DENAH LT 1
skala 1:400

LEGENDA	
	STOPKONTAK
	PANEL SEKRING RUANG
	PANEL SEKRING LANTAI
	MAIN PANEL
	METER LISTRIK

	NAMA - NIM	MATA KULIAH	TUTOR	DOSEN
	JESSICA NATALIA 0206031910017	COMMERCIAL SPACE DESIGN	PAK FREDDY	PAK YUSUF

PRODUCED BY AN AUTODESK STUDENT VERSION

PRODUCED BY AN AUTODESK STUDENT VERSION

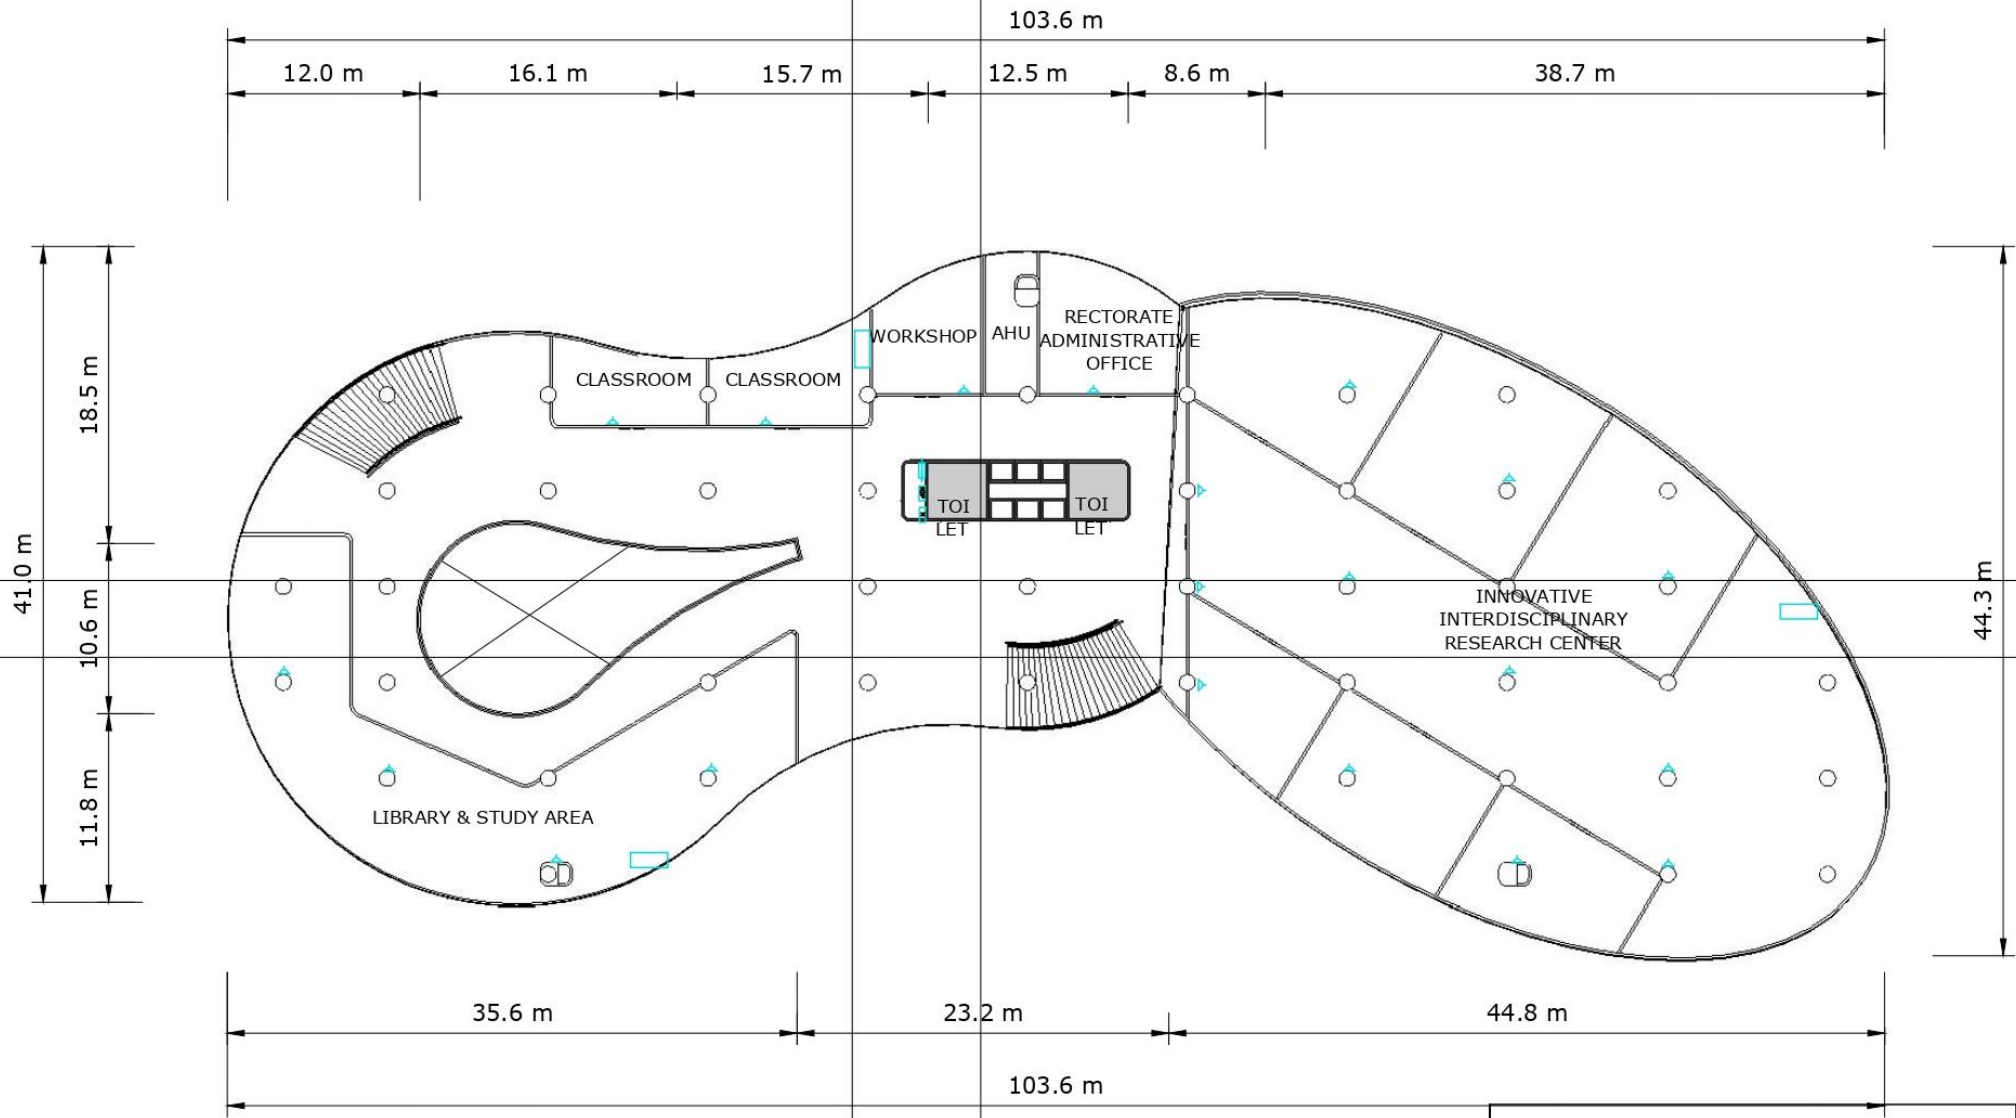


LEGENDA	
	STOPKONTAK
	PANEL SEKRING RUANG
	PANEL SEKRING LANTAI
	MAIN PANEL
	METER LISTRIK

DENAH LT 2
skala 1:400

	NAMA - NIM	MATA KULIAH	TUTOR	DOSEN
	JESSICA NATALIA 0206031910017	COMMERCIAL SPACE DESIGN	PAK FREDDY	PAK YUSUF


PRODUCED BY AN AUTODESK STUDENT VERSION

PRODUCED BY AN AUTODESK STUDENT VERSION

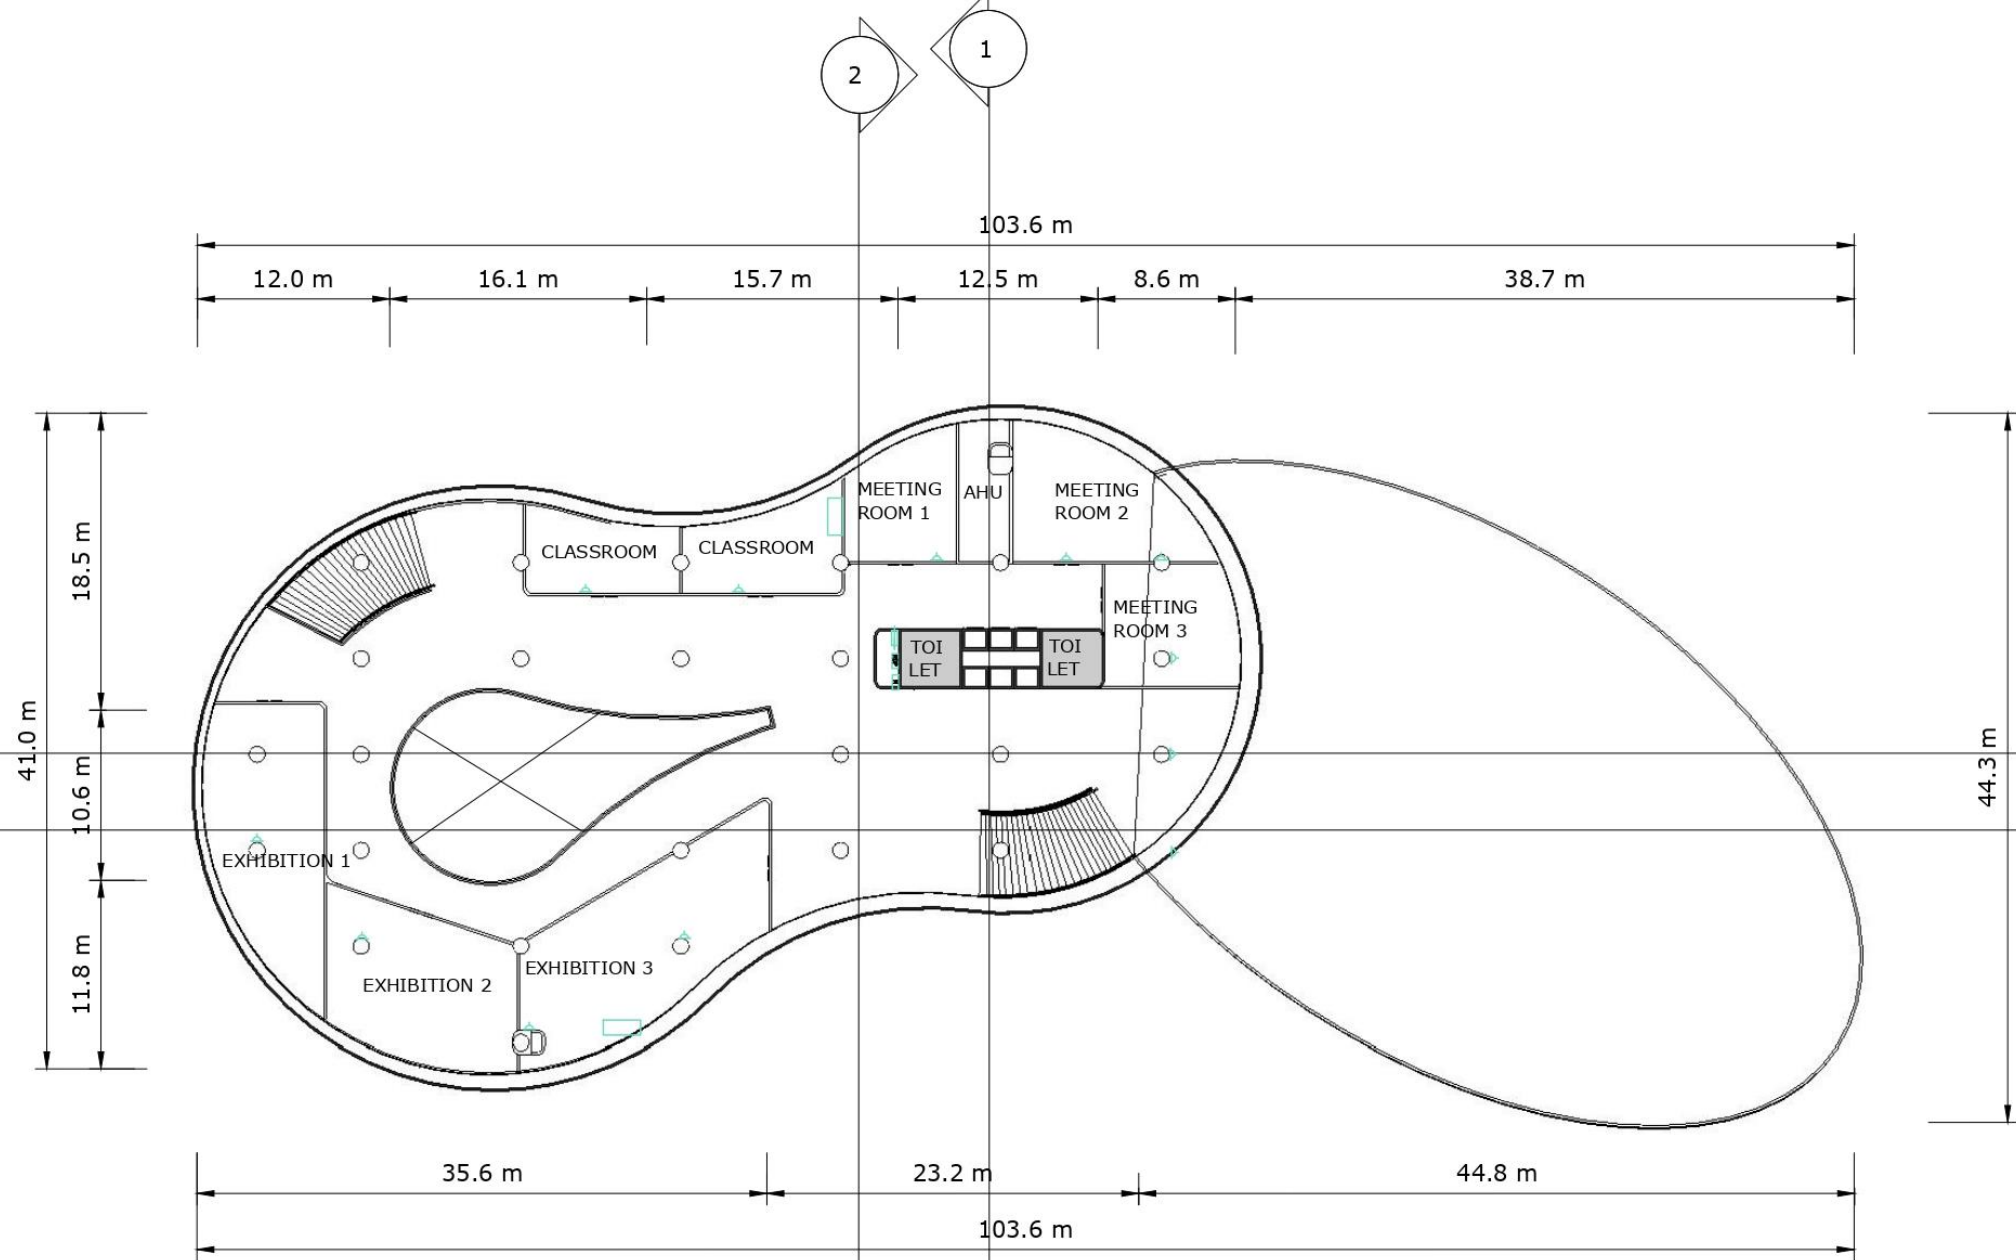


LEGENDA	
	STOPKONTAK
	PANEL SEKRING RUANG
	PANEL SEKRING LANTAI
	MAIN PANEL
	METER LISTRIK

DENAH LT 3
skala 1:400

	NAMA - NIM	MATA KULIAH	TUTOR	DOSEN
	JESSICA NATALIA 0206031910017	COMMERCIAL SPACE DESIGN	PAK FREDDY	PAK YUSUF

PRODUCED BY AN AUTODESK STUDENT VERSION


PRODUCED BY AN AUTODESK STUDENT VERSION

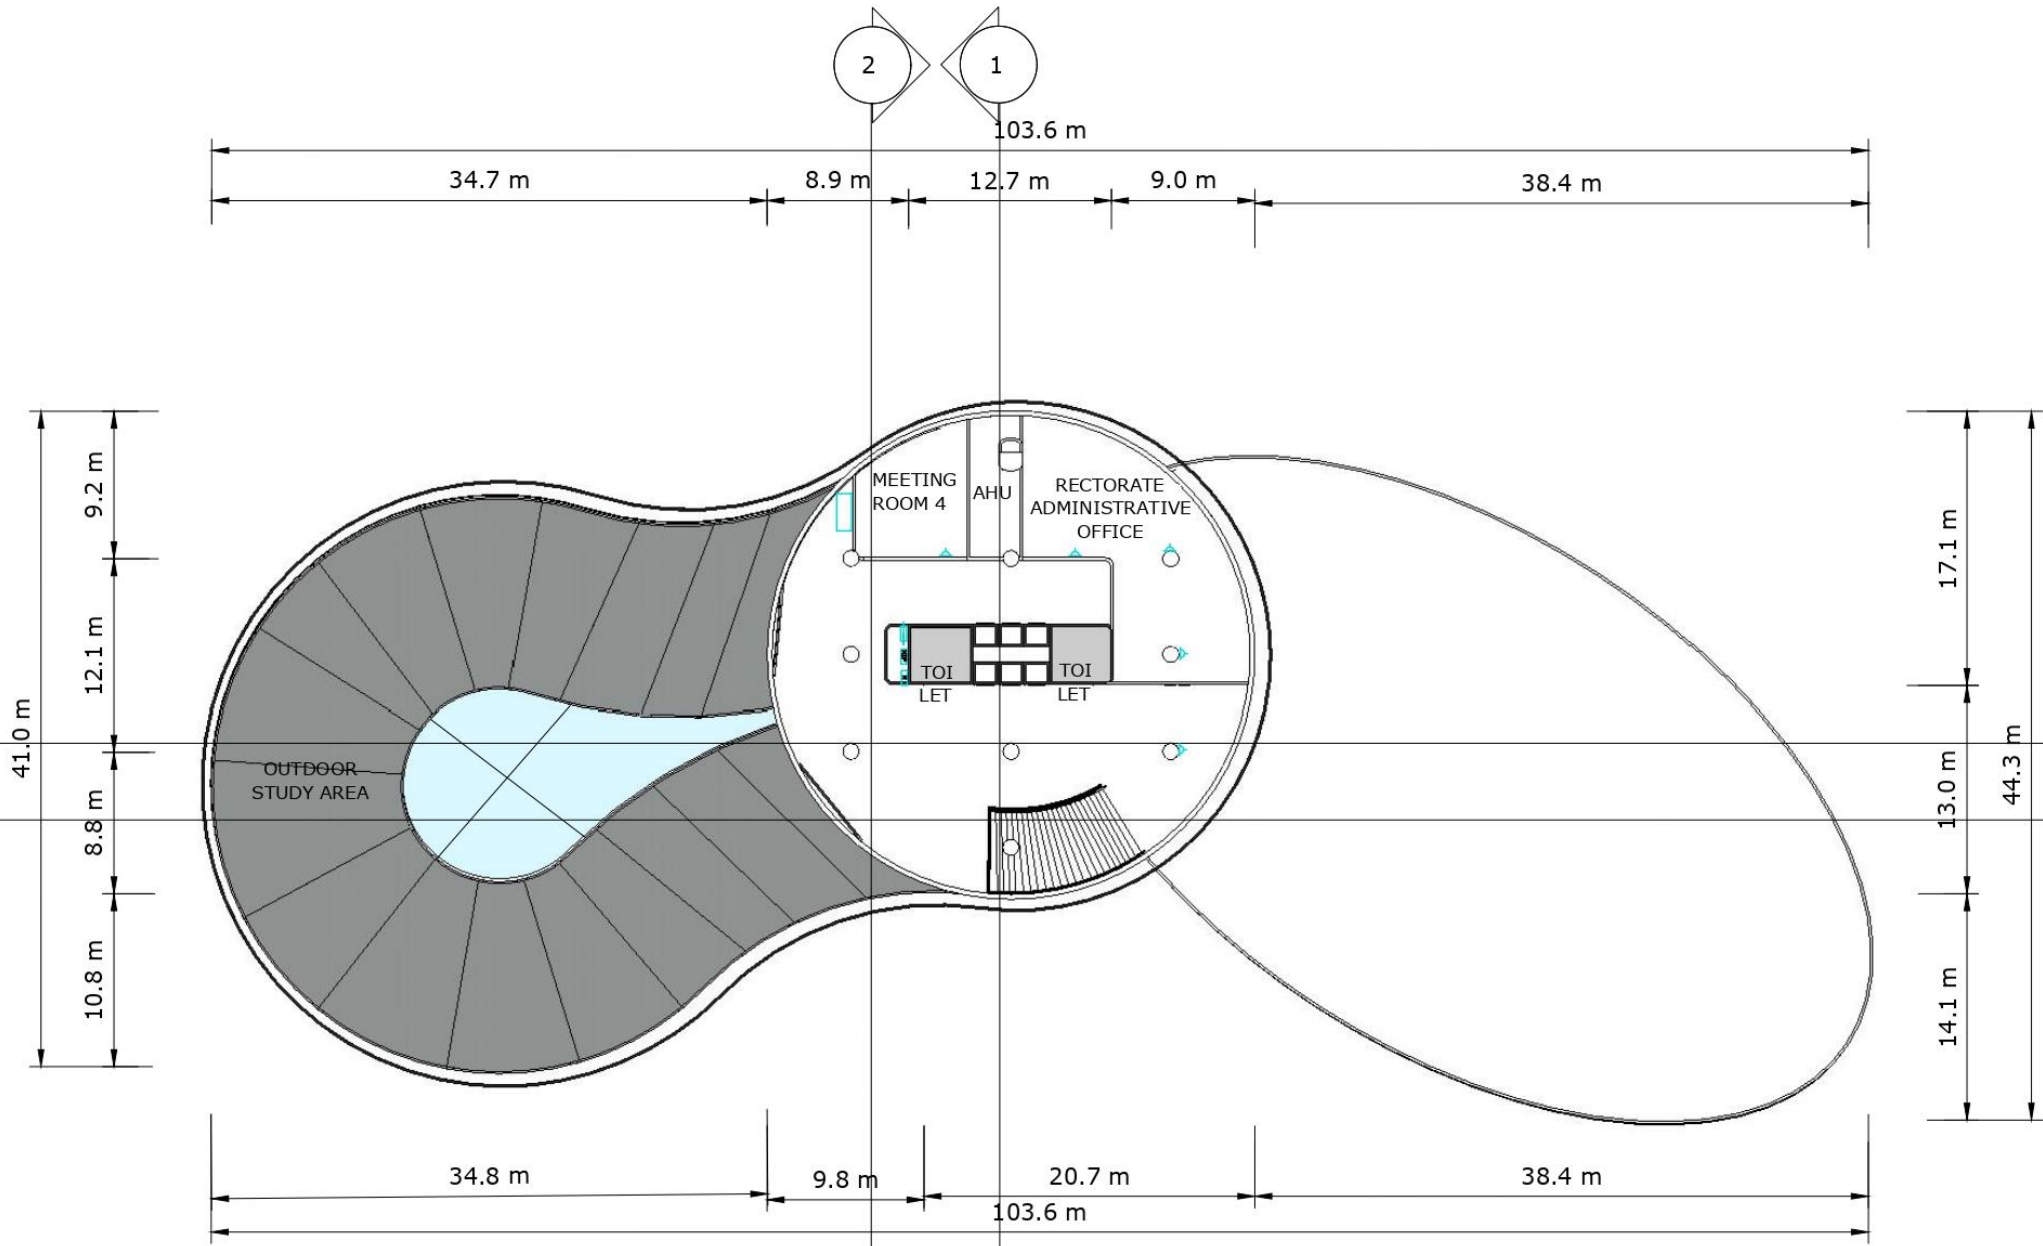

LEGENDA	
	STOPKONTAK
	PANEL SEKRING RUANG
	PANEL SEKRING LANTAI
	MAIN PANEL
	METER LISTRIK


DENAH LT 4
skala 1:400

PRODUCED BY AN AUTODESK STUDENT VERSION

	NAMA - NIM	MATA KULIAH	TUTOR	DOSEN
	JESSICA NATALIA 0206031910017	COMMERCIAL SPACE DESIGN	PAK FREDDY	PAK YUSUF

PRODUCED BY AN AUTODESK STUDENT VERSION

PRODUCED BY AN AUTODESK STUDENT VERSION

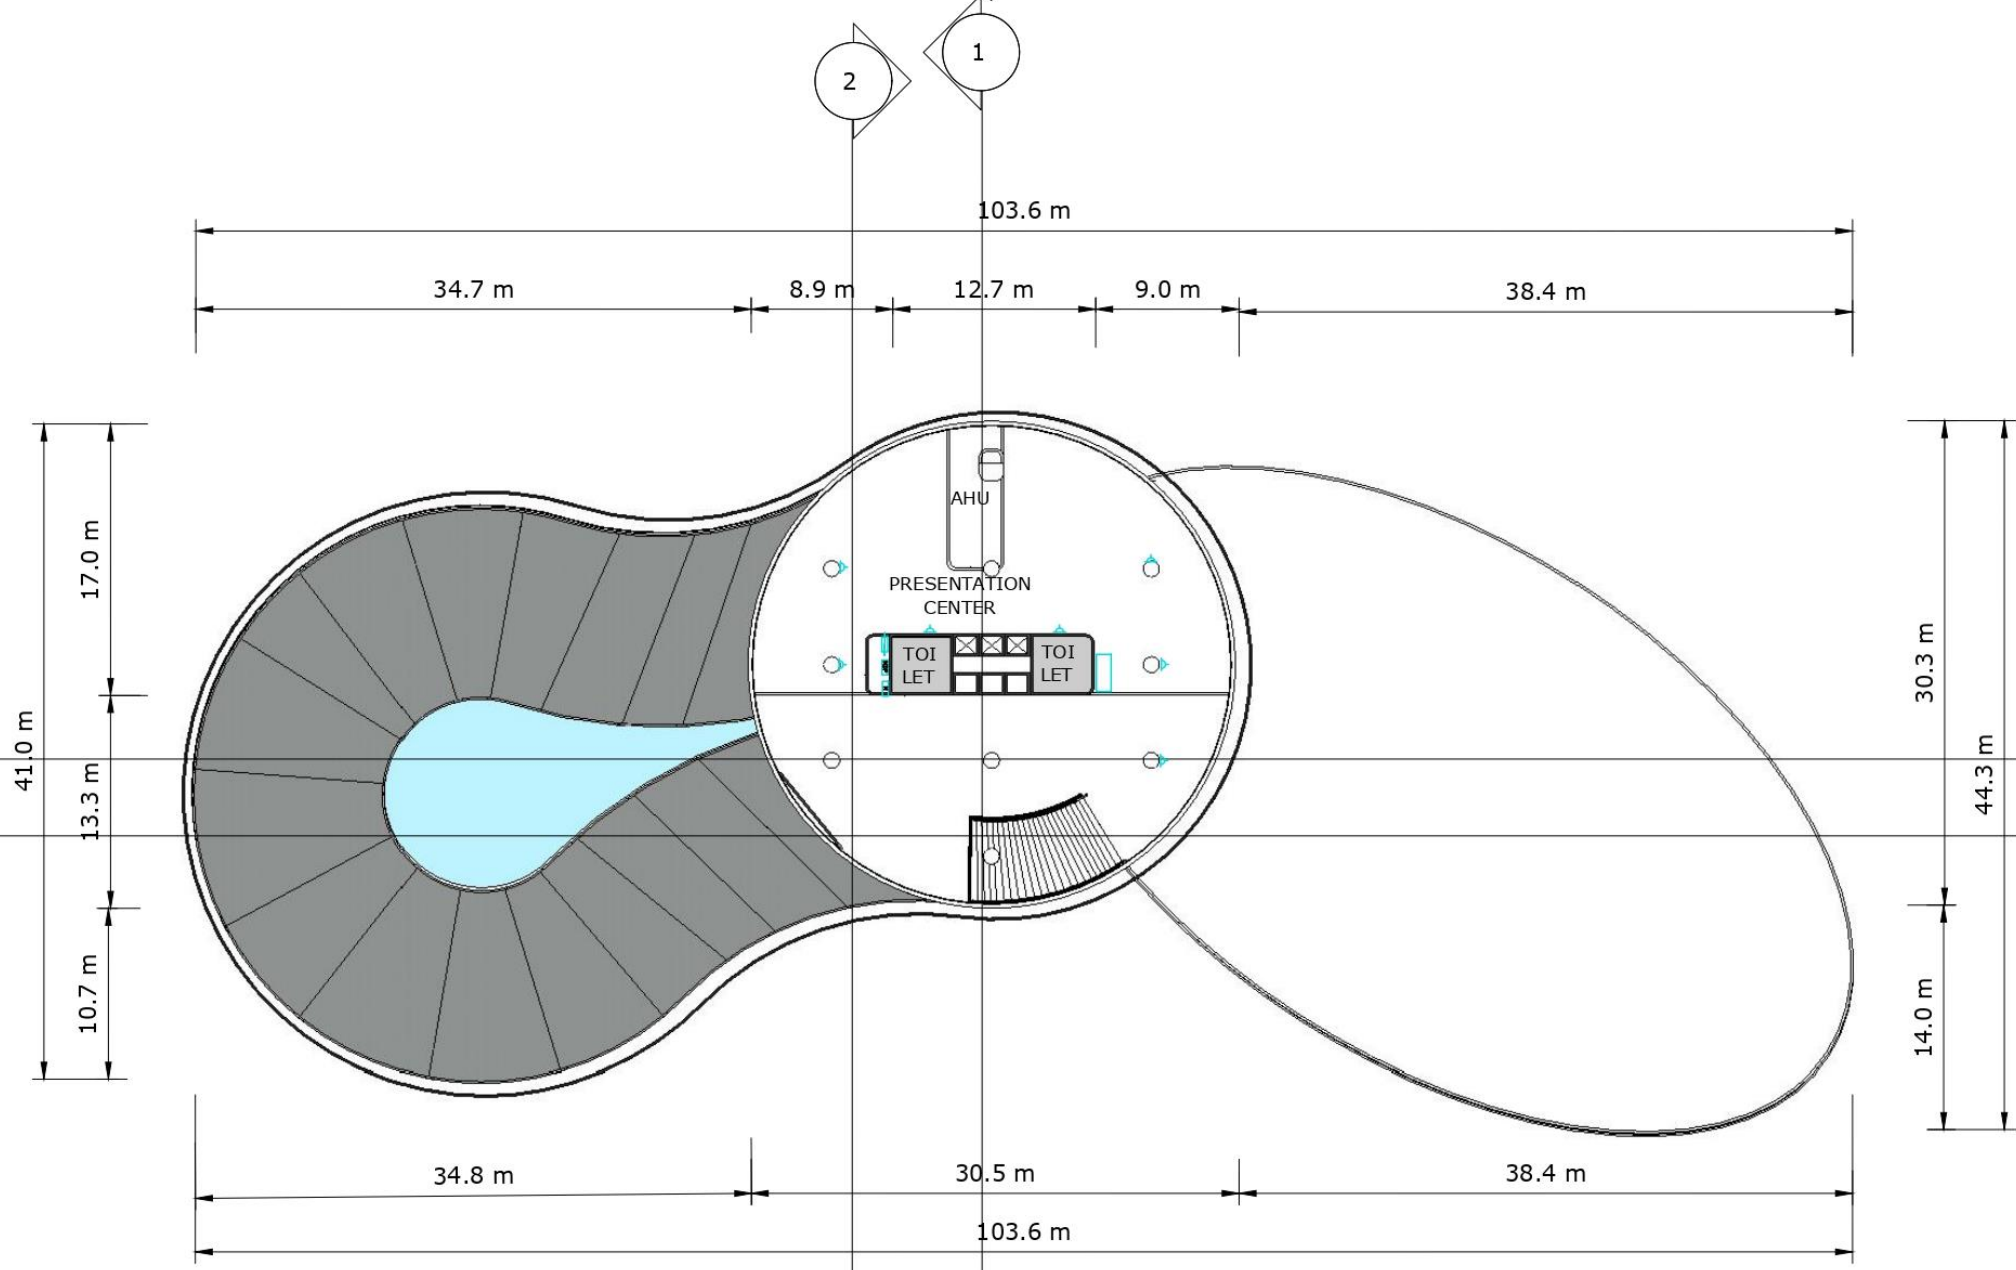


LEGENDA	
	STOPKONTAK
	PANEL SEKRING RUANG
	PANEL SEKRING LANTAI
	MAIN PANEL
	METER LISTRIK

DENAH LT 5
skala 1:400

	NAMA - NIM	MATA KULIAH	TUTOR	DOSEN
	JESSICA NATALIA 0206031910017	COMMERCIAL SPACE DESIGN	PAK FREDDY	PAK YUSUF

PRODUCED BY AN AUTODESK STUDENT VERSION

PRODUCED BY AN AUTODESK STUDENT VERSION

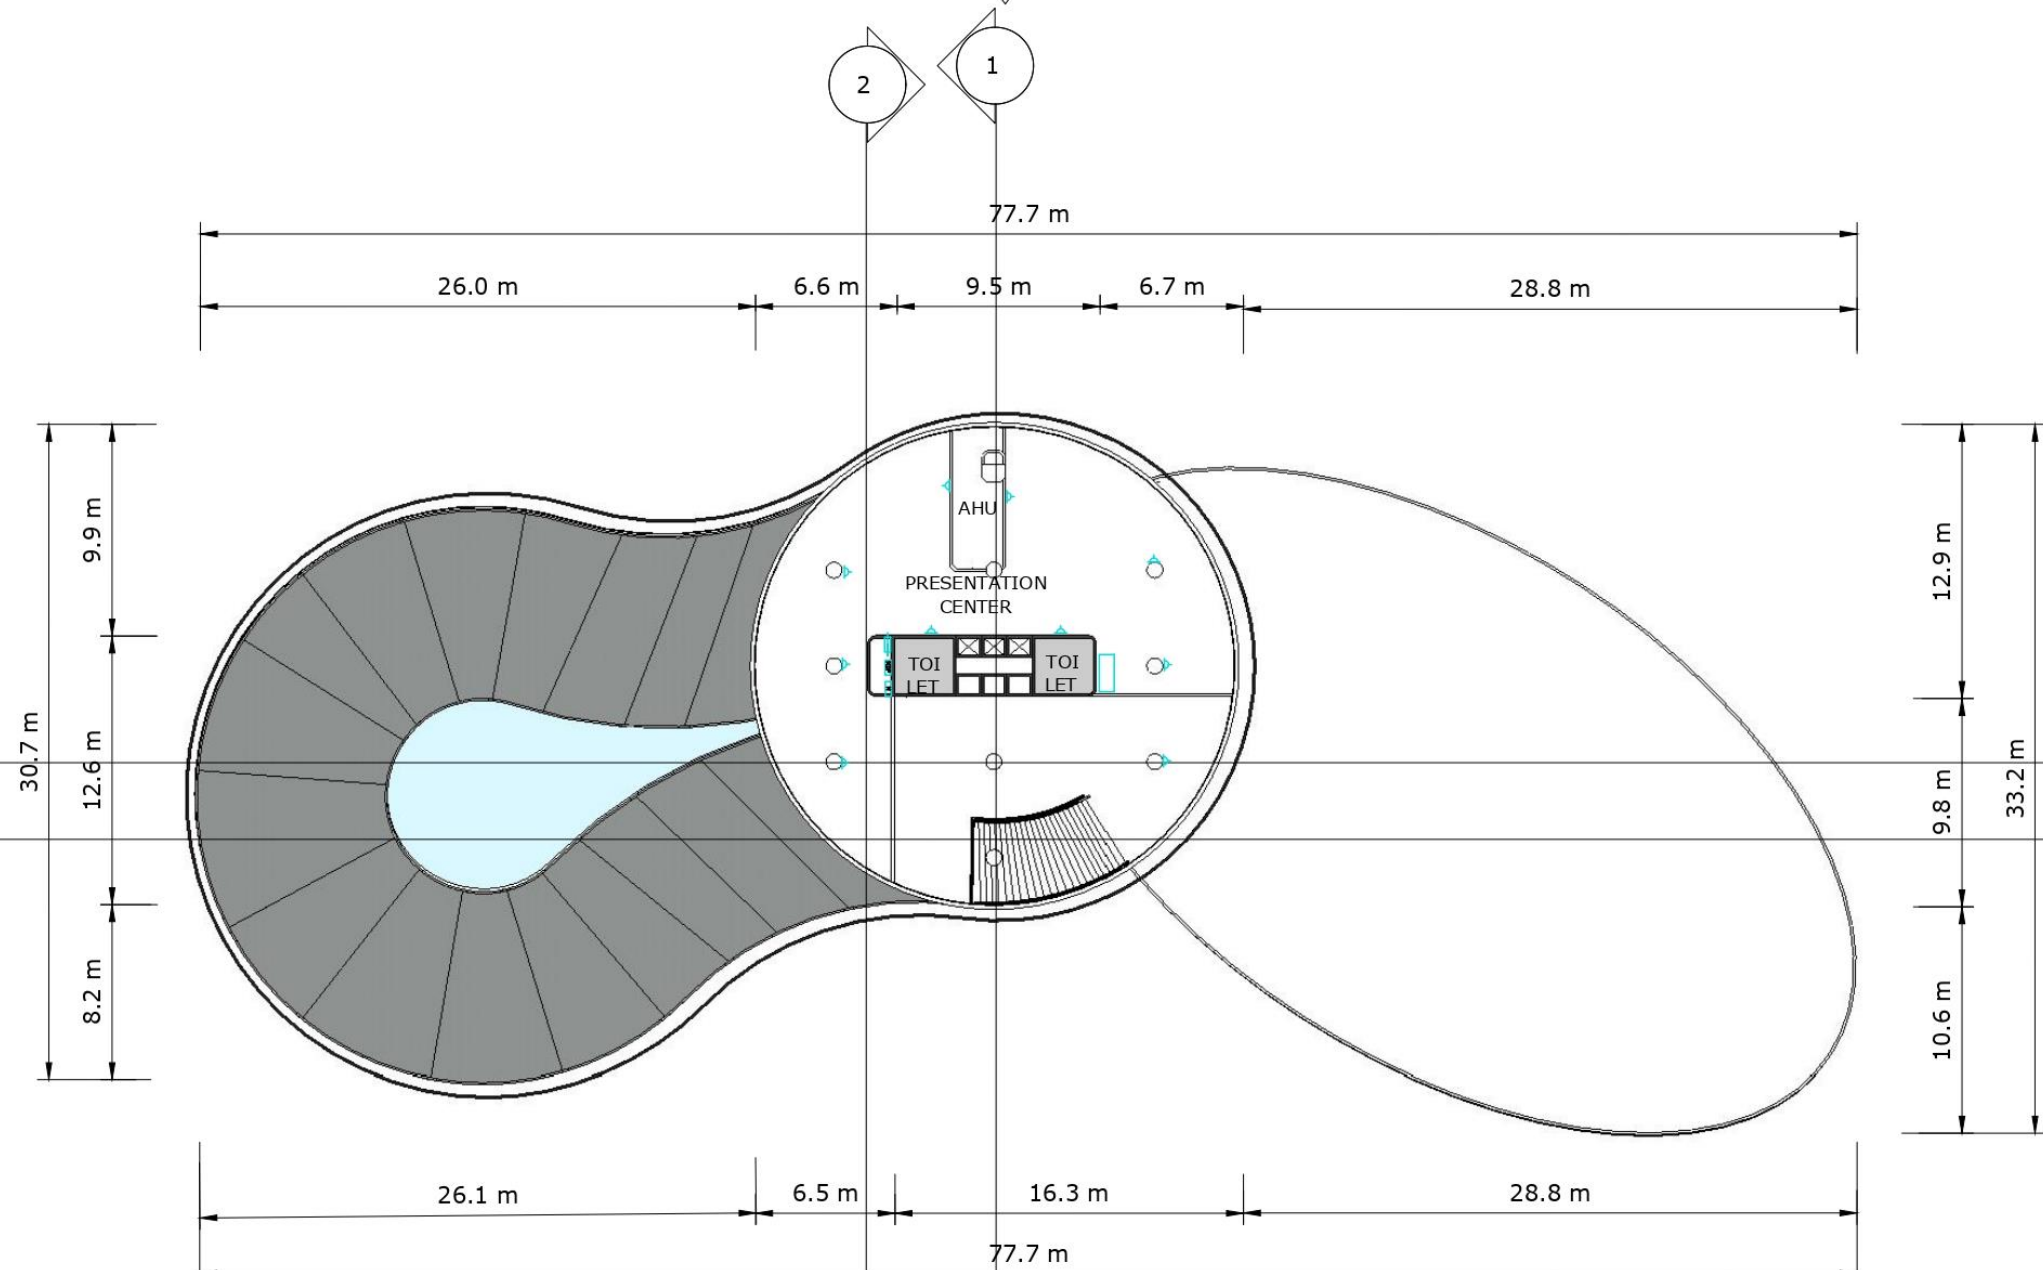

DENAH LT 6
skala 1:400

	NAMA - NIM	MATA KULIAH	TUTOR	DOSEN
	JESSICA NATALIA 0206031910017	COMMERCIAL SPACE DESIGN	PAK FREDDY	PAK YUSUF




MEP

LIGHTING & CEILING

PRODUCED BY AN AUTODESK STUDENT VERSION

PRODUCED BY AN AUTODESK STUDENT VERSION

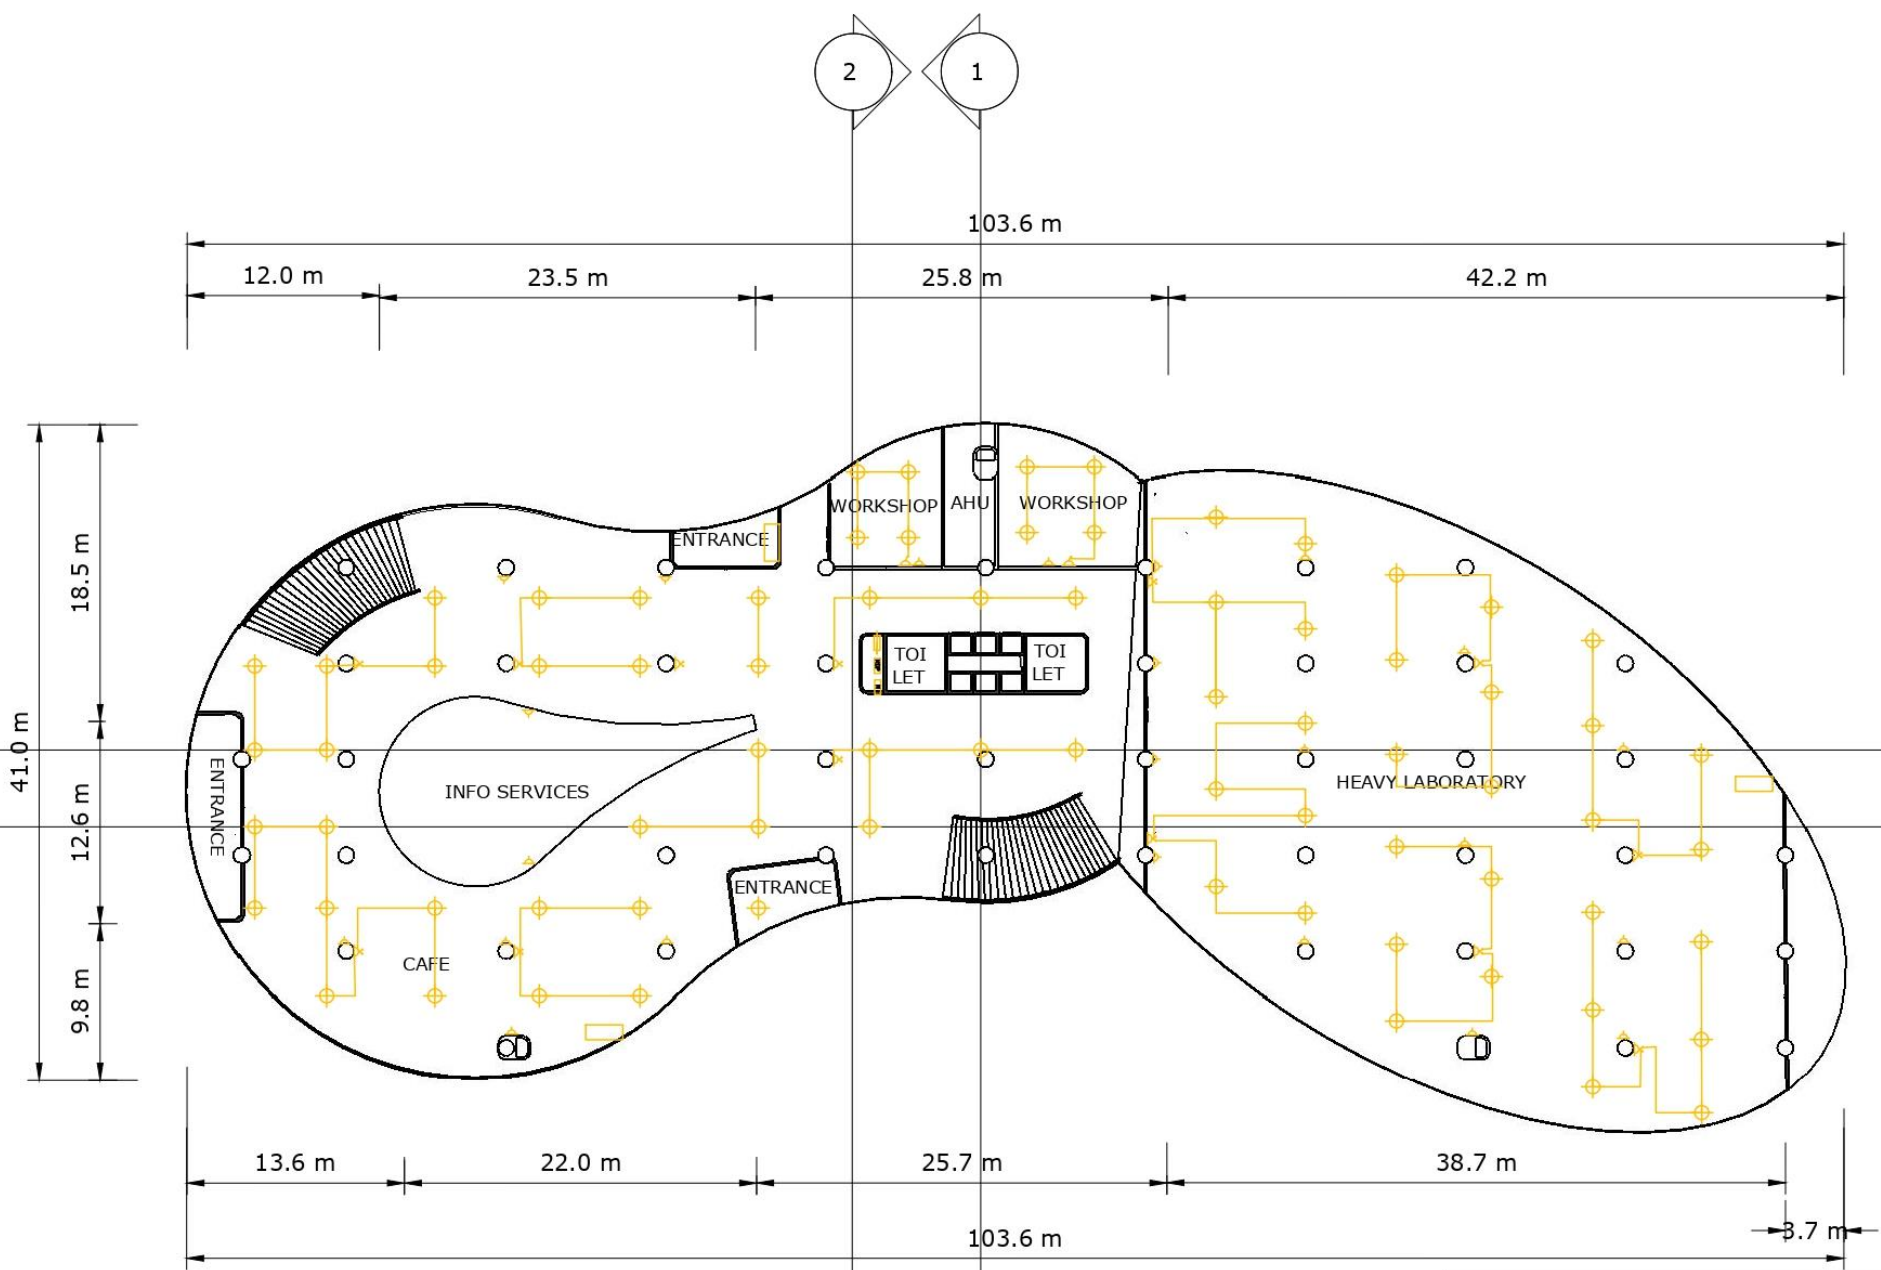

LEGENDA			
	STOPKONTAK		DOWNLIGHT
	PANEL SEKRING RUANG		KABEL LAMPU
	PANEL SEKRING LANTAI		SAKLAR TUNGGAL
	MAIN PANEL		SAKLAR GANDA
	METER LISTRIK		

DENAH LT 1
skala 1:400

	NAMA - NIM	MATA KULIAH	TUTOR	DOSEN
	JESSICA NATALIA 0206031910017	COMMERCIAL SPACE DESIGN	PAK FREDDY	PAK YUSUF


34.5 m

14.5 m

20.0 m

PRODUCED BY AN AUTODESK STUDENT VERSION

23.3 m

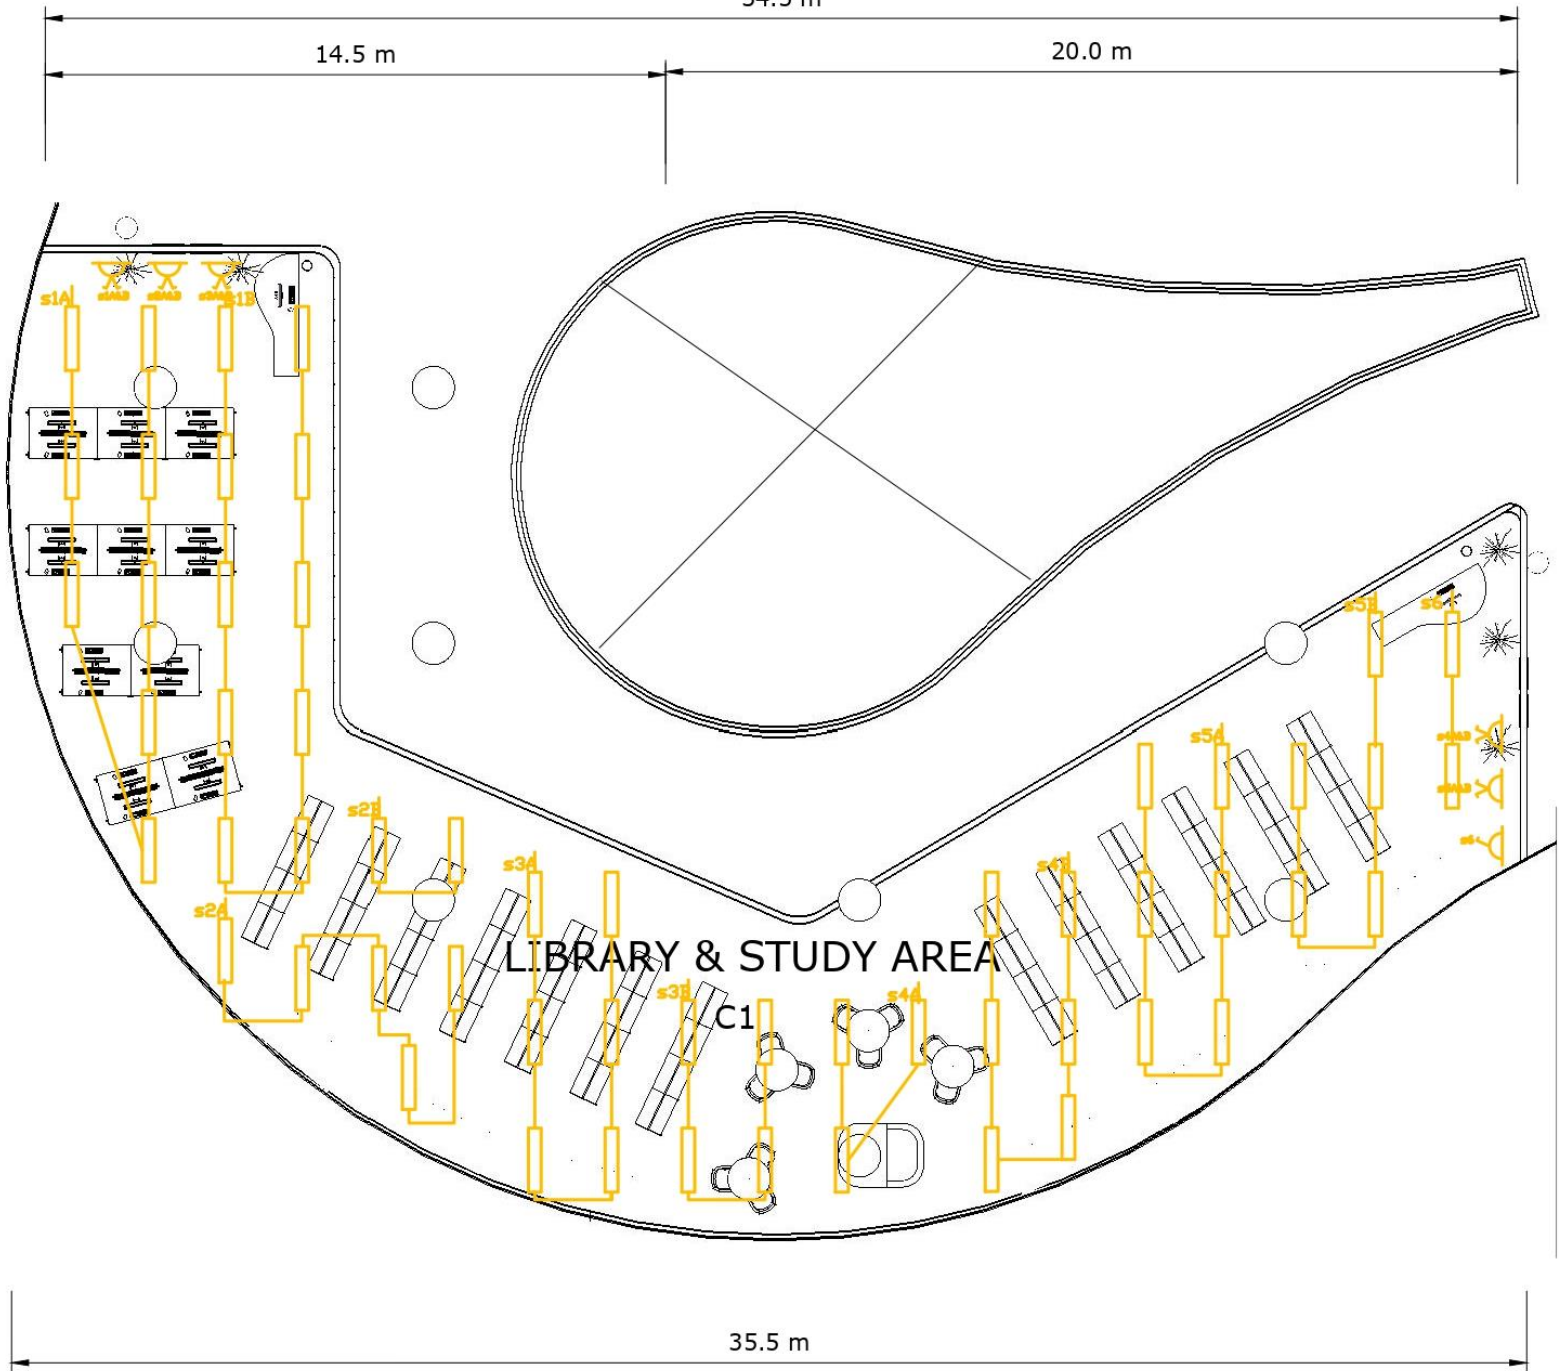

12.8 m

LEGENDA	
	DOWNLIGHT
	LED
	KABEL LAMPU
	SAKLAR TUNGGAL
	SAKLAR GANDA
	PLAFOND ALUMINIUM


PRODUCED BY AN AUTODESK STUDENT VERSION

LIBRARY & STUDY AREA

35.5 m

CEILING & LIGHTING PLAN 1
skala 1:150


	NAMA - NIM	MATA KULIAH	TUTOR	DOSEN
	JESSICA NATALIA 0206031910017	COMMERCIAL SPACE DESIGN	PAK FREDDY	PAK YUSUF

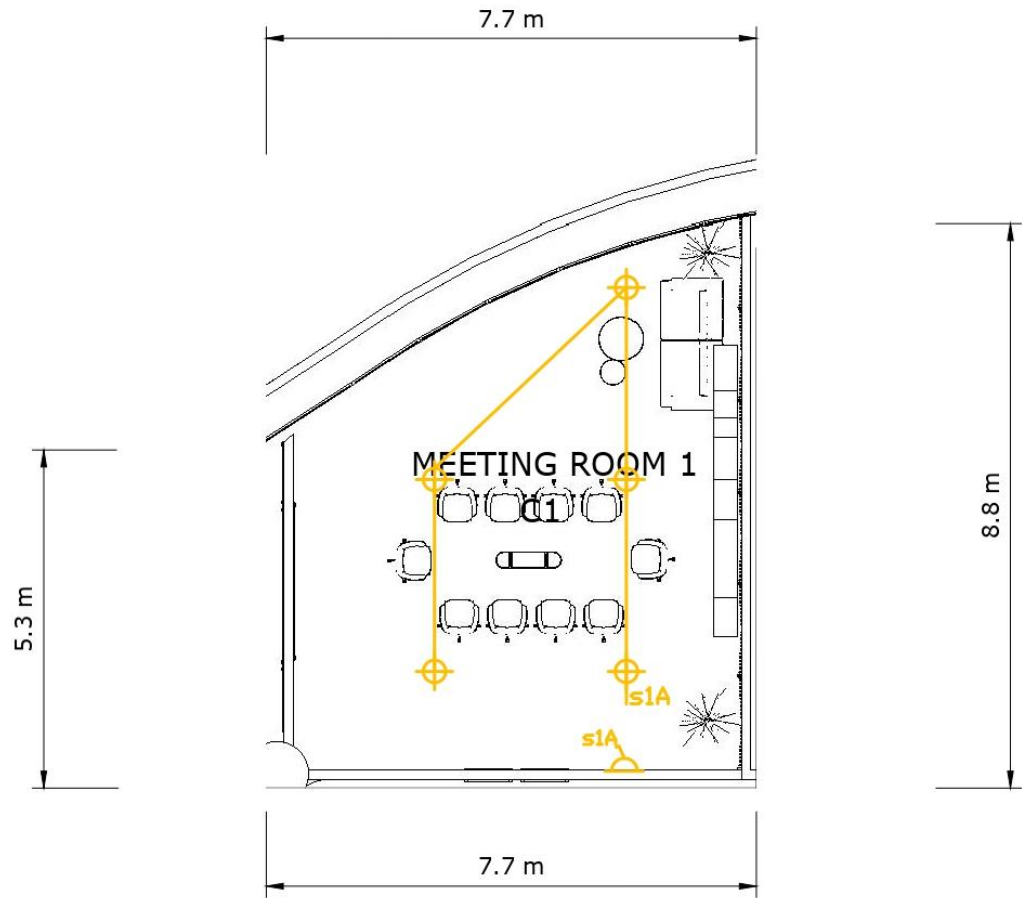


LEGENDA	
	DOWNLIGHT
	LED
	KABEL LAMPU
	SAKLAR TUNGGAL
	SAKLAR GANDA
	PLAFOND ALUMUNIUM

CEILING & LIGHTING PLAN 2
skala 1:100

	NAMA - NIM	MATA KULIAH	TUTOR	DOSEN
	JESSICA NATALIA 0206031910017	COMMERCIAL SPACE DESIGN	PAK FREDDY	PAK YUSUF

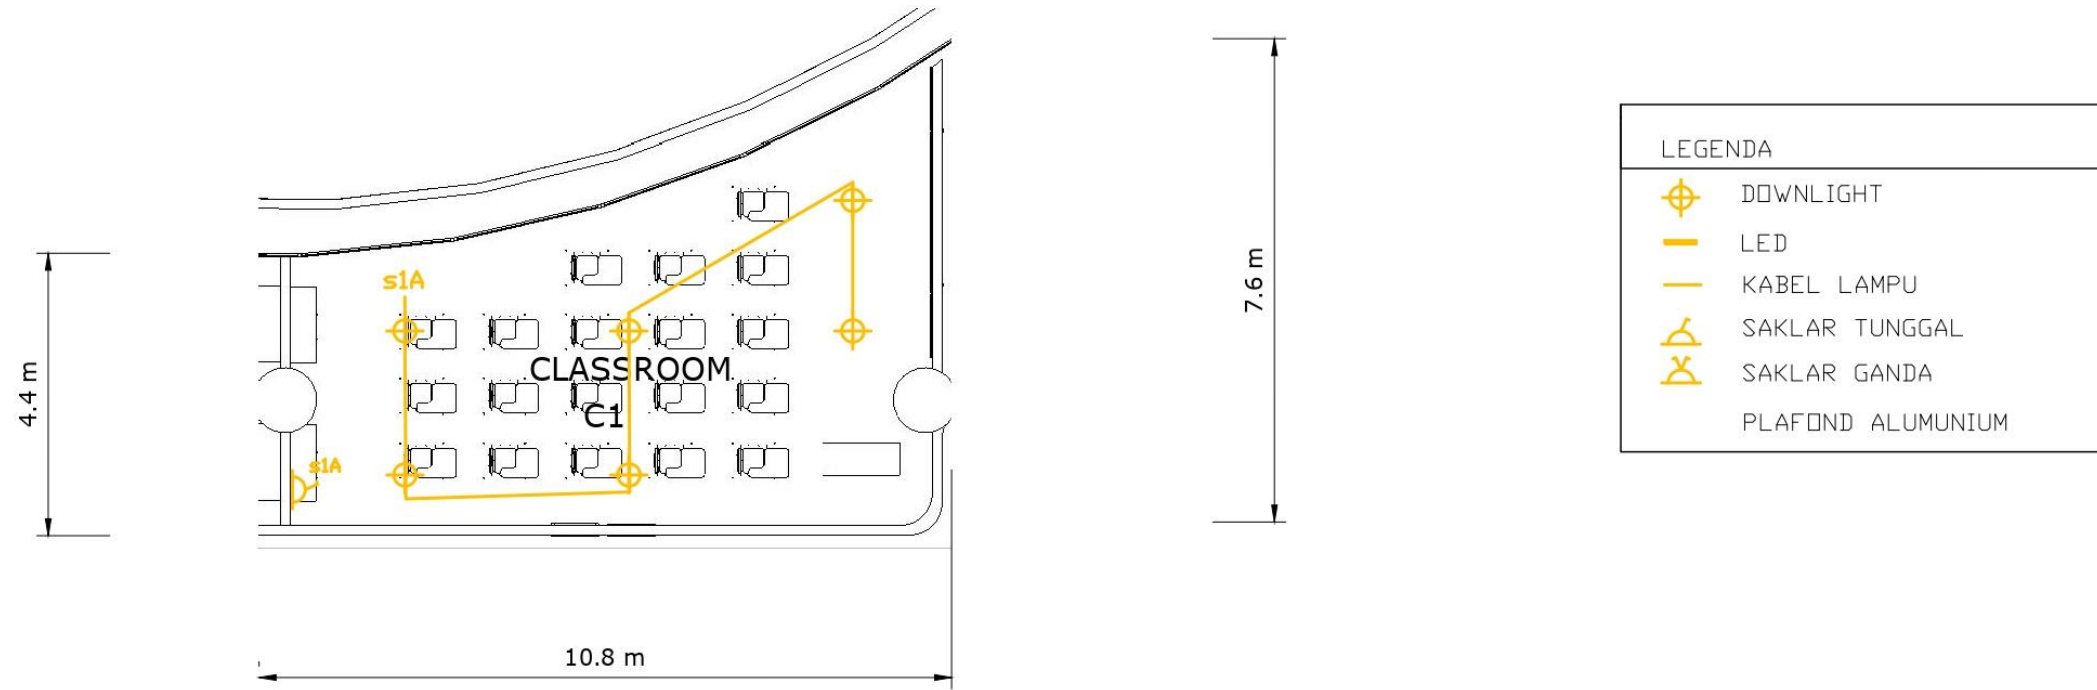


CEILING & LIGHTING PLAN 3
skala 1:100

	NAMA - NIM	MATA KULIAH	TUTOR	DOSEN
	JESSICA NATALIA 0206031910017	COMMERCIAL SPACE DESIGN	PAK FREDDY	PAK YUSUF

PRODUCED BY AN AUTODESK STUDENT VERSION


PRODUCED BY AN AUTODESK STUDENT VERSION

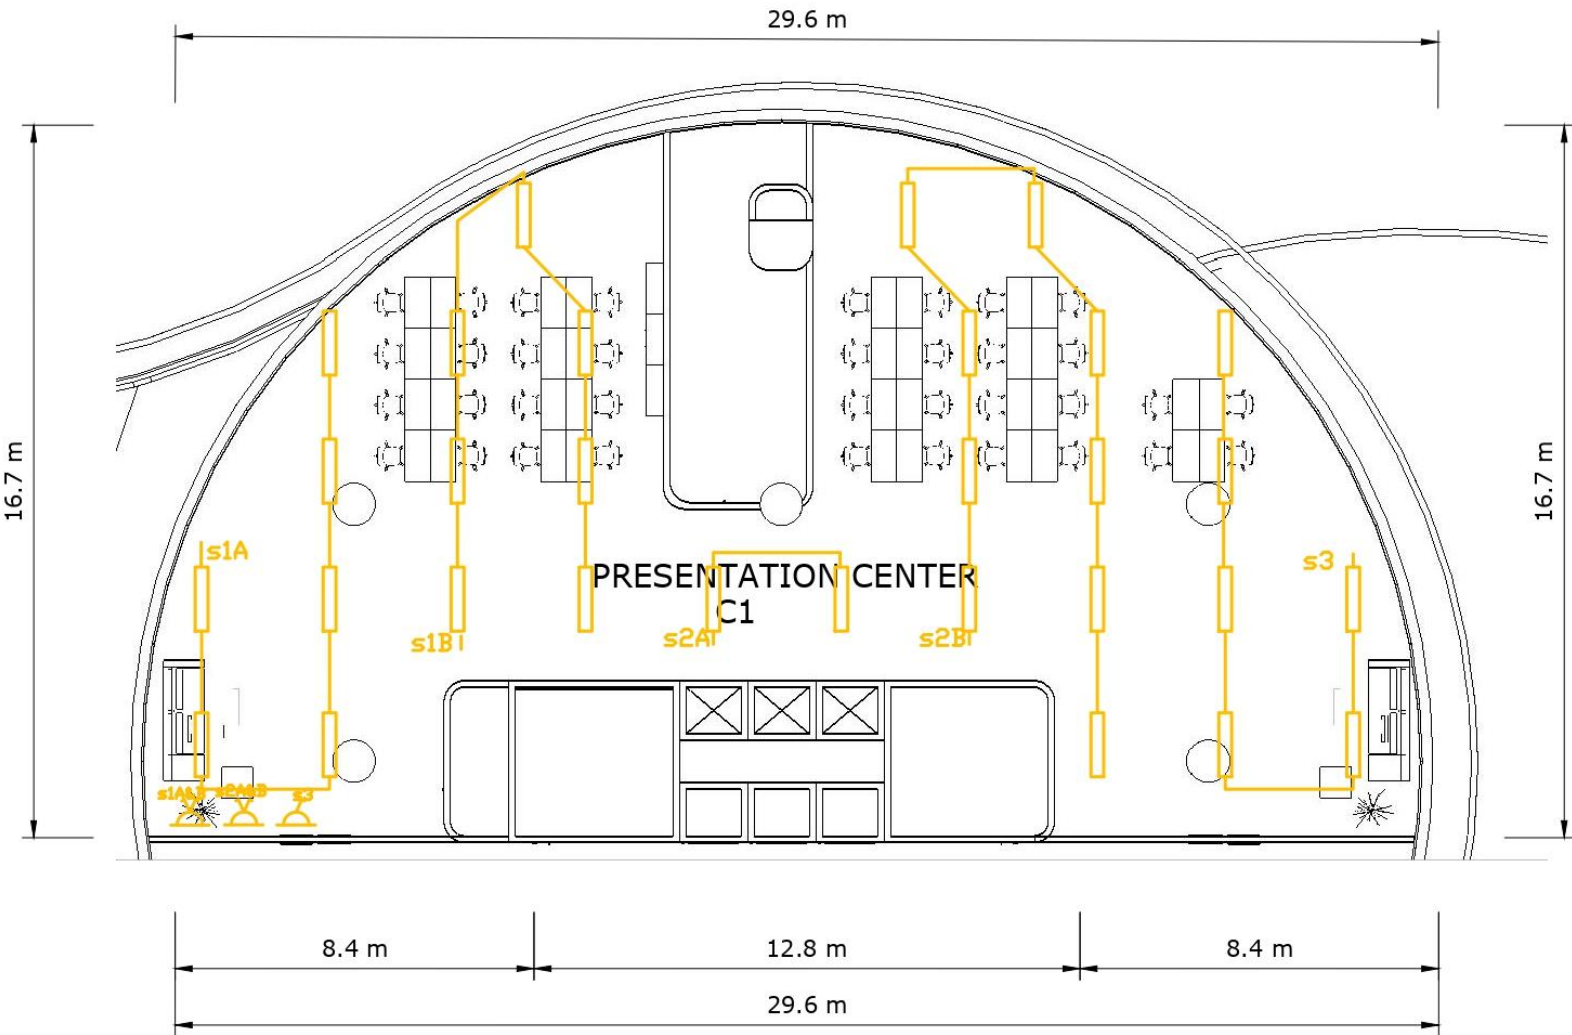

LEGENDA	
	DOWNLIGHT
	LED
	KABEL LAMPU
	SAKLAR TUNGGAL
	SAKLAR GANDA
	PLAFOND ALUMINIUM

CEILING & LIGHTING PLAN 4
skala 1:150


PRODUCED BY AN AUTODESK STUDENT VERSION

	NAMA - NIM	MATA KULIAH	TUTOR	DOSEN
	JESSICA NATALIA 0206031910017	COMMERCIAL SPACE DESIGN	PAK FREDDY	PAK YUSUF



SKEMATIK MEP

FLOORING

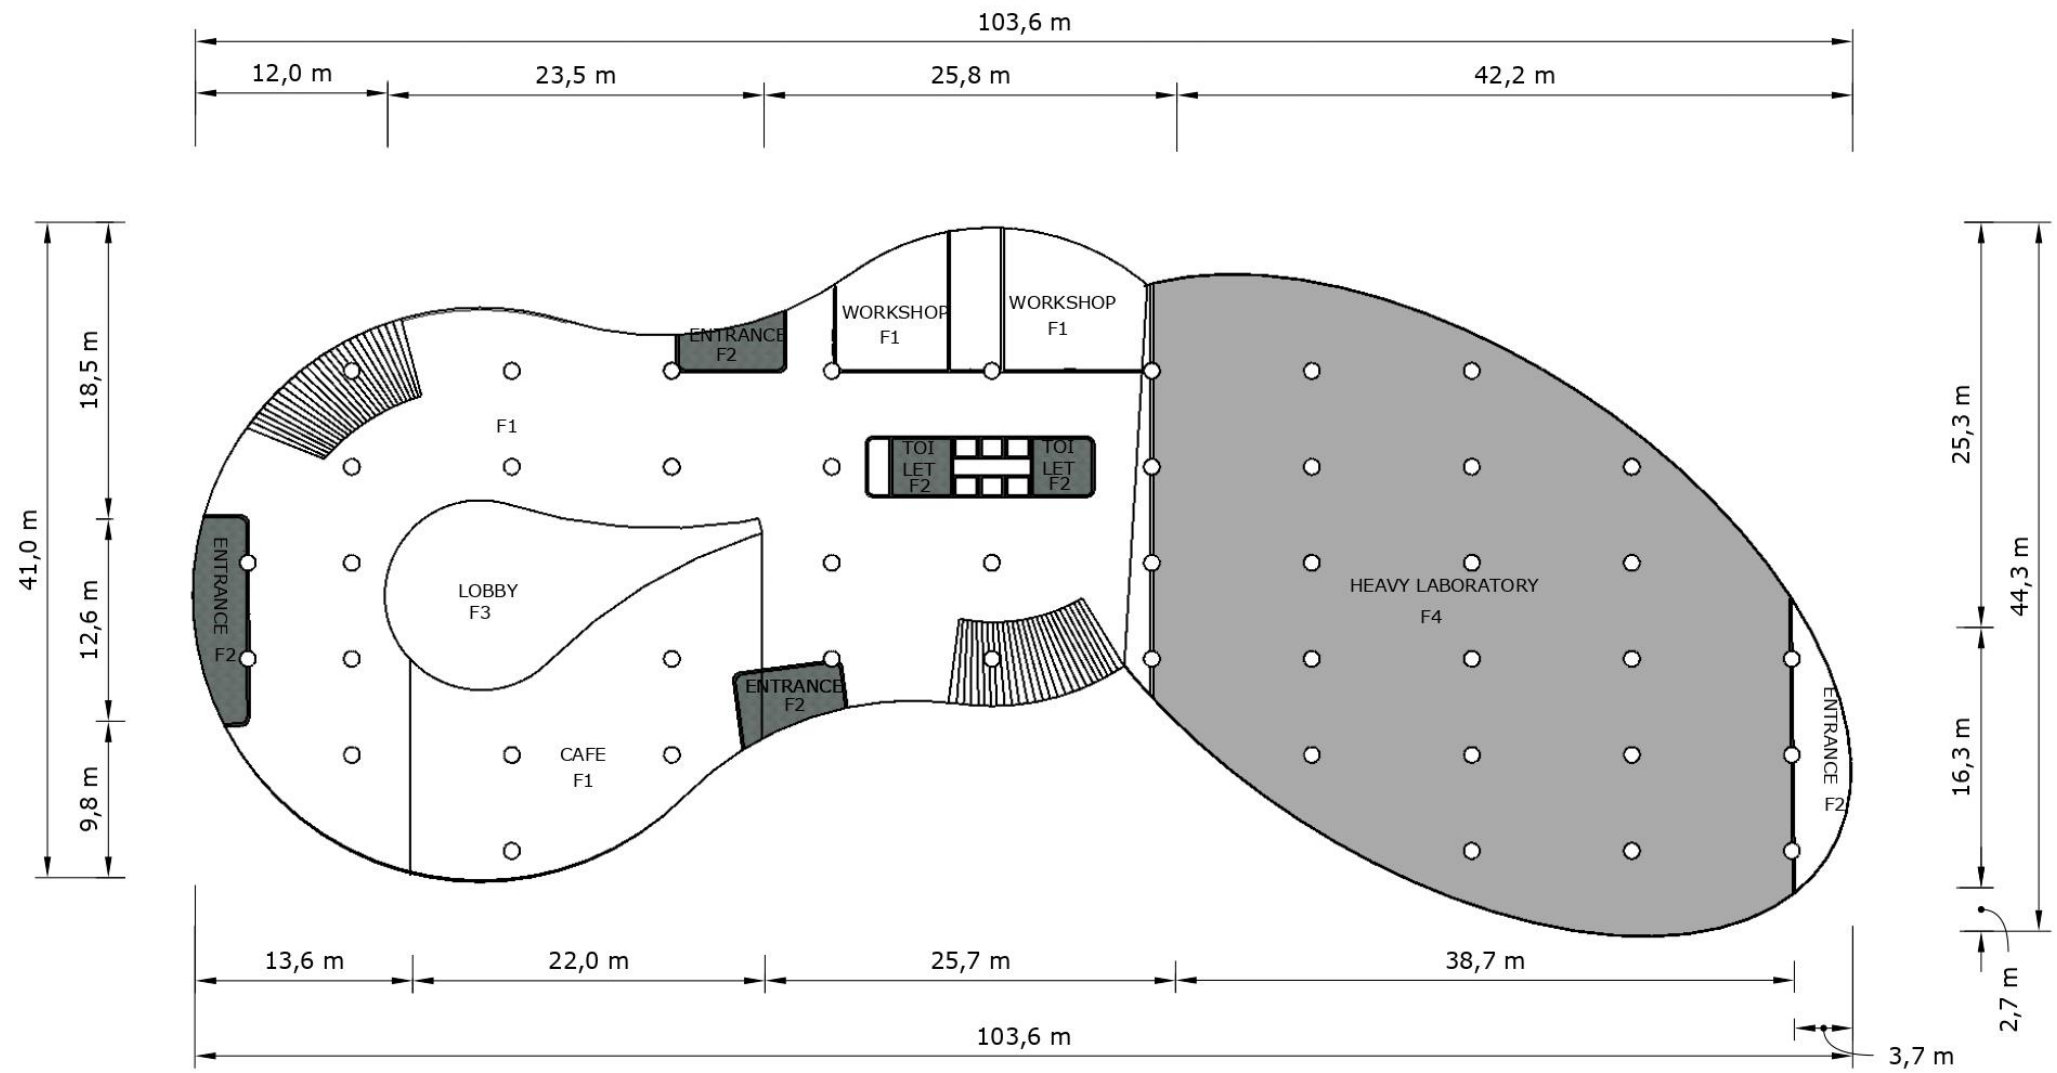

FLOORING LT 1
skala 1:400

LEGENDS	
F1	- COMPOSITE VINYL WHITE
F2	- CERAMICS DARK GREY DOFF
F3	- POLISHED CONCRETE
F4	- COMPOSITE VINYL LIGHT GREY


	NAMA - NIM	MATA KULIAH	TUTOR	DOSEN
	JESSICA NATALIA 0206031910017	COMMERCIAL SPACE DESIGN	PAK FREDDY	PAK YUSUF




STRUCTURE SYSTEM

PRODUCED BY AN AUTODESK STUDENT VERSION


PRODUCED BY AN AUTODESK STUDENT VERSION

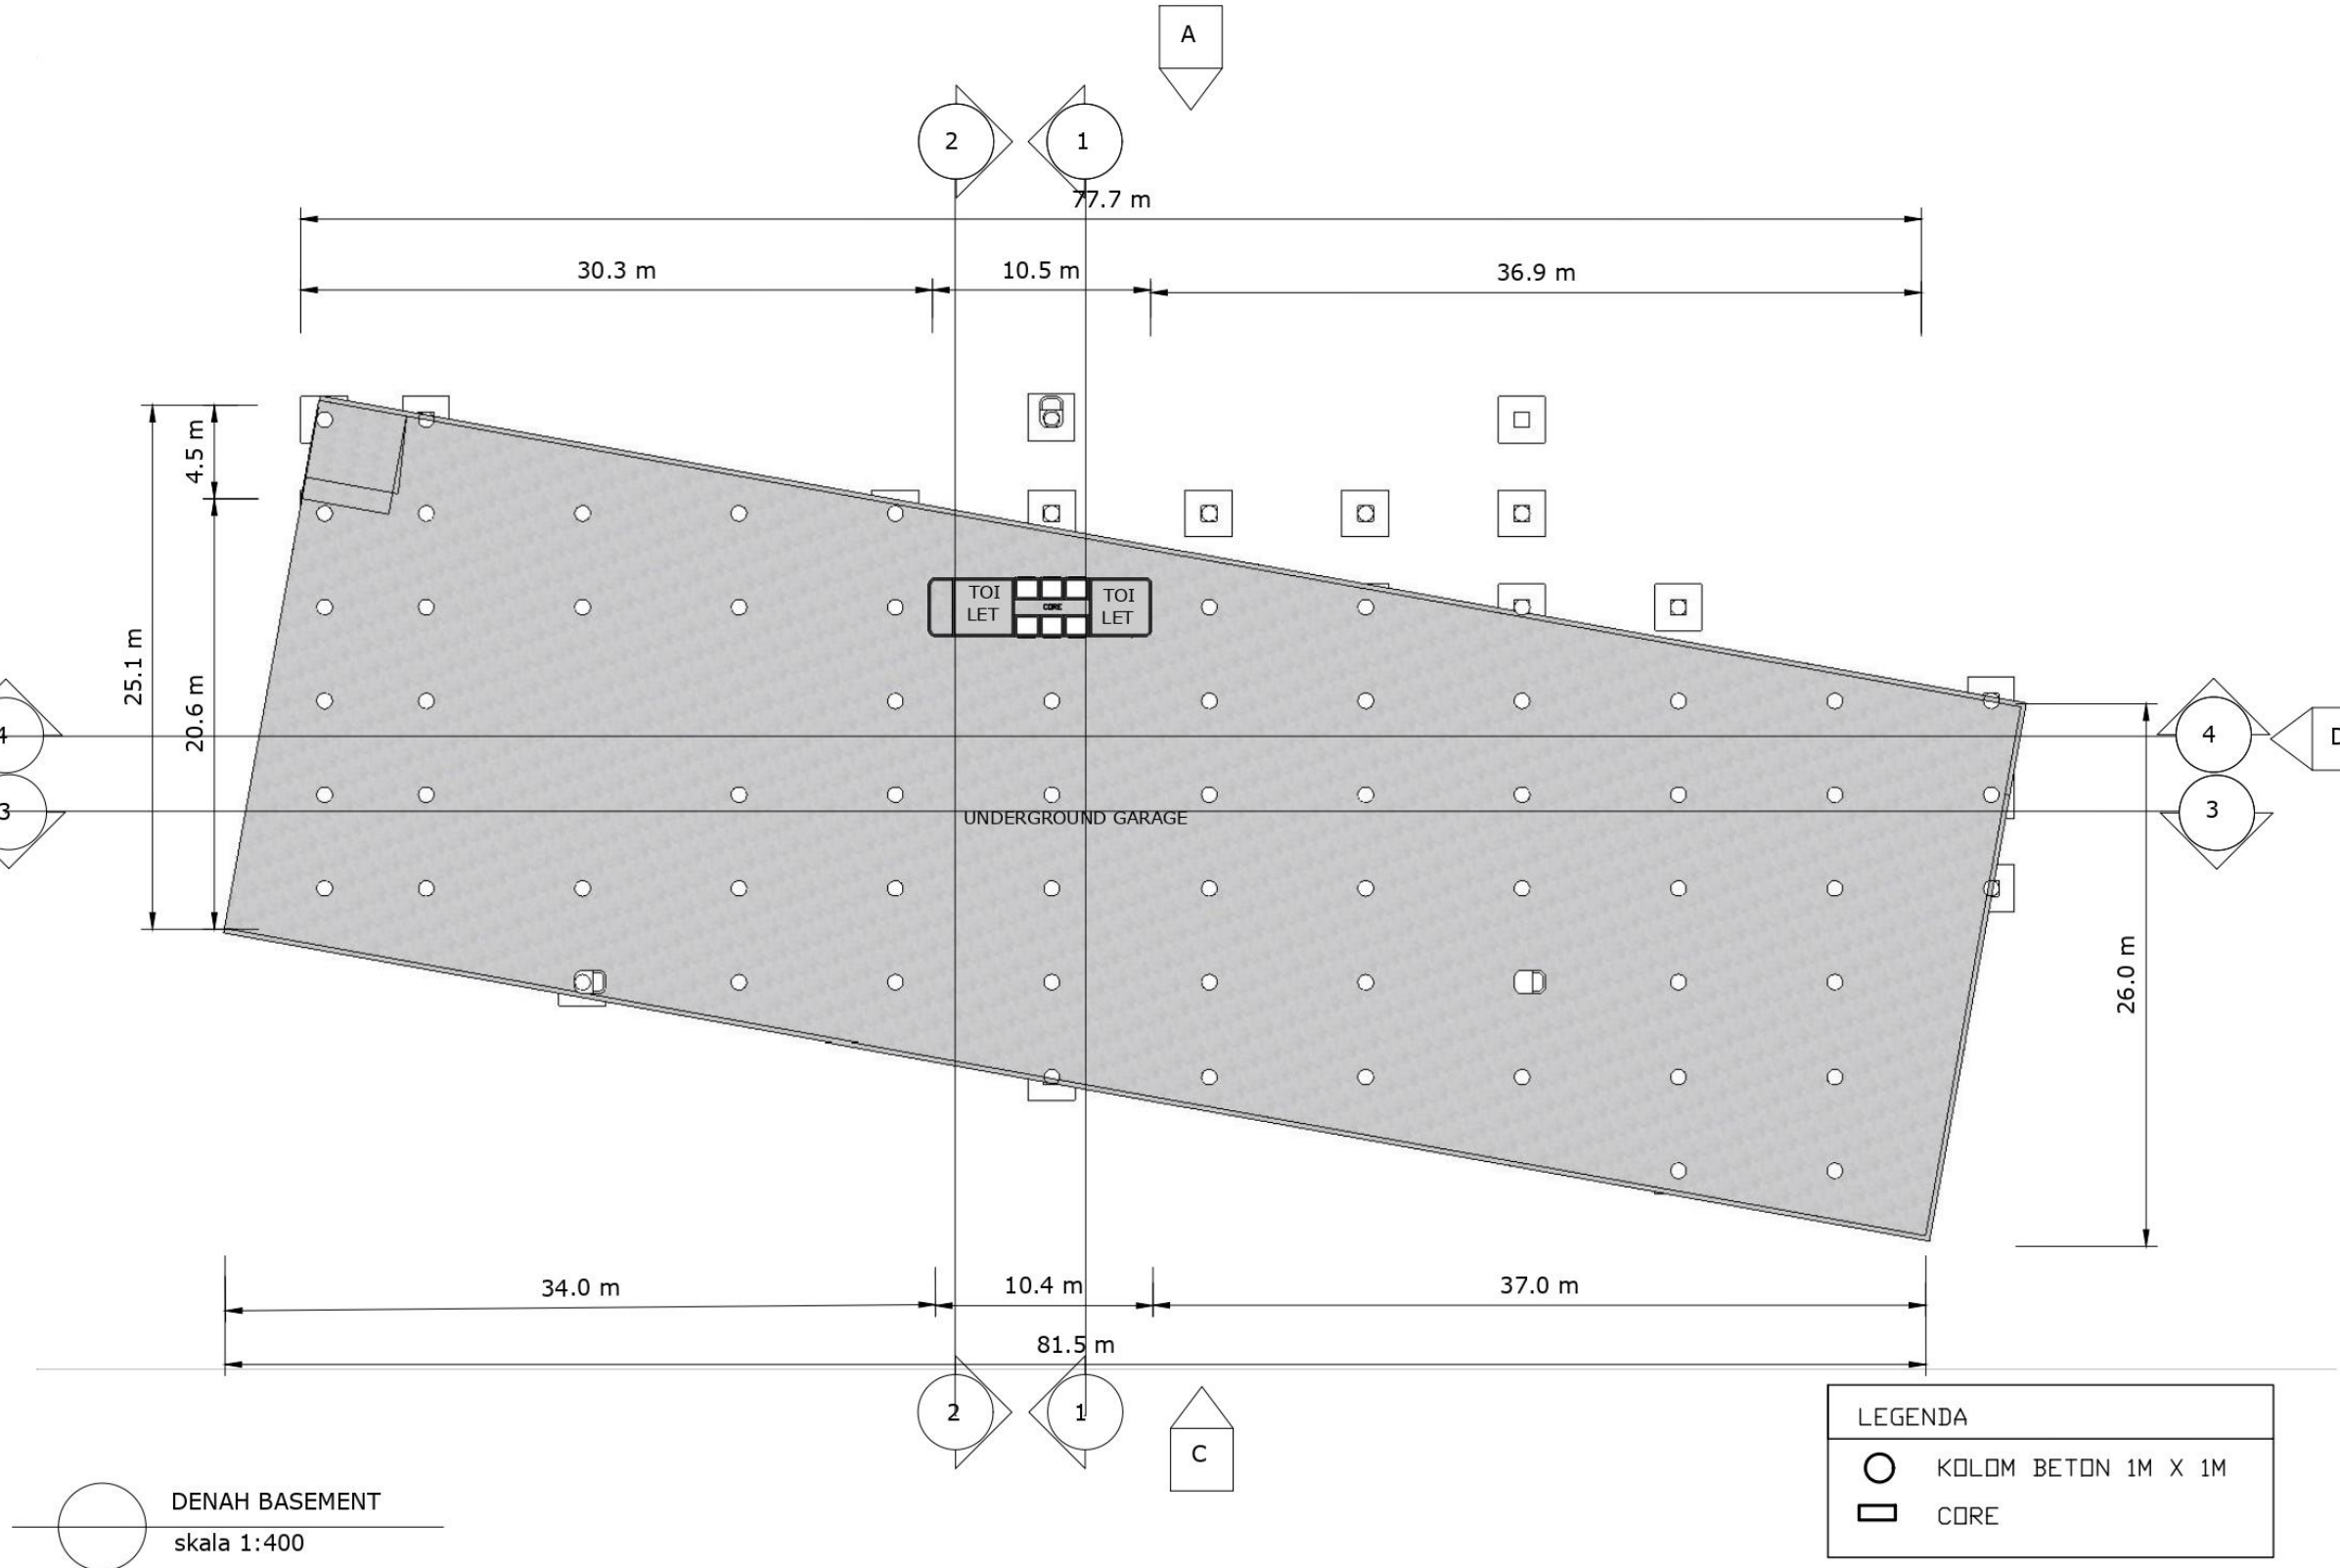

	NAMA - NIM	MATA KULIAH	TUTOR	DOSEN
	JESSICA NATALIA 0206031910017	COMMERCIAL SPACE DESIGN	PAK FREDDY	PAK YUSUF

PRODUCED BY AN AUTODESK STUDENT VERSION


PRODUCED BY AN AUTODESK STUDENT VERSION

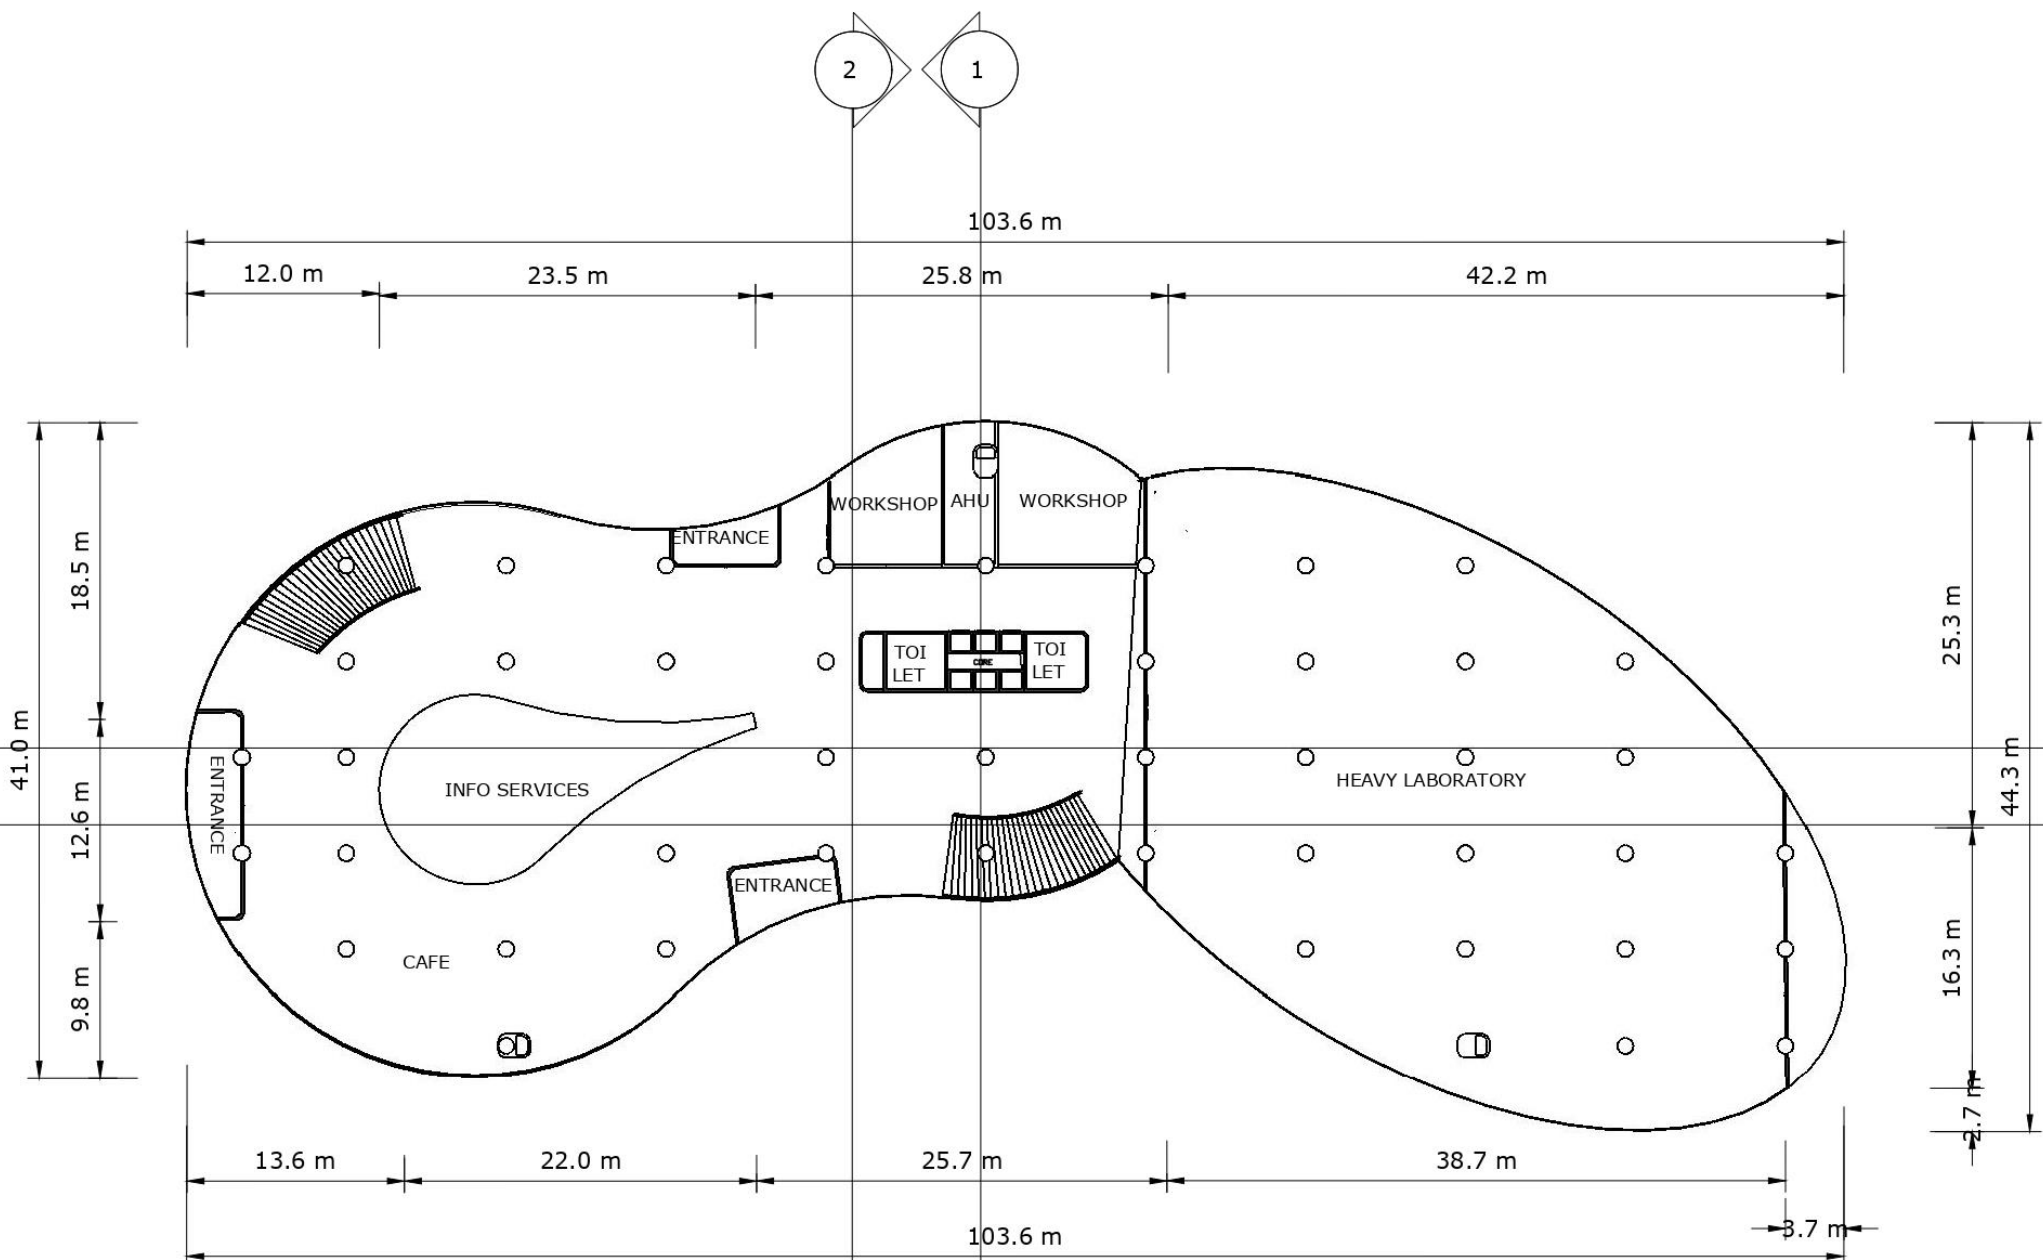

LEGENDA	
	KOLOM BETON 1M X 1M
	CORE


DENAH LT 1
skala 1:400

	NAMA - NIM	MATA KULIAH	TUTOR	DOSEN
	JESSICA NATALIA 0206031910017	COMMERCIAL SPACE DESIGN	PAK FREDDY	PAK YUSUF

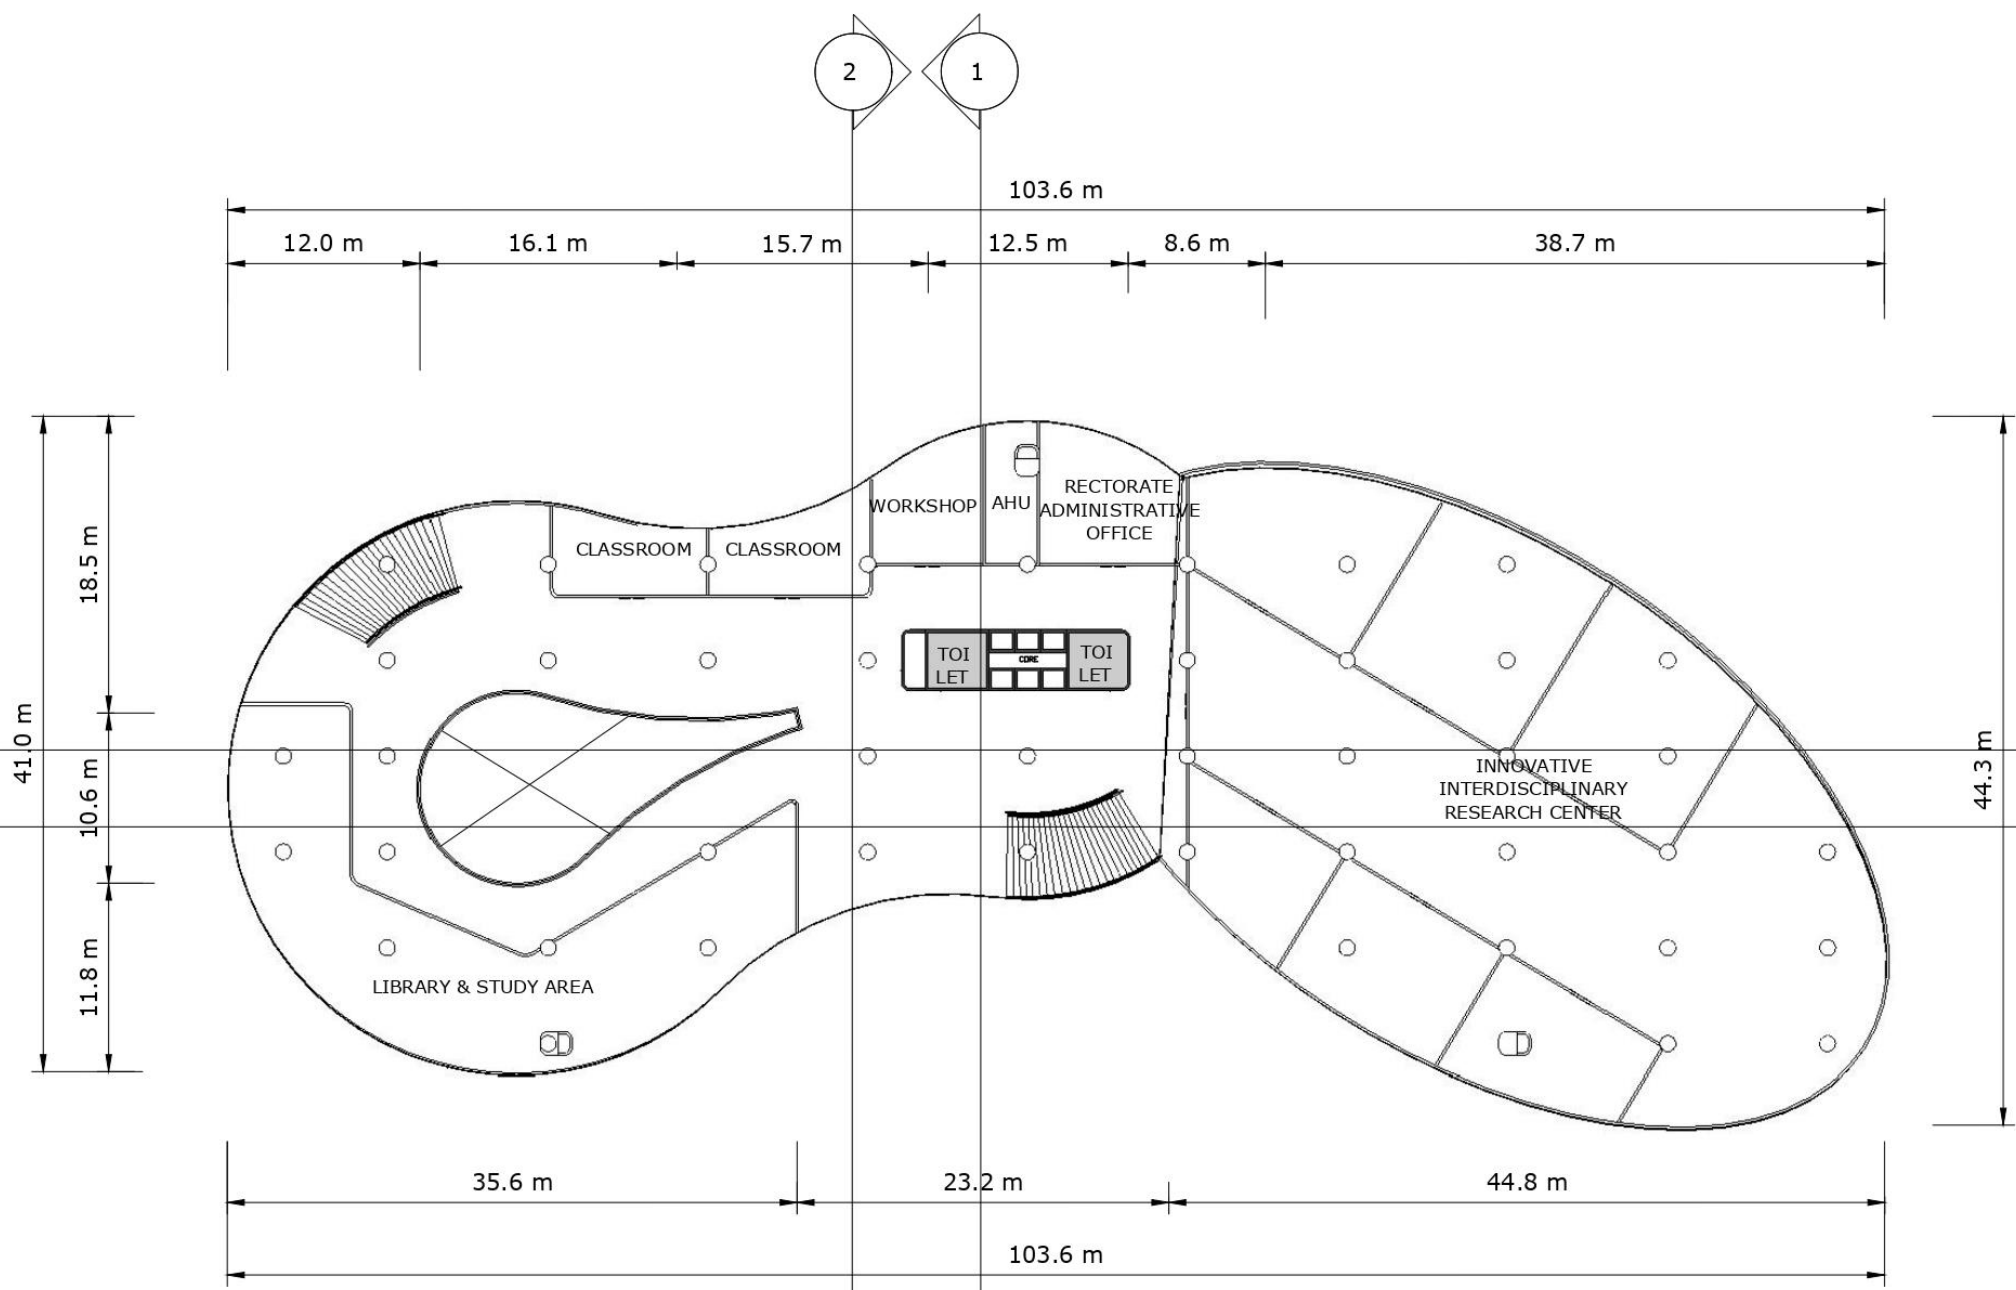


DENAH LT 2
skala 1:400

LEGENDA	
	KOLOM BETON 1M X 1M
	CORE

	NAMA - NIM	MATA KULIAH	TUTOR	DOSEN
	JESSICA NATALIA 0206031910017	COMMERCIAL SPACE DESIGN	PAK FREDDY	PAK YUSUF

PRODUCED BY AN AUTODESK STUDENT VERSION


PRODUCED BY AN AUTODESK STUDENT VERSION

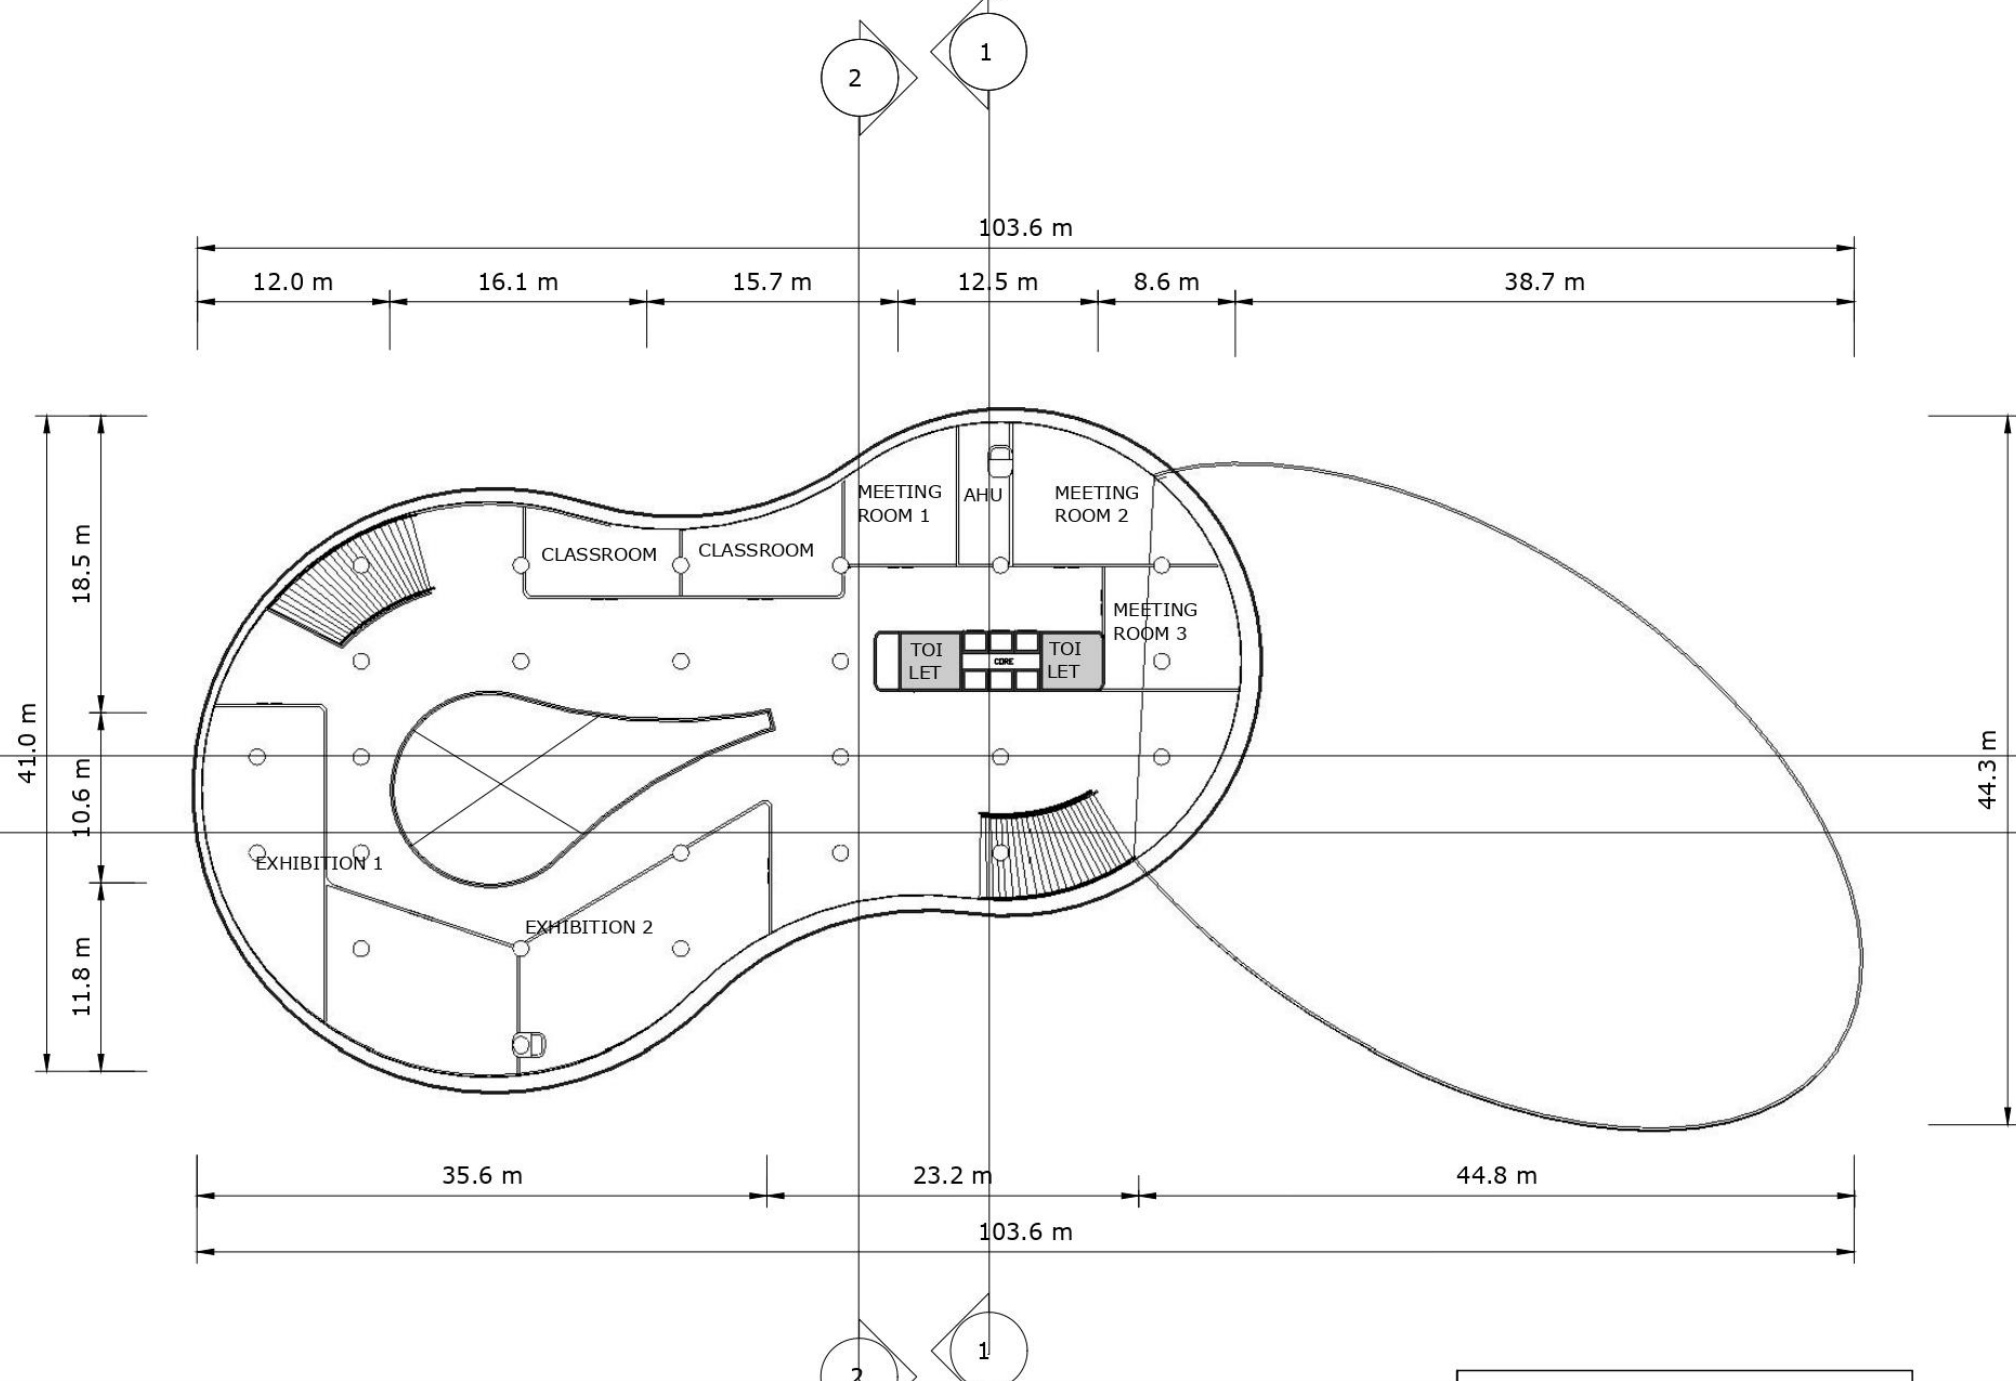

DENAH LT 3
skala 1:400


LEGENDA	
	KOLOM BETON 1M X 1M
	CORE

	NAMA - NIM	MATA KULIAH	TUTOR	DOSEN
	JESSICA NATALIA 0206031910017	COMMERCIAL SPACE DESIGN	PAK FREDDY	PAK YUSUF

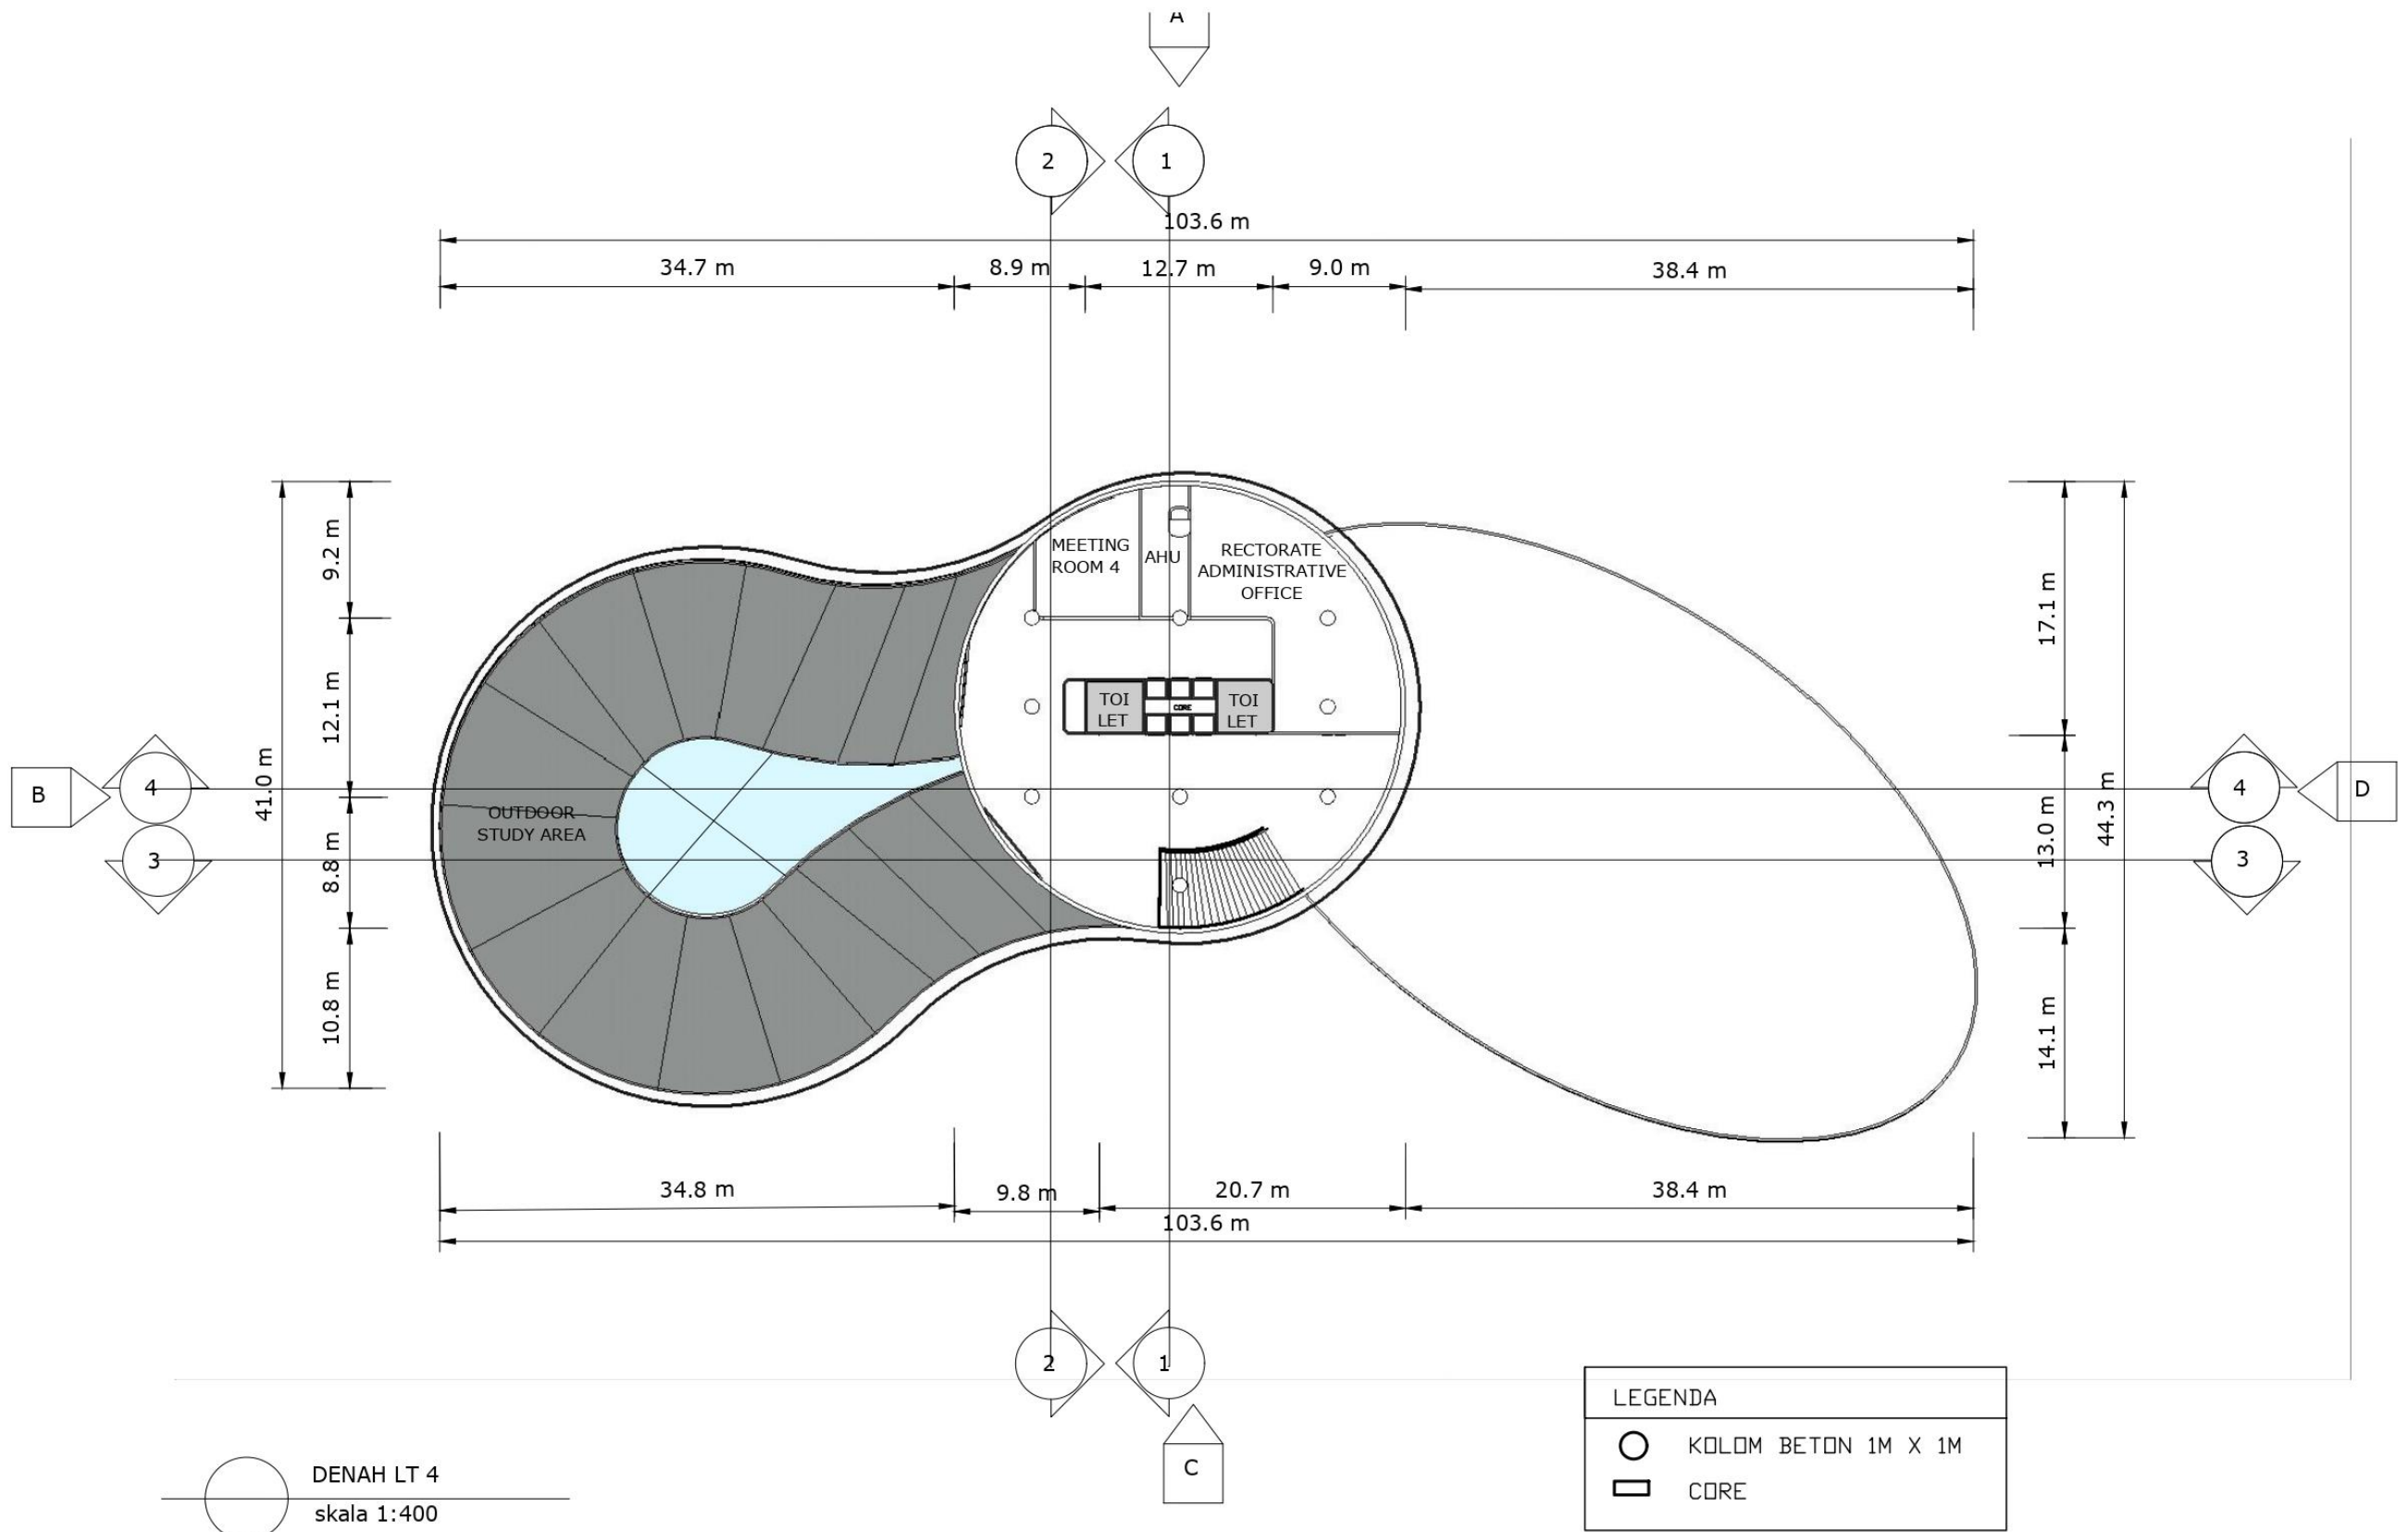


DENAH LT 4
skala 1:400

LEGENDA	
○	KOLOM BETON 1M X 1M
□	CORE

	NAMA - NIM	MATA KULIAH	TUTOR	DOSEN
		JESSICA NATALIA 0206031910017	COMMERCIAL SPACE DESIGN	PAK FREDDY

PRODUCED BY AN AUTODESK STUDENT VERSION

PRODUCED BY AN AUTODESK STUDENT VERSION

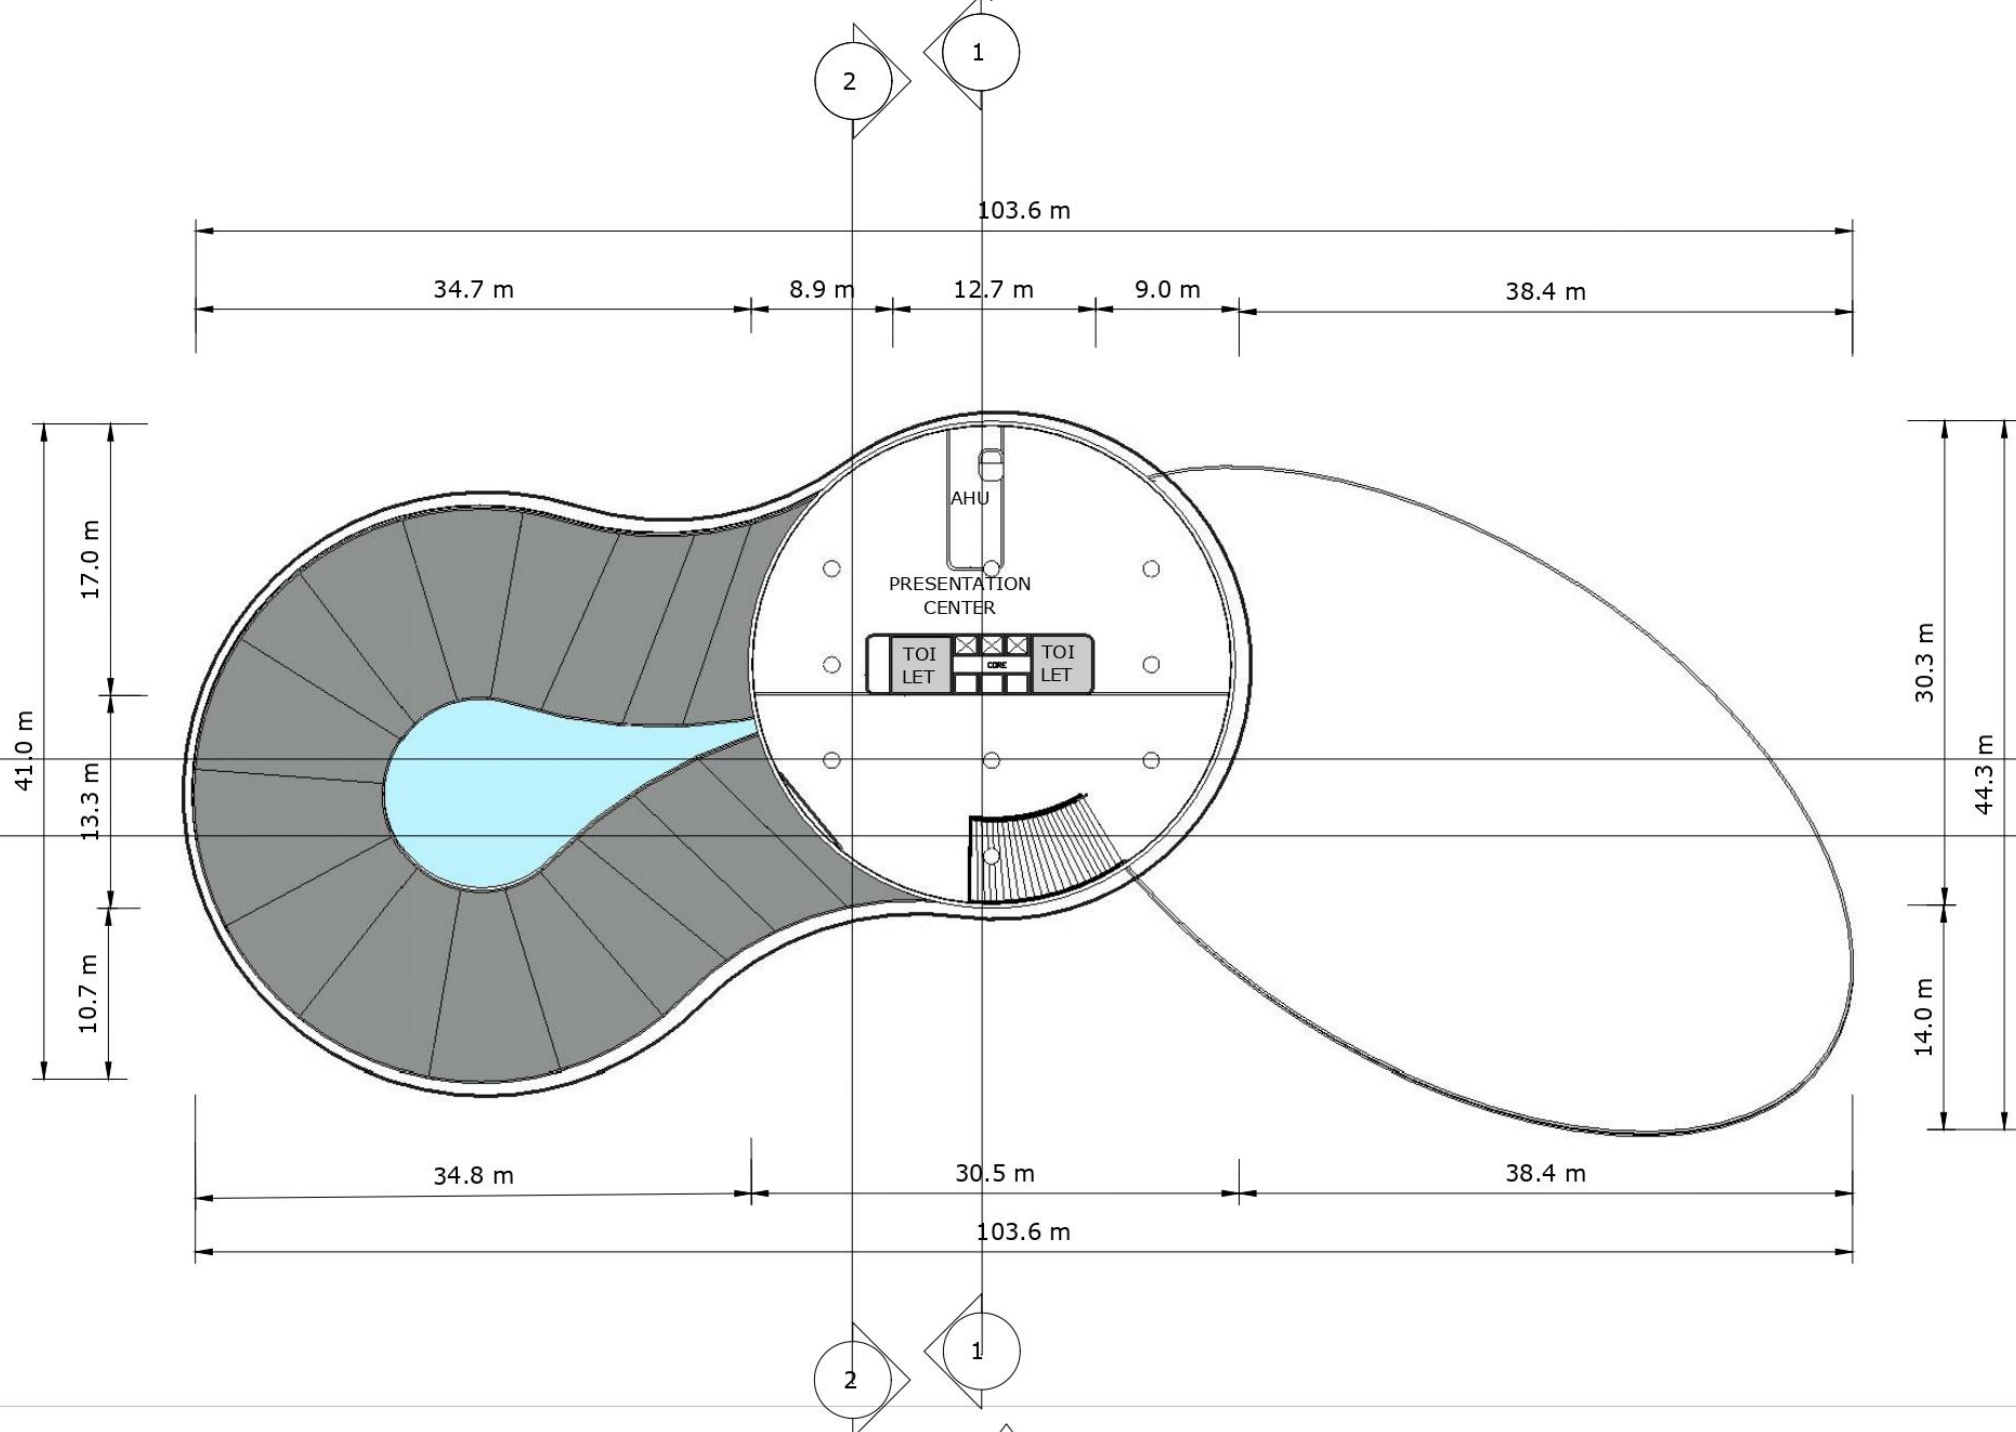

DENAH LT 5
skala 1:400


LEGENDA	
	KOLOM BETON 1M X 1M
	CORE

PRODUCED BY AN AUTODESK STUDENT VERSION

	NAMA - NIM	MATA KULIAH	TUTOR	DOSEN
	JESSICA NATALIA 0206031910017	COMMERCIAL SPACE DESIGN	PAK FREDDY	PAK YUSUF


PRODUCED BY AN AUTODESK STUDENT VERSION


PRODUCED BY AN AUTODESK STUDENT VERSION

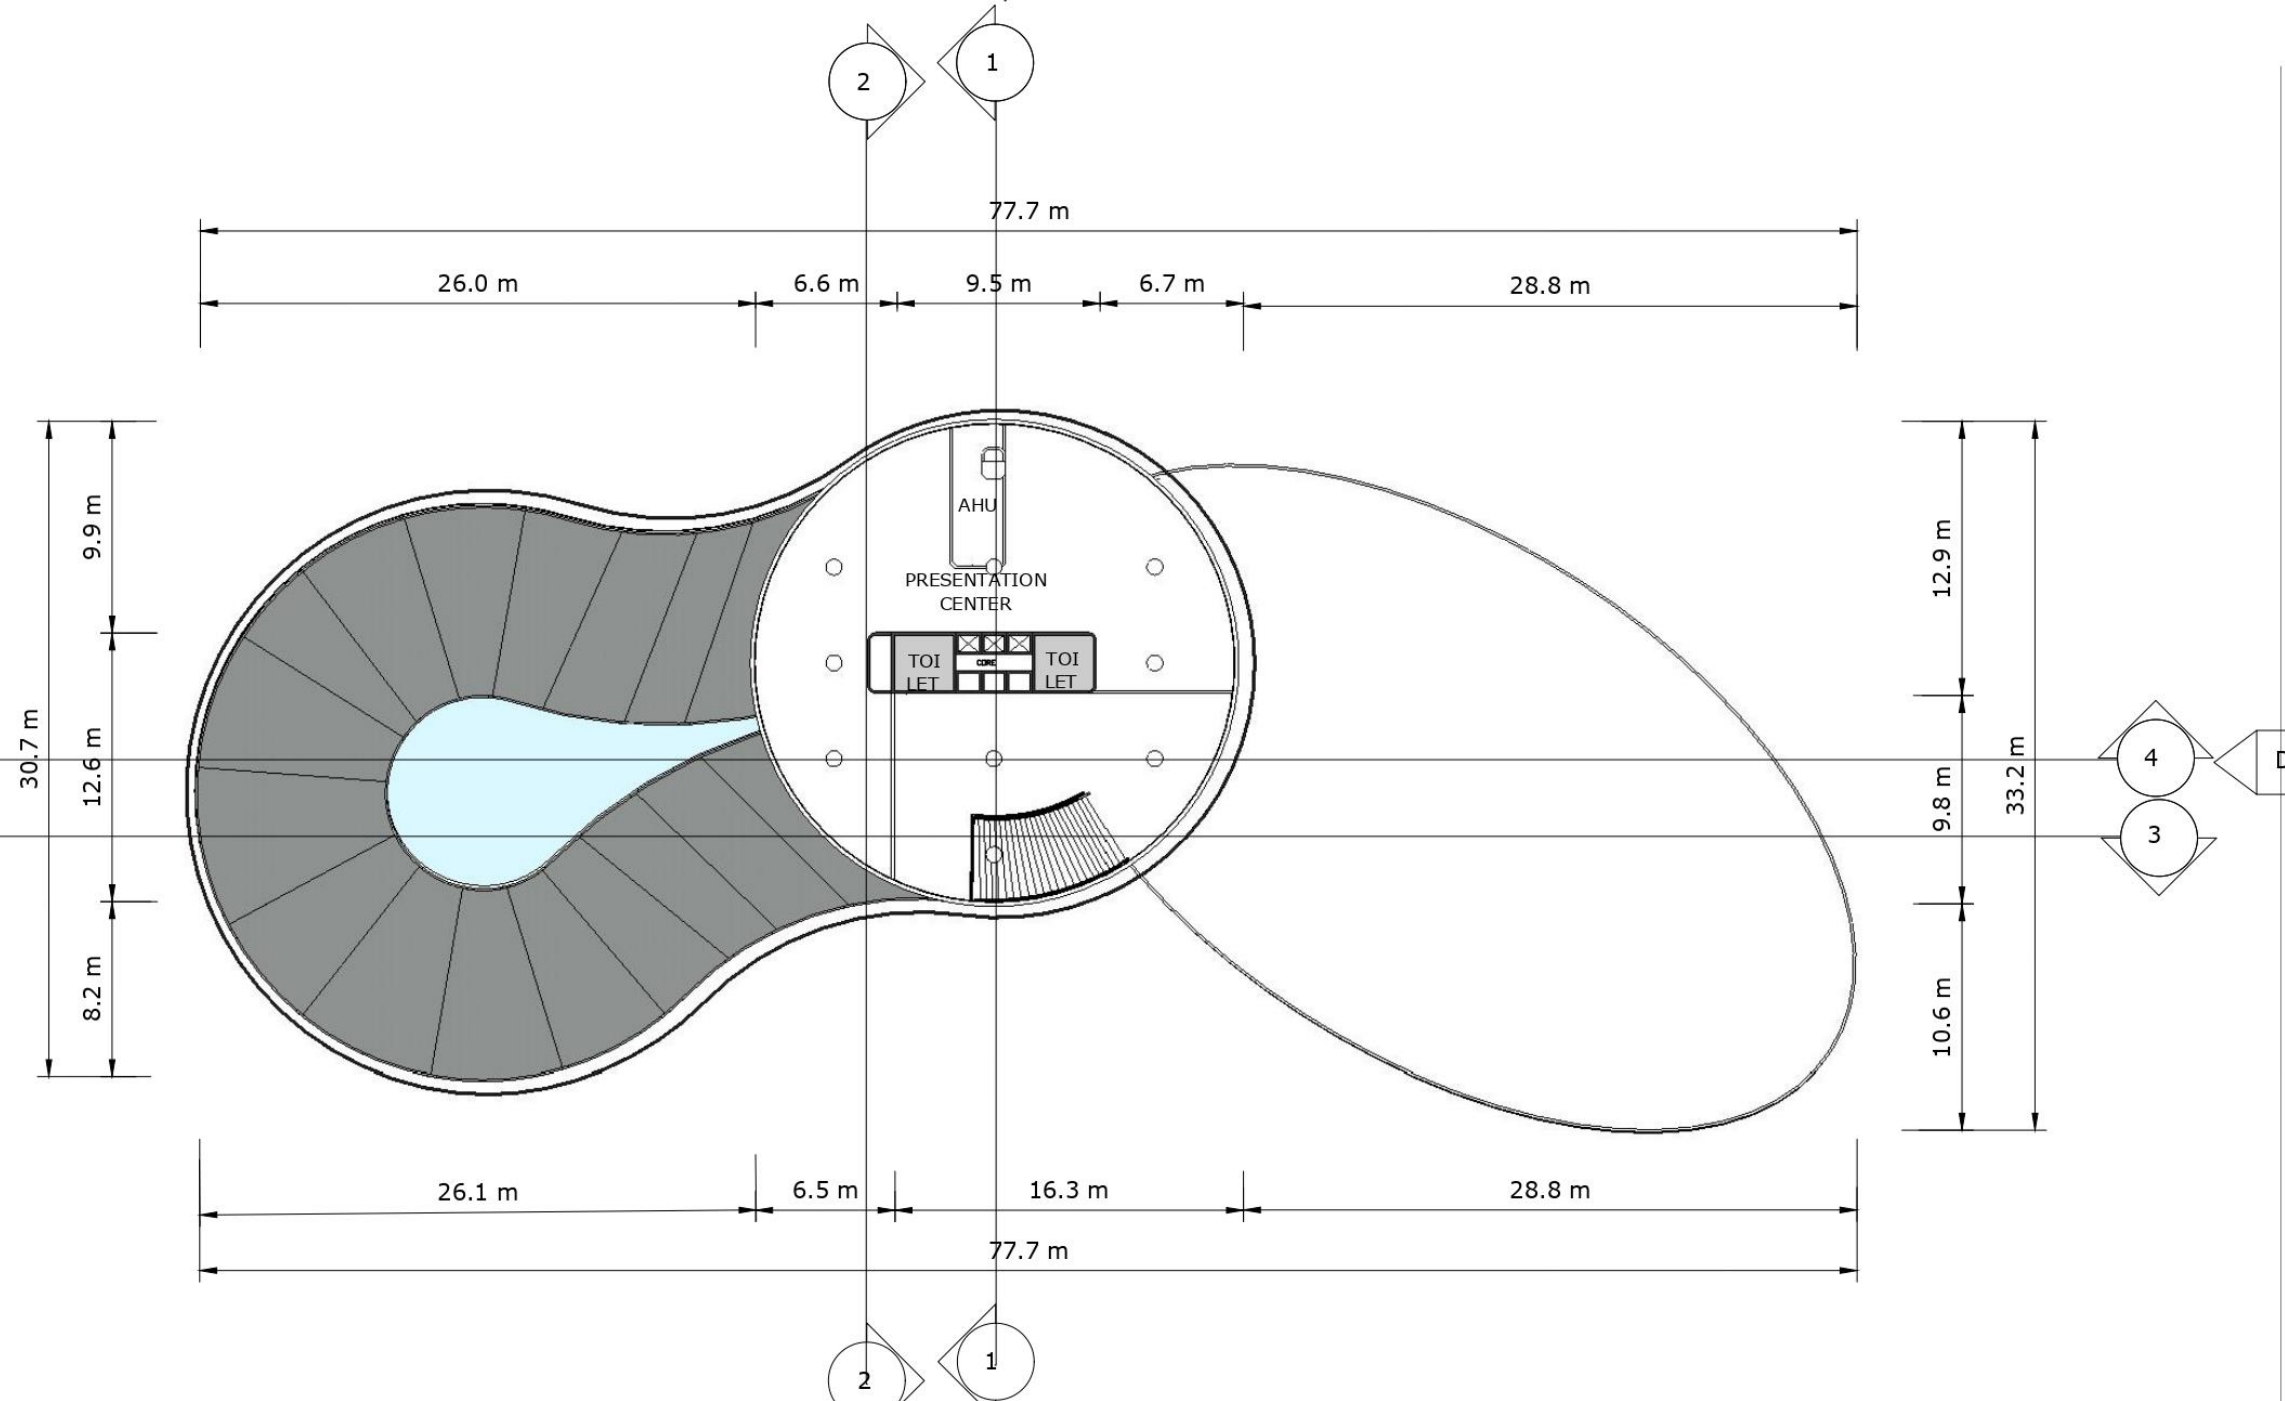

LEGENDA	
○	KOLOM BETON 1M X 1M
□	CORE


○ DENAH LT 6
skala 1:400

	NAMA - NIM	MATA KULIAH	TUTOR	DOSEN
		JESSICA NATALIA 0206031910017	COMMERCIAL SPACE DESIGN	PAK FREDDY

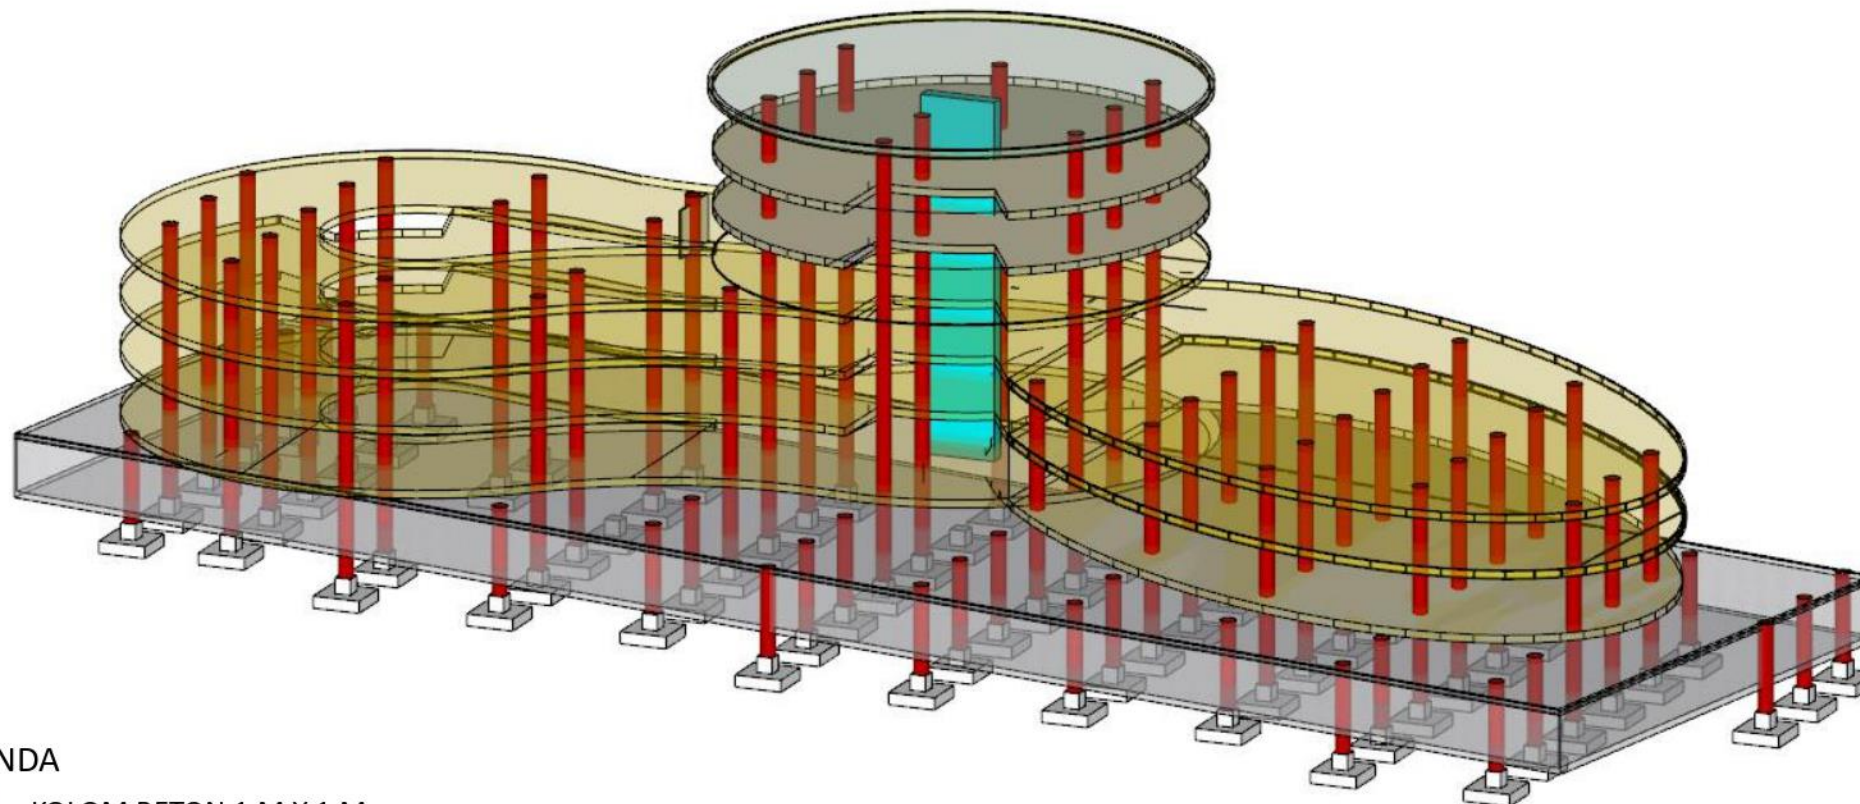

LEGENDA

- KOLOM BETON 1 M X 1 M
- CORE
- PLAT LANTAI
- PONDASI FOOT PLAT
- UNDERGROUND GARAGE

	NAMA - NIM	MATA KULIAH	TUTOR	DOSEN
	JESSICA NATALIA 0206031910017	COMMERCIAL SPACE DESIGN	PAK FREDDY	PAK YUSUF